


BCDA OFFICE

QUAD 1 AEROPARK-BUILDING B
CLARK FREE PORT ZONE, PAMPANGA



GLOBAL GATEWAY, DEVELOPMENT CORPORATION

NOTE : ALL WALLS INTERSECTING EXTERIOR WALL OF BUILDING TERMINATE AT WINDOW MULLION AS PER FIT OUT GUIDELINES.

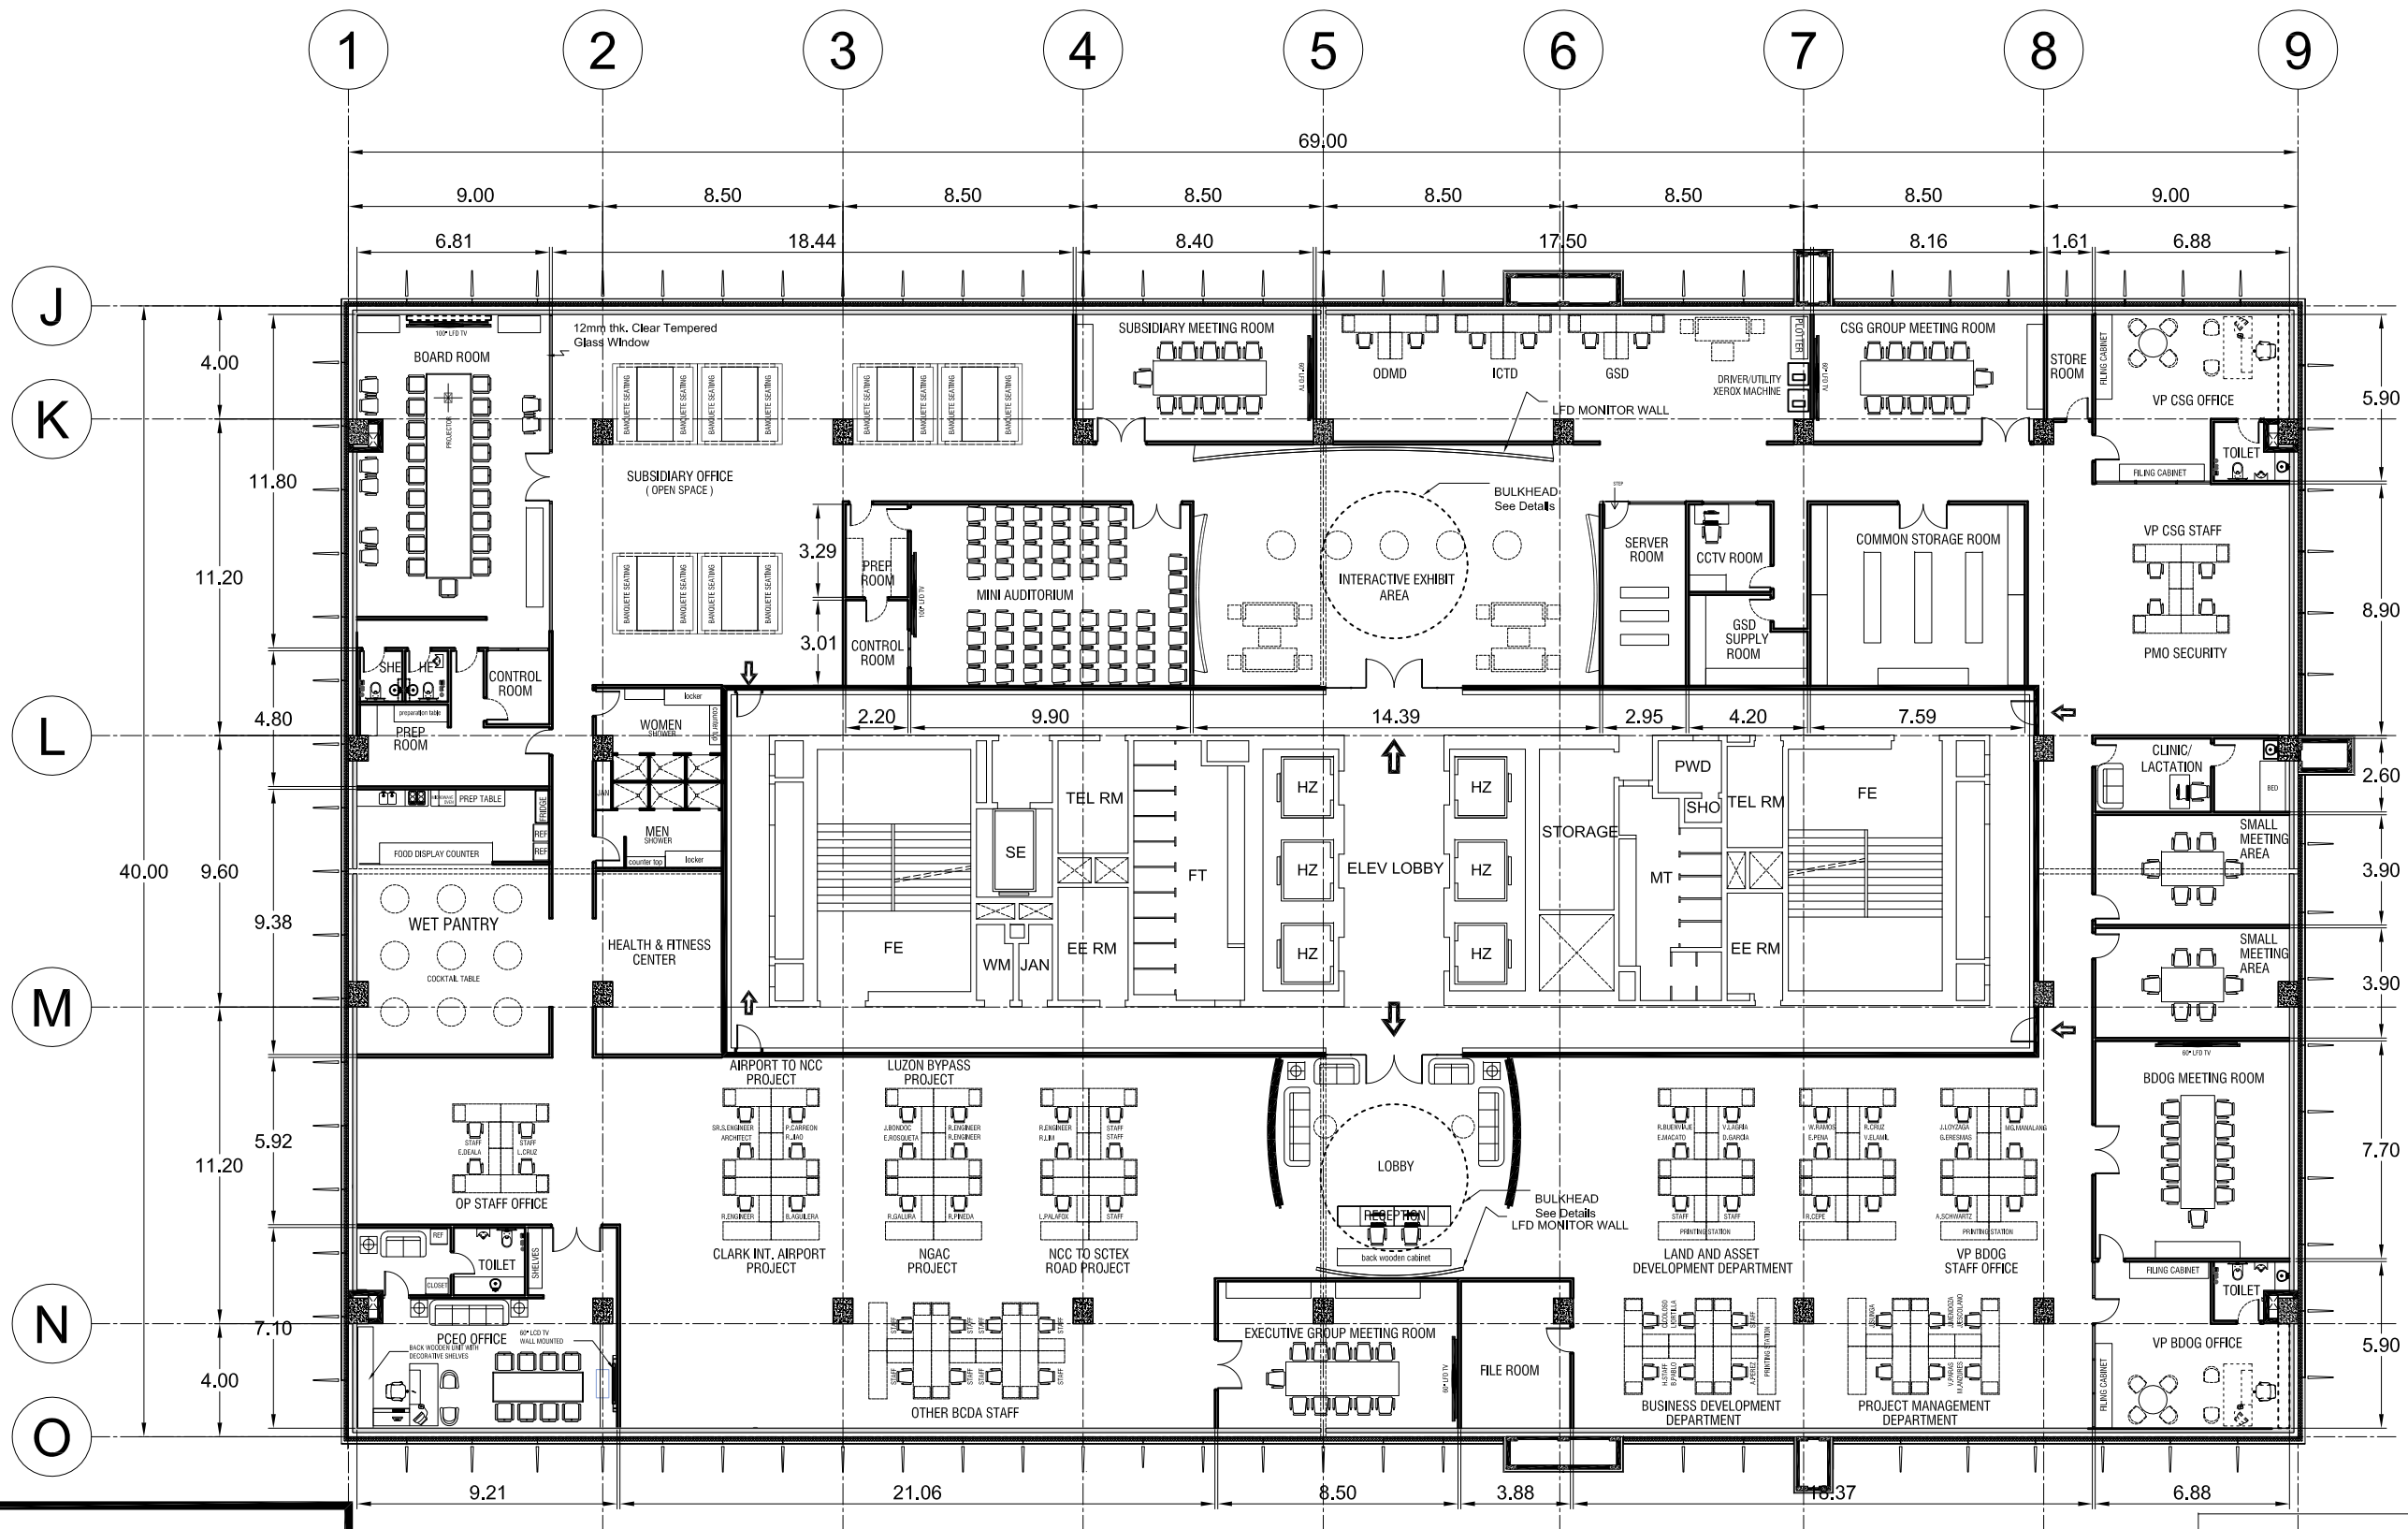

NOTE : WOOD PANELING CLADDING SHOULD BE INSTALLED ON A SUB-WALL MADE OF NON COMBUSTIBLE MATERIALS



GENERAL FLOOR PLAN

BIDDERS AUTHORIZED REPRESENTATIVES

 Signature Over Printed Name



PROJECT NAME	PREPARED BY	CHECKED & REVIEWED BY	RECOMMENDING APPROVAL	APPROVED BY	SHEET CONTENT	SHEET NO.
PROPOSED BCDA OFFICE CLARK FREE PORT ZONE, PAMPANGA	JUDENE G. LAGOY NCC PMO	REINO STEPHEN A. AYO OIC GSD	BGEN CARLOS F. QUITA (RET.) VP CSG	VIVENCIO B. DIZON PRESIDENT AND CEO	GENERAL FLOOR PLAN	A
					SCALE 1 : 250 M. DATE : 03-07-2018	01

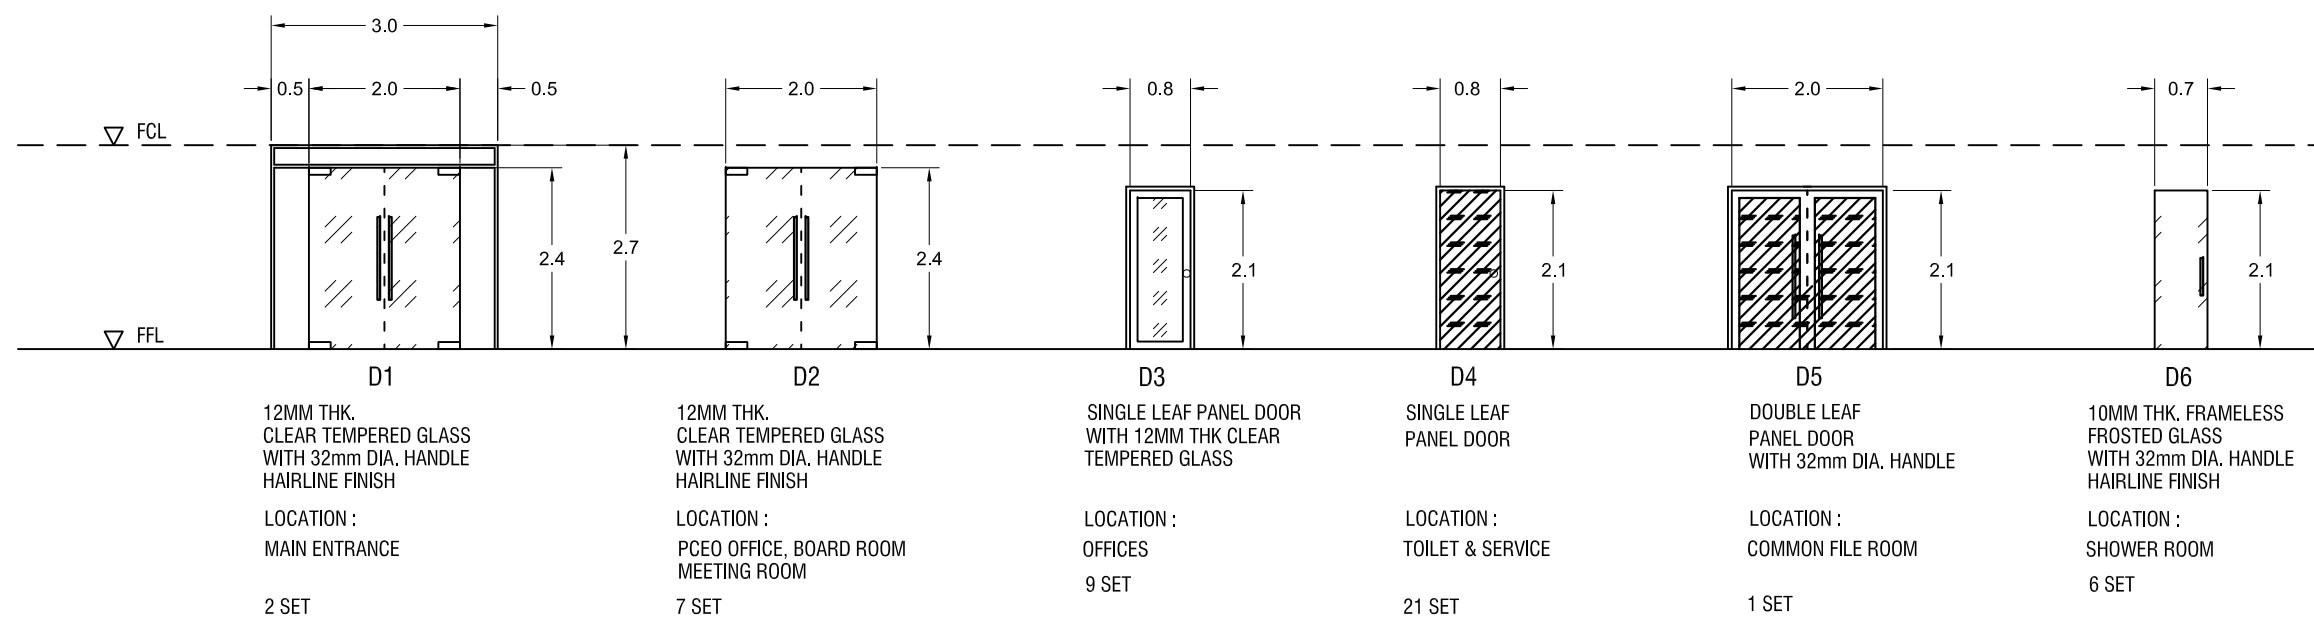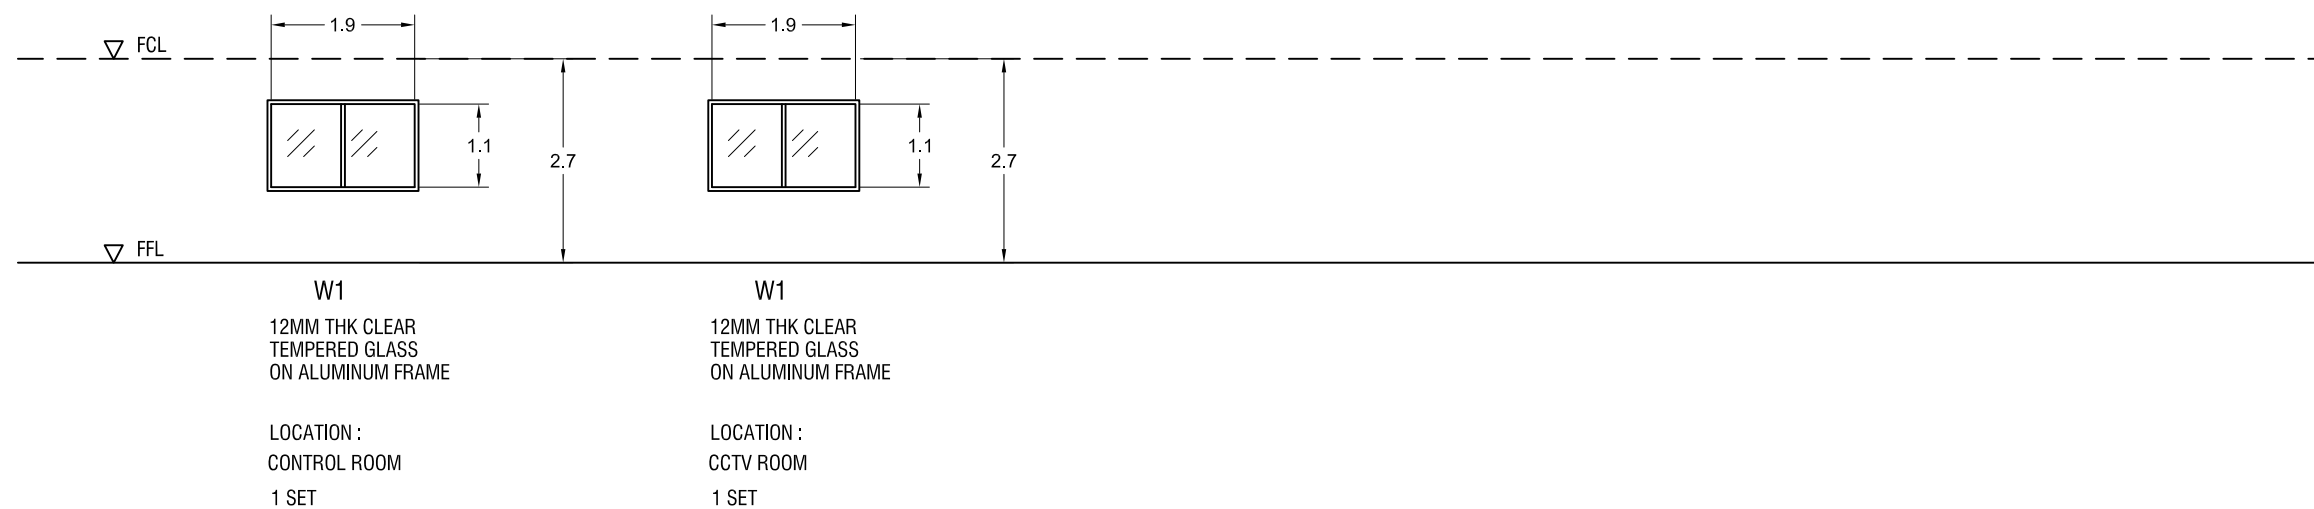



A10
1


SCHEDULE OF DOORS & WINDOWS

SCALE 1:100M


BIDDERS AUTHORIZED REPRESENTATIVES

Signature Over Printed Name

 	PROJECT NAME	PREPARED BY	CHECKED & REVIEWED BY	RECOMMENDING APPROVAL	APPROVED BY	SHEET CONTENT	SHEET NO.
	PROPOSED BCDA OFFICE CLARK FREE PORT ZONE, PAMPANGA	JUDENE G. LAGOY NCC PMO	REINO STEPHEN A. AYO OIC GSD	BGEN CARLOS F. QUITA (RET.) VP CSG	VIVENCIO B. DIZON PRESIDENT AND CEO	SCHEDULE OF DOORS & WINDOWS	A
						SCALE 1:100 M.	DATE: 03-07-2018

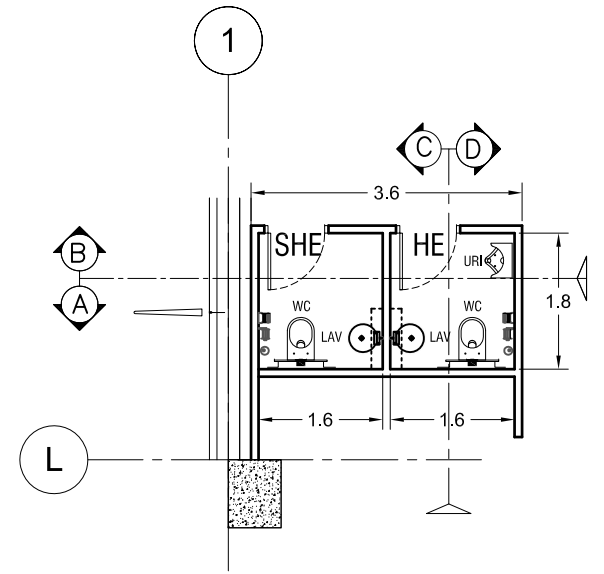


A11
1
BOARDROOM TOILET
SCALE 1:100M

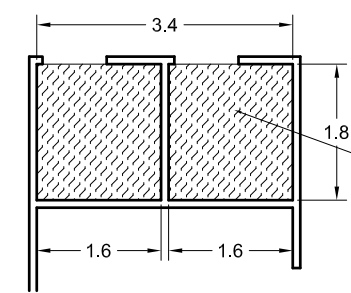


6 M2
WATER PROOFING PLAN


FLUID APPLIED WATERPROOFING MEMBRANE
MINIMUM DRY FILM 55 MILS THICK
BELOW FLOOR FINISH

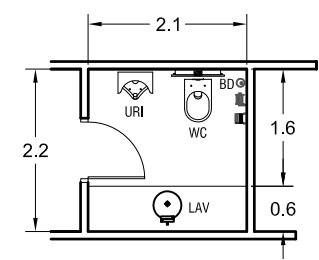


A11
2
PCEO TOILET
SCALE 1:100M

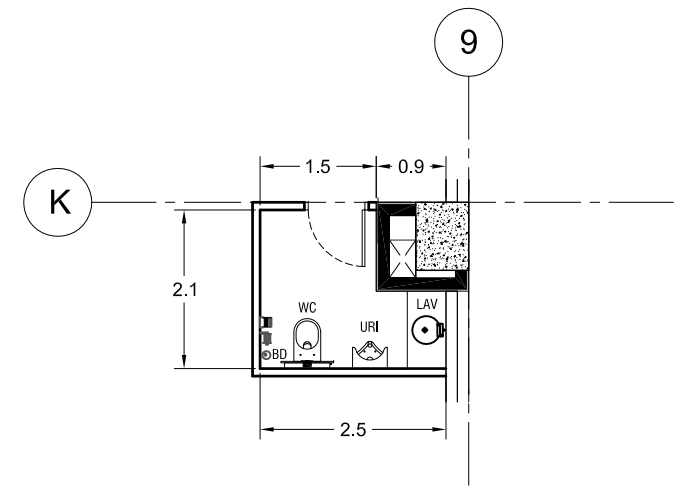

A11
4
CSG TOILET
SCALE 1:100M

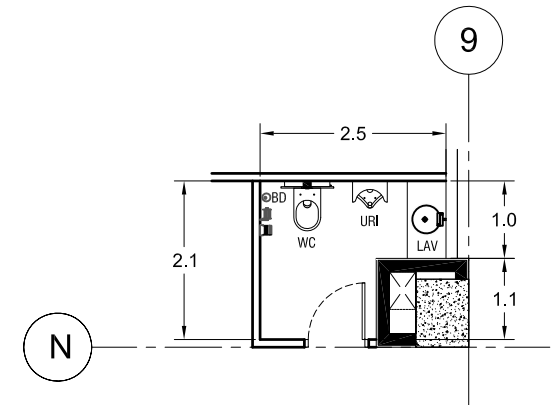

A11
3
BDOG TOILET
SCALE 1:100M

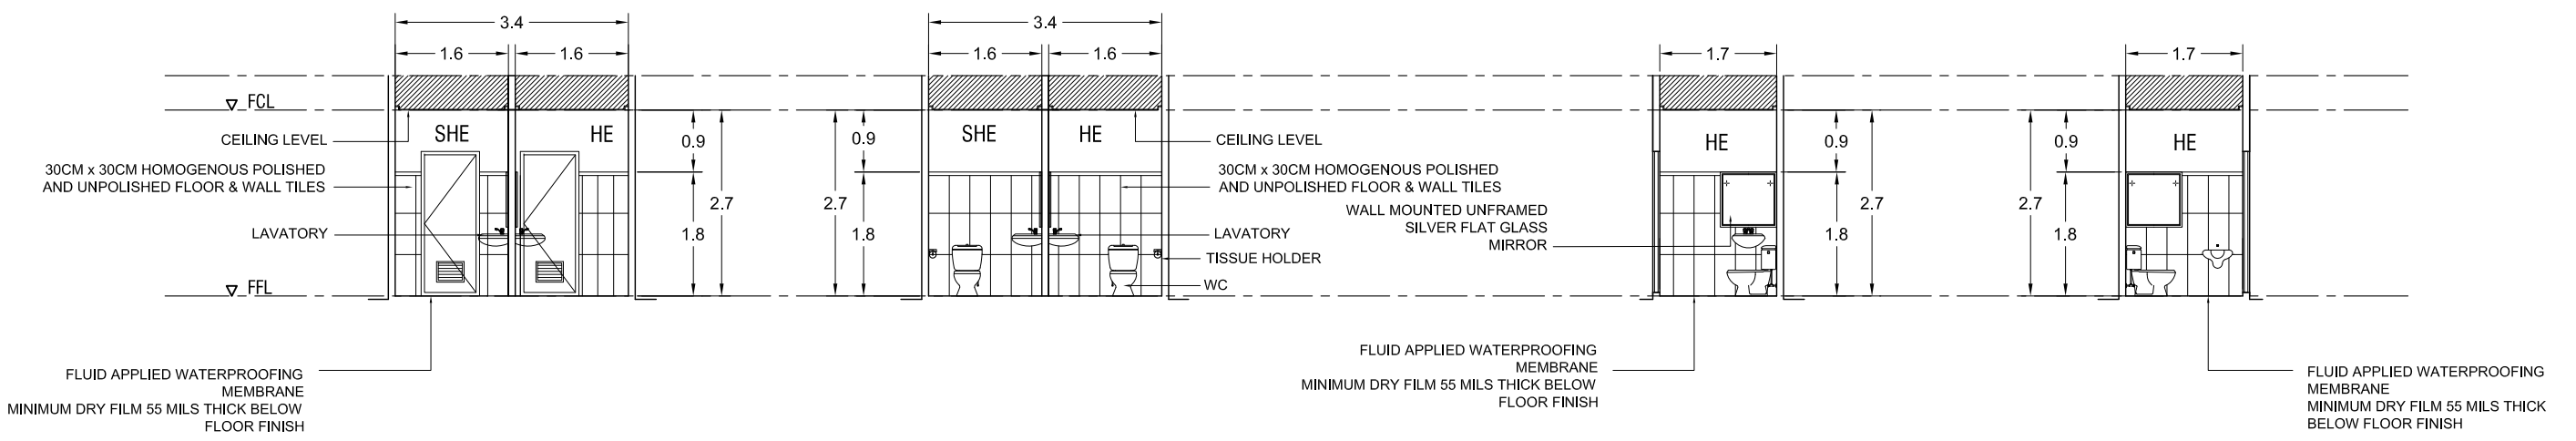

A11
1.1
BOARD ROOM TOILET SECTION A-A
SCALE 1:100M

A11
1.2
BOARD ROOM TOILET SECTION B-B
SCALE 1:100M


A11
1.3
BOARD ROOM TOILET SECTION C-C
SCALE 1:100M

A11
1.4
BOARD ROOM TOILET SECTION D-D
SCALE 1:100M


BIDDERS AUTHORIZED REPRESENTATIVES

Signature Over Printed Name


PROJECT NAME	PREPARED BY	CHECKED & REVIEWED BY	RECOMMENDING APPROVAL	APPROVED BY	SHEET CONTENT	SHEET NO.
PROPOSED BCDA OFFICE CLARK FREE PORT ZONE, PAMPANGA	JUDENE G. LAGOY NCC PMO	REINO STEPHEN A. AYO OIC GSD	BGEN CARLOS F. QUITA (RET.) VP CSG	VIVENCIO B. DIZON PRESIDENT AND CEO	TYPICAL TOILET DETAILS SCALE 1:100 M. DATE: 03-07-2018	A 11

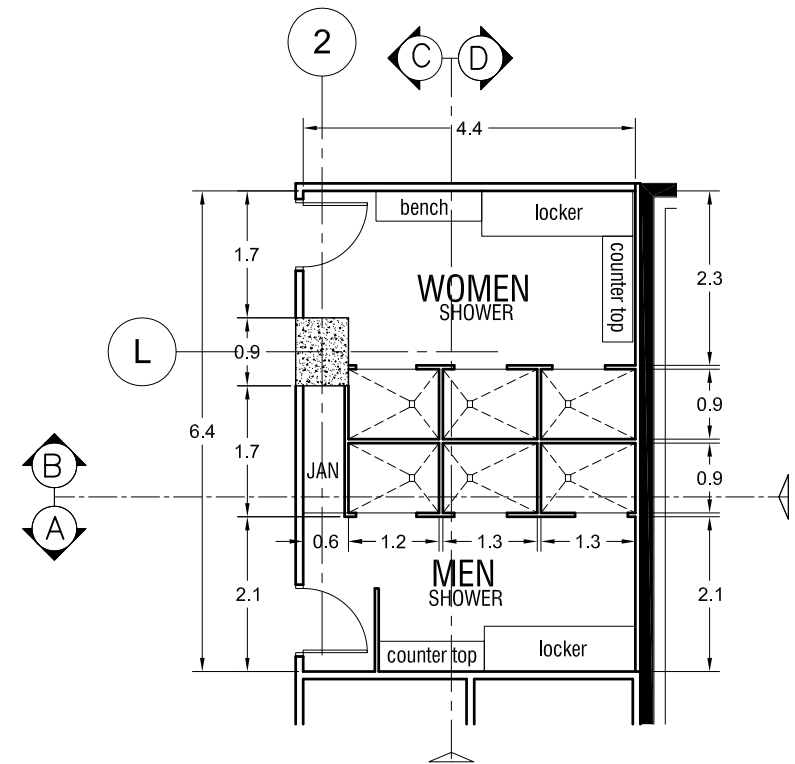

A-12
01
MEN WOMEN SHOWER ROOM
SCALE 1:100M

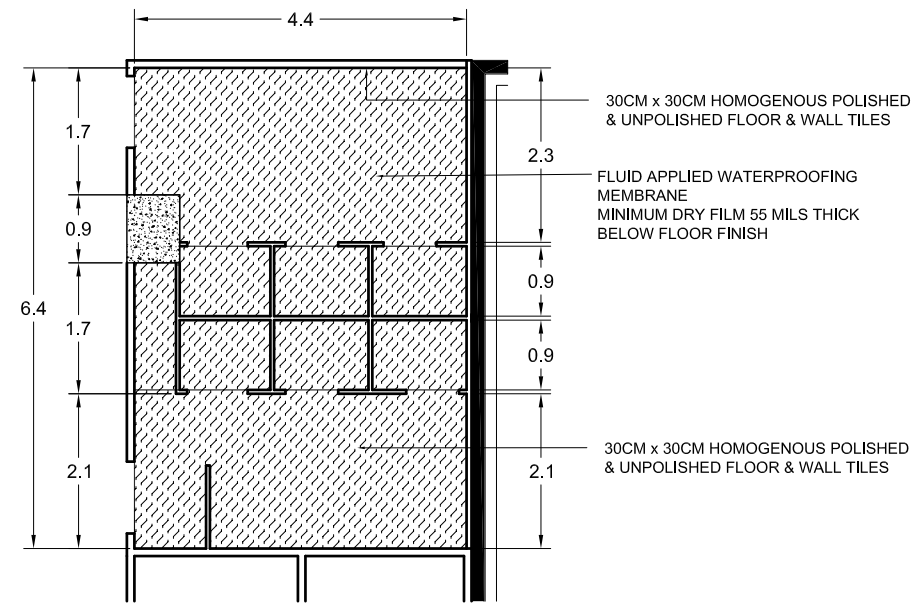

29 M2
A-12
02
WATER PROOFING PLAN
SHOWER ROOM
SCALE 1:100M

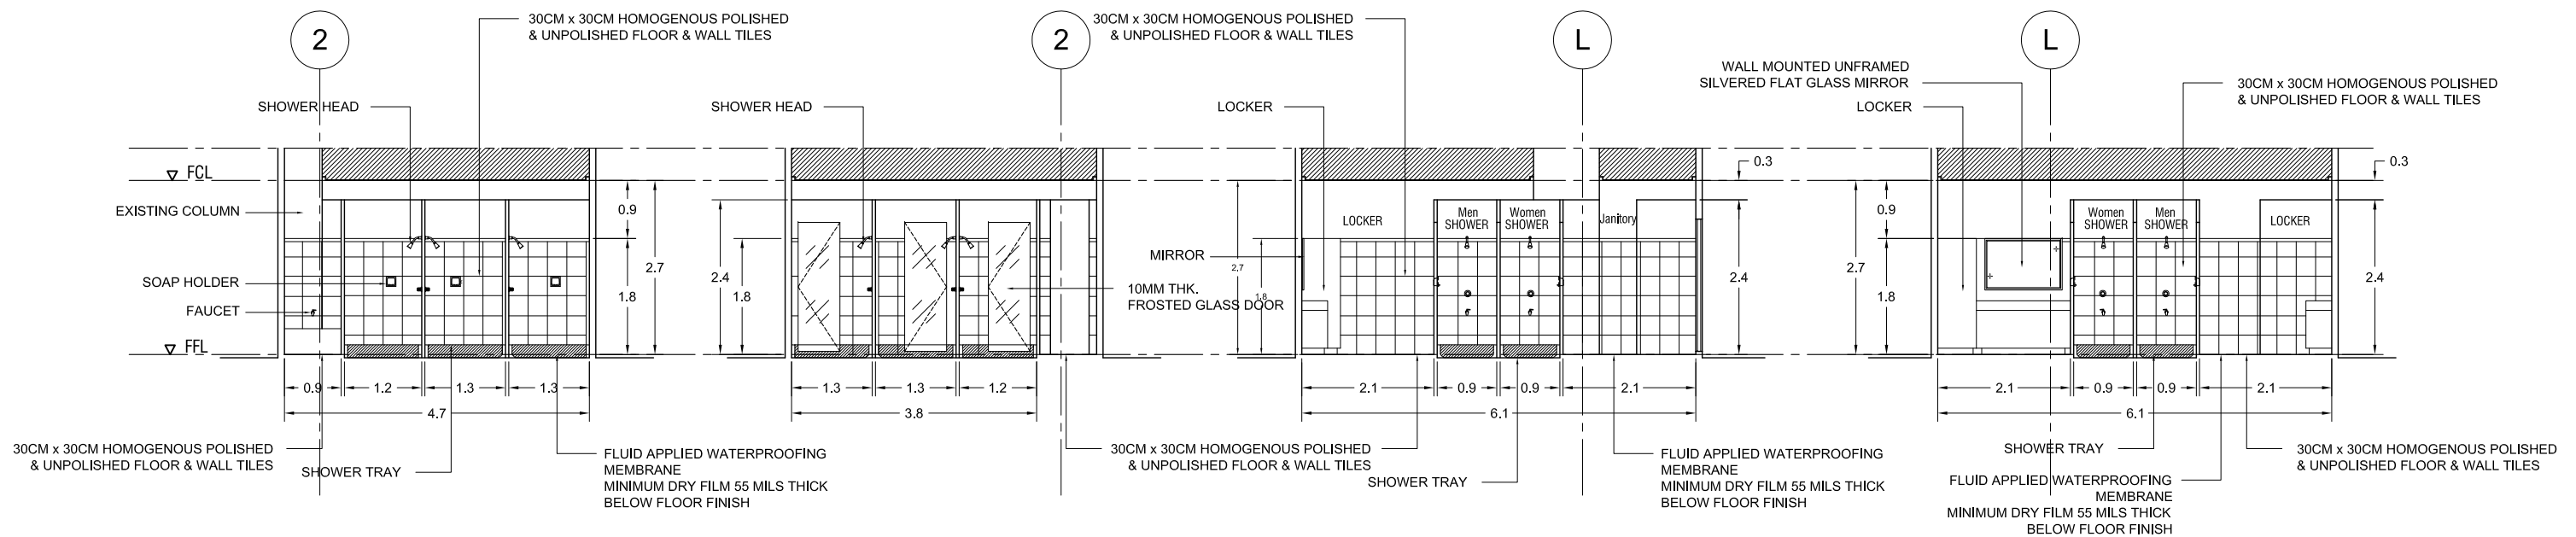

A-12
03
MEN WOMEN SHOWER ROOM
SECTION B-B
SCALE 1:100M


A-12
04
MEN WOMEN SHOWER ROOM
SECTION A-A
SCALE 1:100M

A-12
05
MEN WOMEN SHOWER ROOM
SECTION C-C
SCALE 1:100M

A-12
06
MEN WOMEN SHOWER ROOM
SECTION D-D
SCALE 1:100M

BIDDERS AUTHORIZED REPRESENTATIVES

Signature Over Printed Name

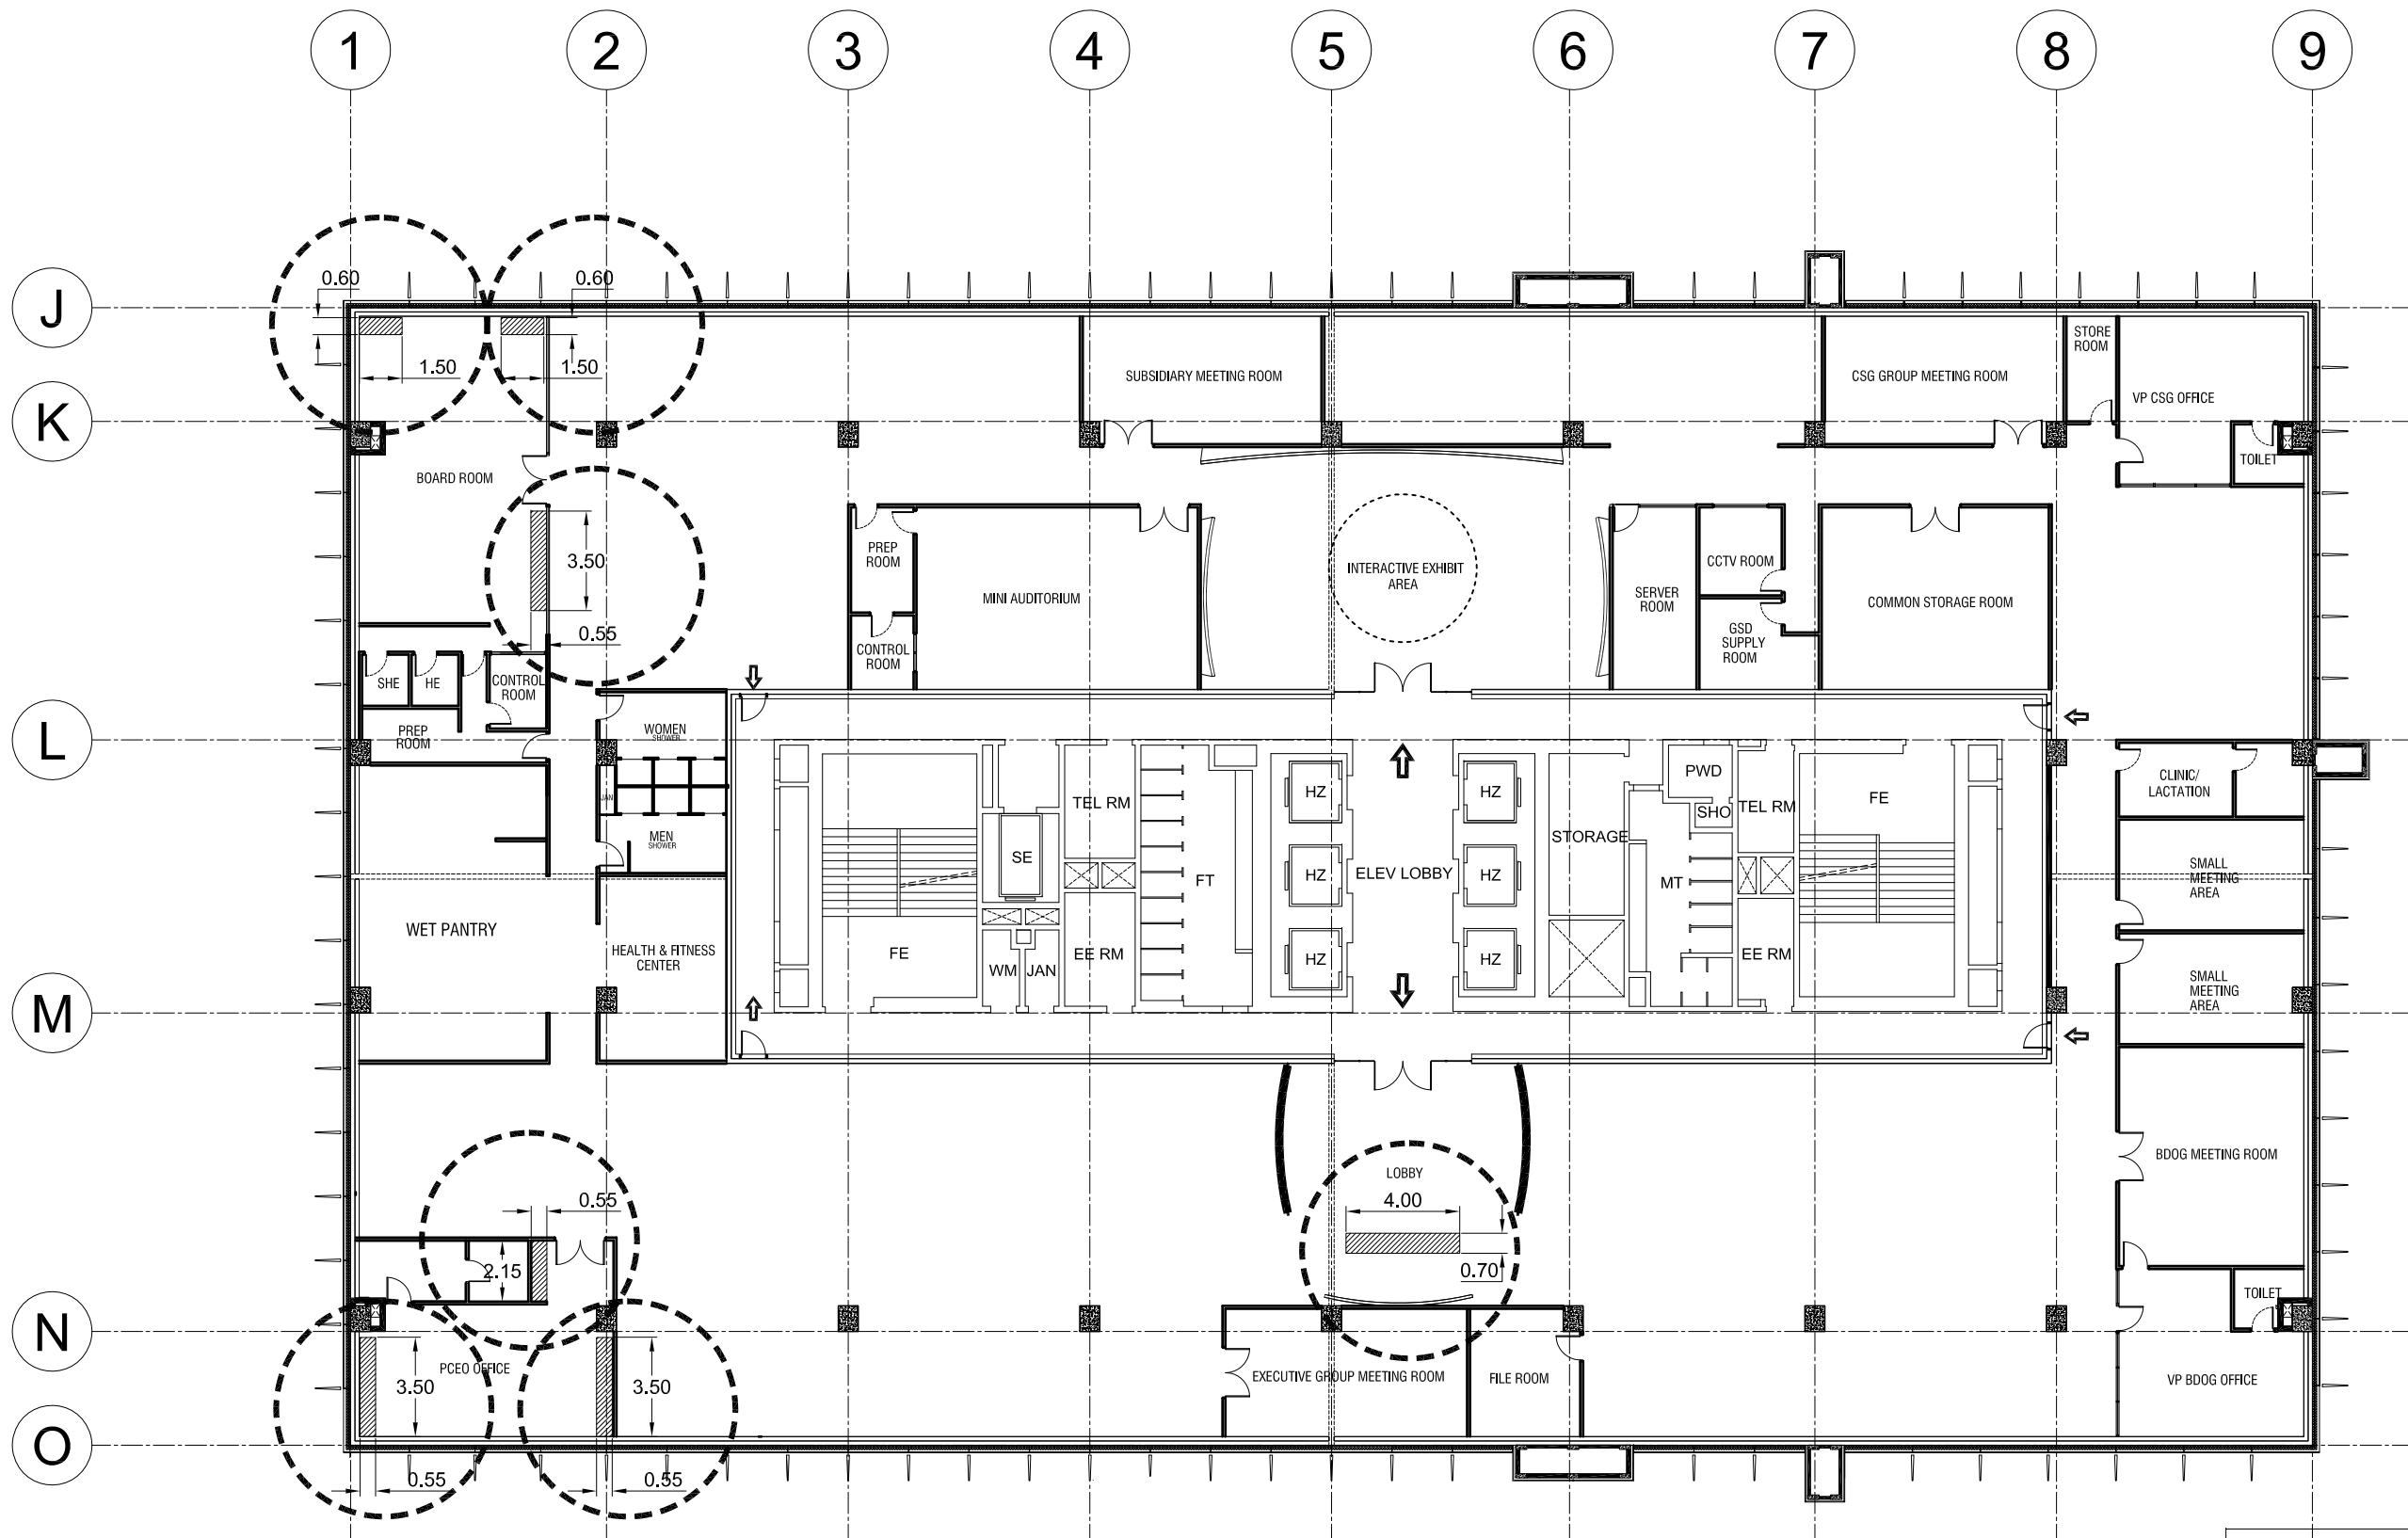

FIXED CABINET LAYOUT

BIDDERS AUTHORIZED REPRESENTATIVES

Signature Over Printed Name



PROJECT NAME
PROPOSED BCDA OFFICE
CLARK FREE PORT ZONE, PAMPANGA

PREPARED BY
JUDENE G. LAGOY
NCC PMO


CHECKED & REVIEWED BY
REINO STEPHEN A. AYO
OIC GSD

RECOMMENDING APPROVAL
BGEN CARLOS F. QUITA (RET.)
VP CSG


APPROVED BY
VIVENCIO B. DIZON
PRESIDENT AND CEO

SHEET CONTENT
FIXED CABINET LAYOUT
SCALE 1 : 250 M. DATE : 03-07-2018


SHEET NO.
A
13

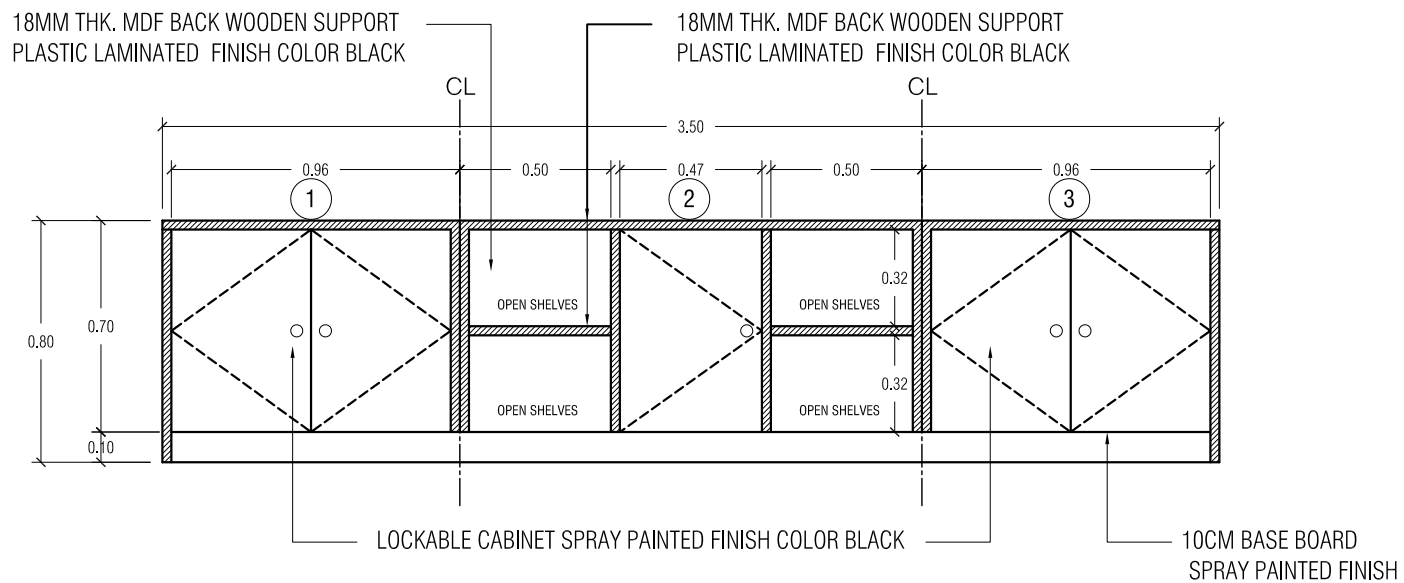


A-14
02 FRONT VIEW
SCALE 1:50 M

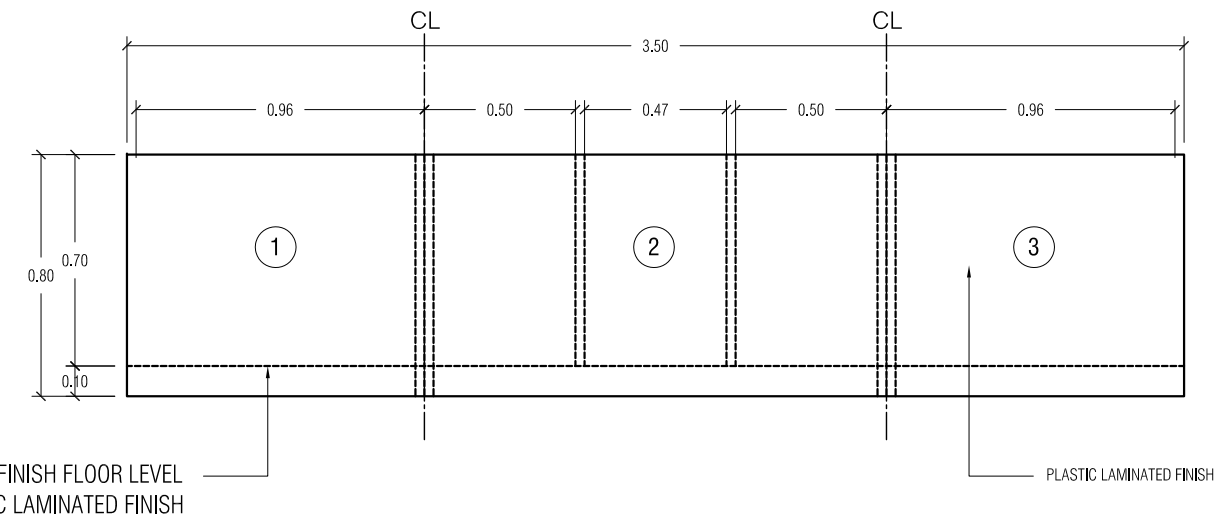

A-14
03 BACK VIEW
SCALE 1:50 M

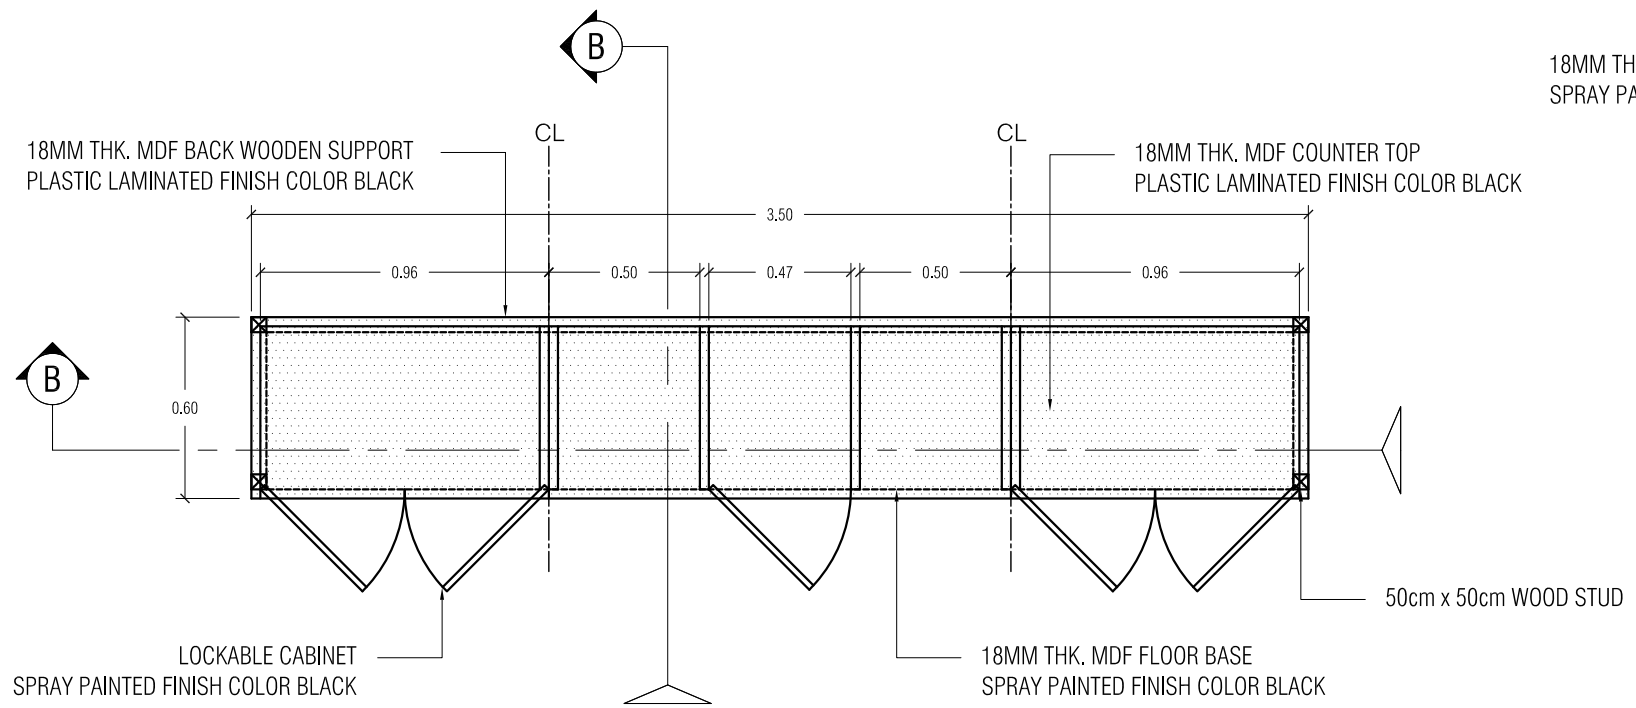

A-14
01 4 SETS
CABINET 1 PLAN & DETAILS
SCALE 1:50 M

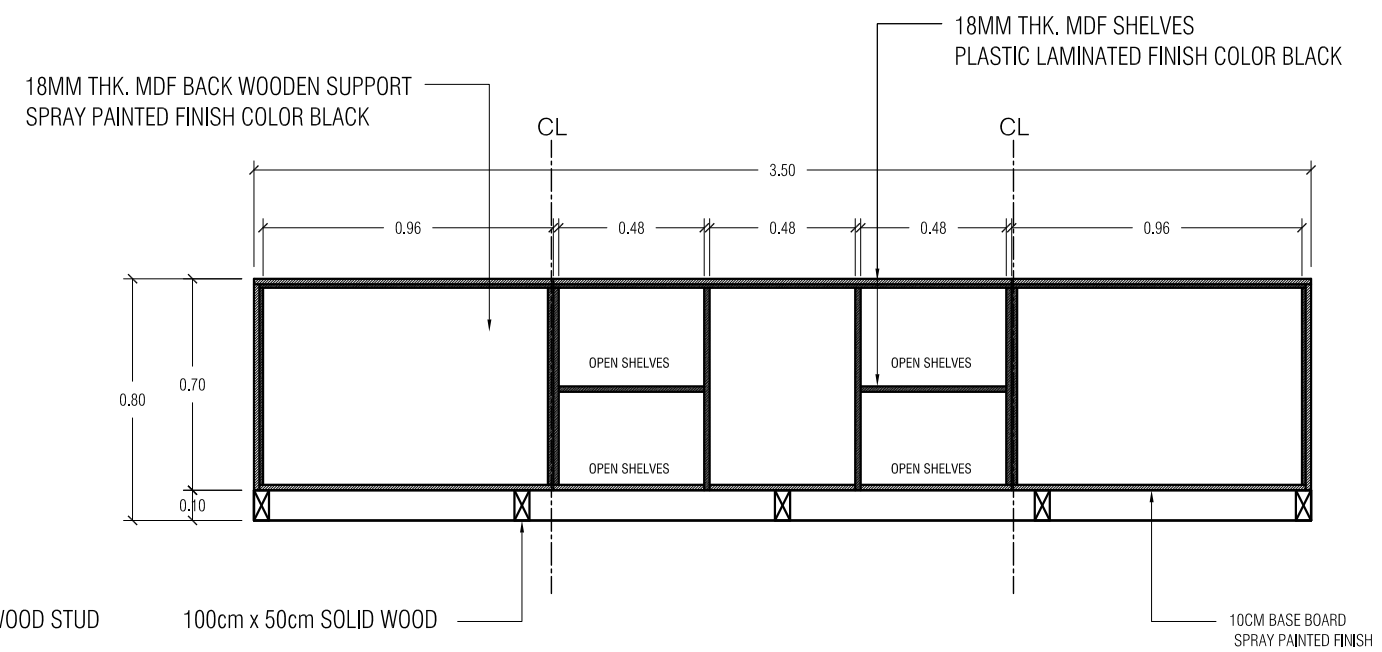


A-14
04 SECTION B-B
SCALE 1:50 M

BIDDERS AUTHORIZED REPRESENTATIVES

Signature Over Printed Name

18MM THK. MDF COUNTER TOP
PLASTIC LAMINATED FINISH COLOR BLACK

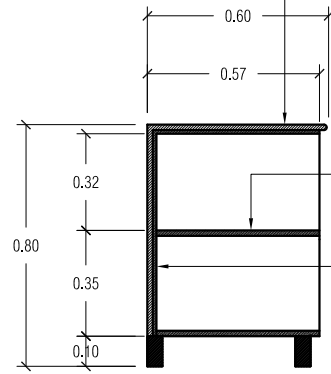


18MM THK. MDF SHELVES
PLASTIC LAMINATED FINISH COLOR BLACK

18MM THK. MDF BACK WOODEN SUPPORT
PLASTIC LAMINATED FINISH COLOR BLACK

A-15
04 TYP. SECTION A-A
SCALE 1:50 M


18MM THK. MDF COUNTER TOP
PLASTIC LAMINATED FINISH COLOR BLACK

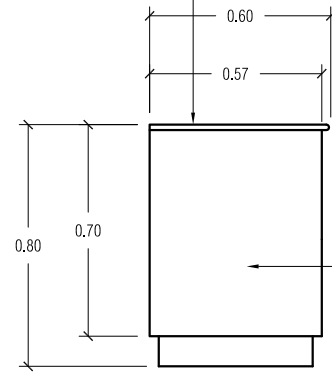

18MM THK. MDF SIDE WALL
PLASTIC LAMINATED FINISH COLOR BLACK

A-15
03 TYP. SIDE VIEW
SCALE 1:50 M

18MM THK. MDF COUNTER TOP
PLASTIC LAMINATED FINISH COLOR BLACK

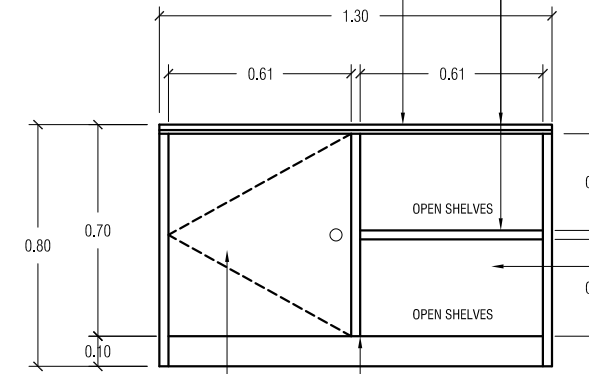

18MM THK. MDF COUNTER TOP
PLASTIC LAMINATED FINISH COLOR BLACK


18MM THK. MDF BACK WOODEN SUPPORT
SPRAY PAINTED FINISH COLOR BLACK

LOCKABLE CABINET
PLASTIC LAMINATED FINISH COLOR BLACK

10CM BASE BOARD
SPRAY PAINTED FINISH

A-15
02 FRONT VIEW
SCALE 1:50 M

18MM THK. MDF BACK WOODEN SUPPORT
SPRAY PAINTED FINISH COLOR BLACK

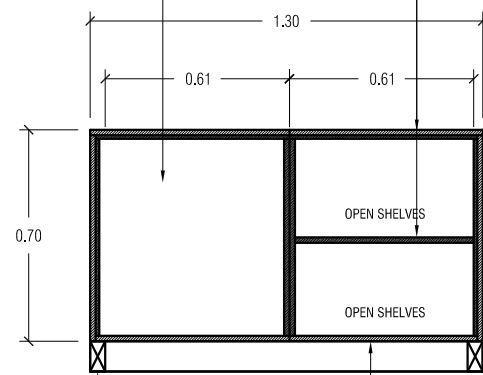


18MM THK. MDF SHELVES
PLASTIC LAMINATED FINISH COLOR BLACK

100cm x 50cm SOLID WOOD

10CM BASE BOARD
SPRAY PAINTED FINISH

A-15
05 SECTION B-B
SCALE 1:50 M

18MM THK. MDF BACK WOODEN SUPPORT
PLASTIC LAMINATED FINISH COLOR BLACK

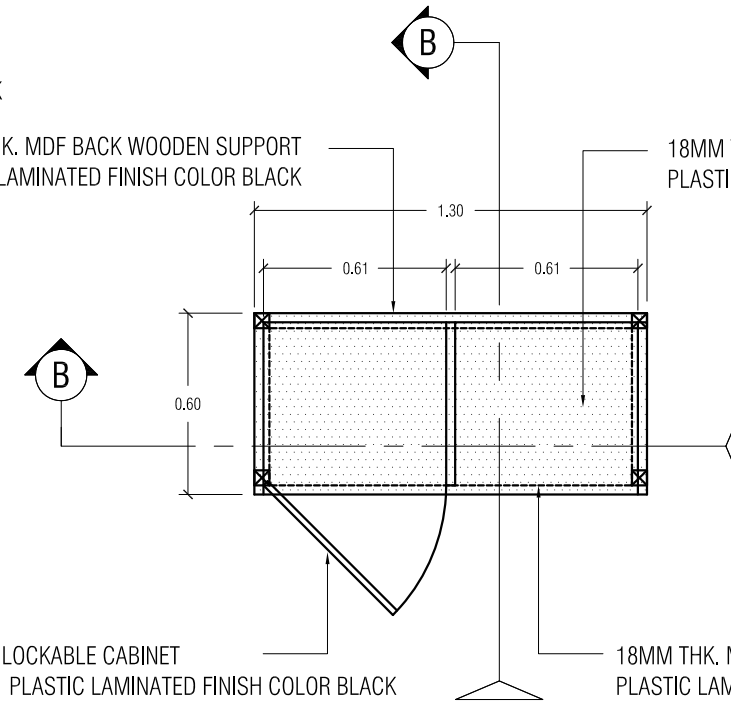

18MM THK. MDF COUNTER TOP
PLASTIC LAMINATED FINISH COLOR BLACK

LOCKABLE CABINET
PLASTIC LAMINATED FINISH COLOR BLACK

18MM THK. MDF FLOOR BASE
PLASTIC LAMINATED FINISH COLOR BLACK

3 SETS
A-15
01 CABINET 2 PLAN & DETAILS
SCALE 1:50 M

BIDDERS AUTHORIZED REPRESENTATIVES

Signature Over Printed Name



18MM THK. MDF BACK WOODEN SUPPORT
PLASTIC LAMINATED FINISH COLOR BLACK

B

18MM THK. GRANITE STONE
COUNTER TOP COLOR BLACK

18MM THK. GRANITE STONE
COUNTER TOP COLOR BLACK


18MM THK. MDF BACK WOODEN SUPPORT
PLASTIC LAMINATED FINISH COLOR BLACK

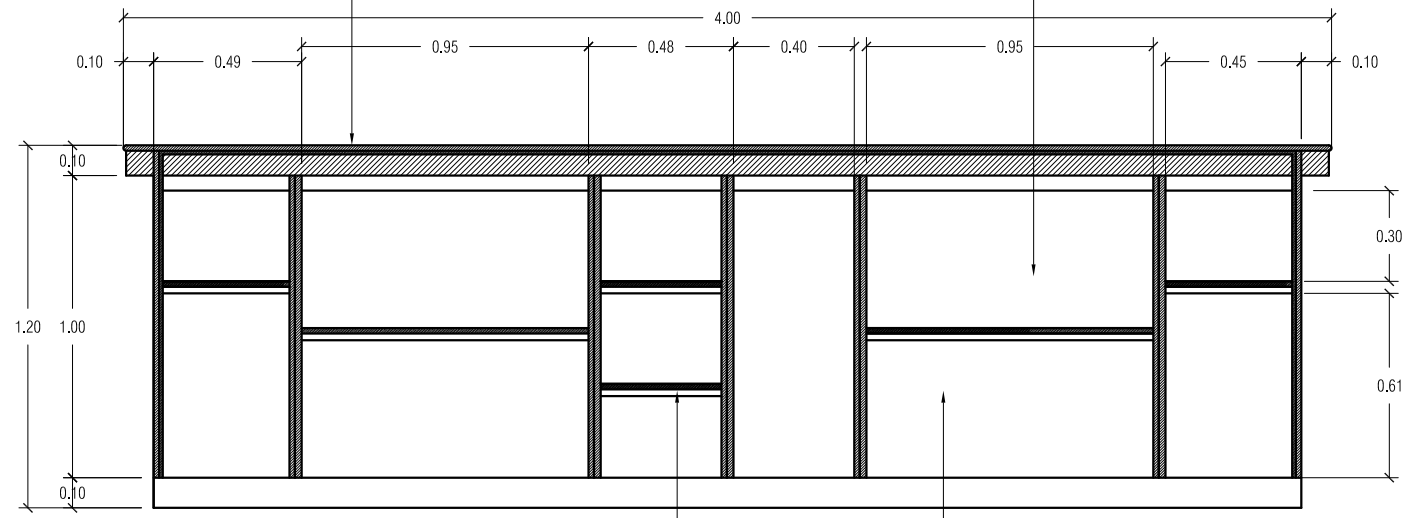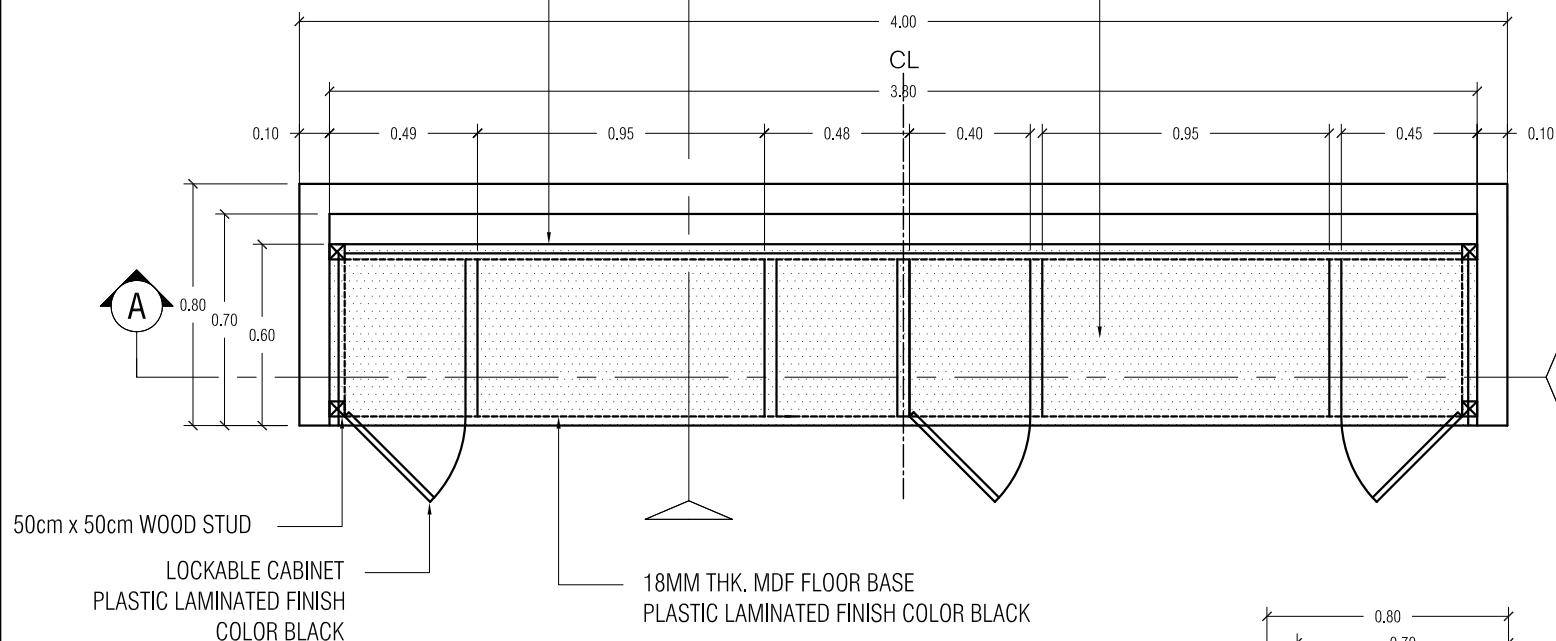

A-16 01
1 SET RECEPTION COUNTER PLAN & DETAILS
SCALE 1:50 M

A-16 04
SECTION A-A
SCALE 1:50 M

18MM THK. MDF COUNTER TOP
PLASTIC LAMINATED FINISH
COLOR BLACK

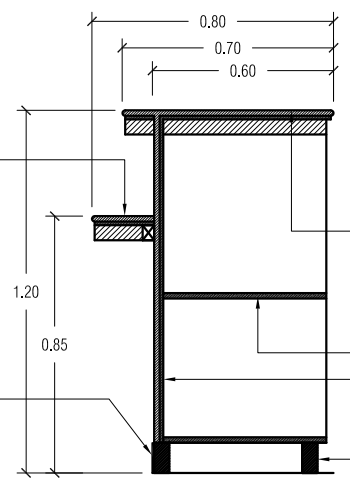

18MM THK. GRANITE STONE
COUNTER TOP COLOR BLACK

18MM THK. MDF OPEN SHELVES CABINET
PLASTIC LAMINATED FINISH COLOR BLACK

18MM THK. MDF BACK WOODEN SUPPORT
PLASTIC LAMINATED FINISH COLOR BLACK

100cm x 50cm SOLID WOOD

18MM THK. GRANITE STONE
COUNTER TOP COLOR BLACK

18MM THK. MDF COUNTER TOP
PLASTIC LAMINATED FINISH COLOR BLACK



18MM THK. MDF BACK WOODEN SUPPORT
PLASTIC LAMINATED FINISH COLOR BLACK

18MM THK. GRANITE STONE
COUNTER TOP COLOR BLACK

LOCKABLE CABINET
PLASTIC LAMINATED FINISH
COLOR BLACK

10CM STAINLESS STEEL
BASE BOARD

A-16 05
SECTION B-B
SCALE 1:50 M

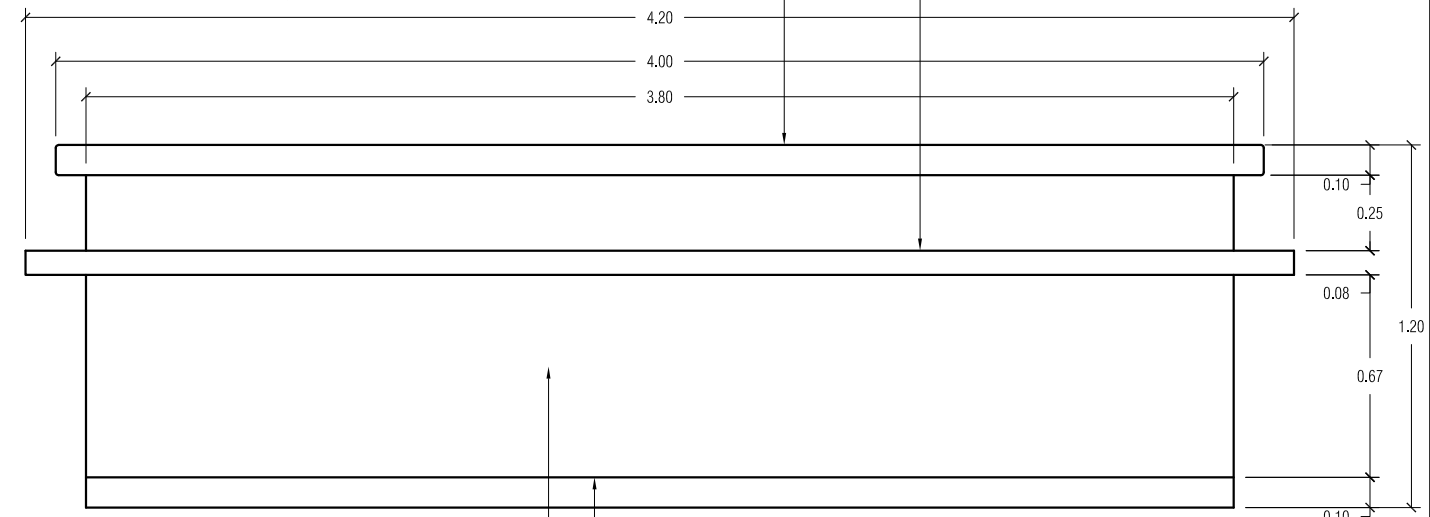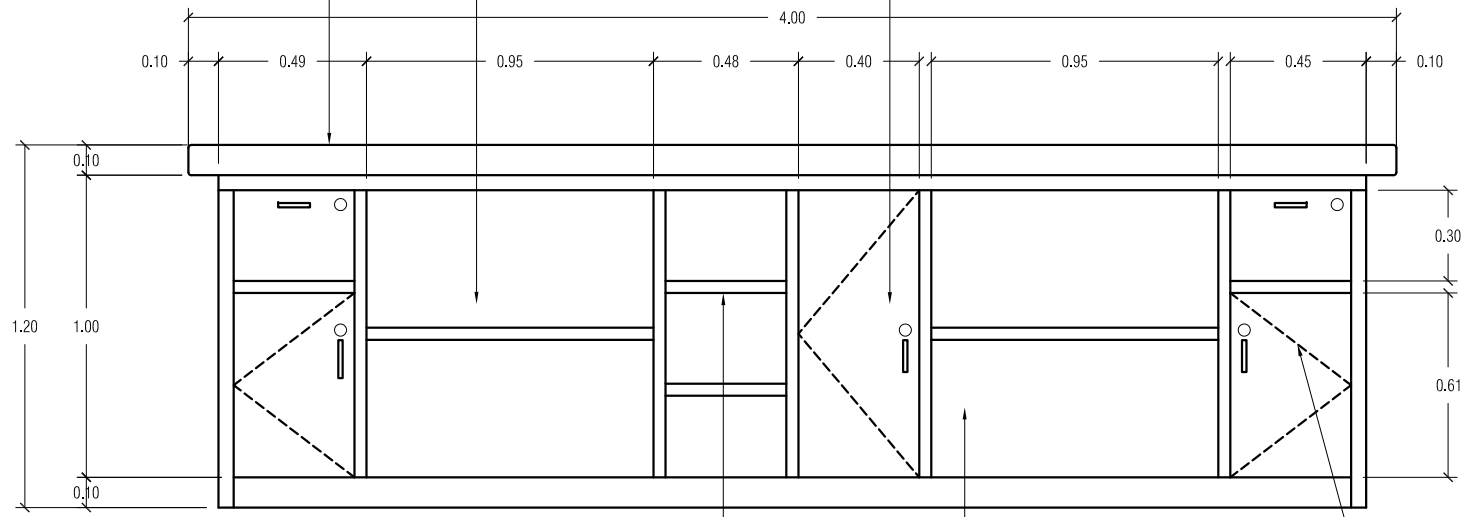

A-16 03
BACK VIEW
SCALE 1:50 M

OPEN SHELVES CABINET
PLASTIC LAMINATED FINISH
COLOR BLACK

OPEN SHELVES CABINET
PLASTIC LAMINATED FINISH
COLOR BLACK

LOCKABLE CABINET
PLASTIC LAMINATED FINISH
COLOR BLACK

A-16 02
FRONT VIEW
SCALE 1:50 M

PLASTIC LAMINATED FINISH

10CM STAINLESS STEEL
BASE BOARD

BIDDERS AUTHORIZED REPRESENTATIVES

Signature Over Printed Name



PROJECT NAME
PROPOSED BCDA OFFICE
CLARK FREE PORT ZONE , PAMPANGA

PREPARED BY
JUDENE G. LAGOY
NCC PMO


CHECKED & REVIEWED BY
REINO STEPHEN AYO
OIC GSD

RECOMMENDING APPROVAL
BGEN CARLOS F. QUITA (RET.)
VP CSG


APPROVED BY
VIVENCIO B. DIZON
PRESIDENT AND CEO

SHEET CONTENT
RECEPTION COUNTER
SCALE 1 : 25 M. DATE : 03-07-2018


SHEET NO.
A
16

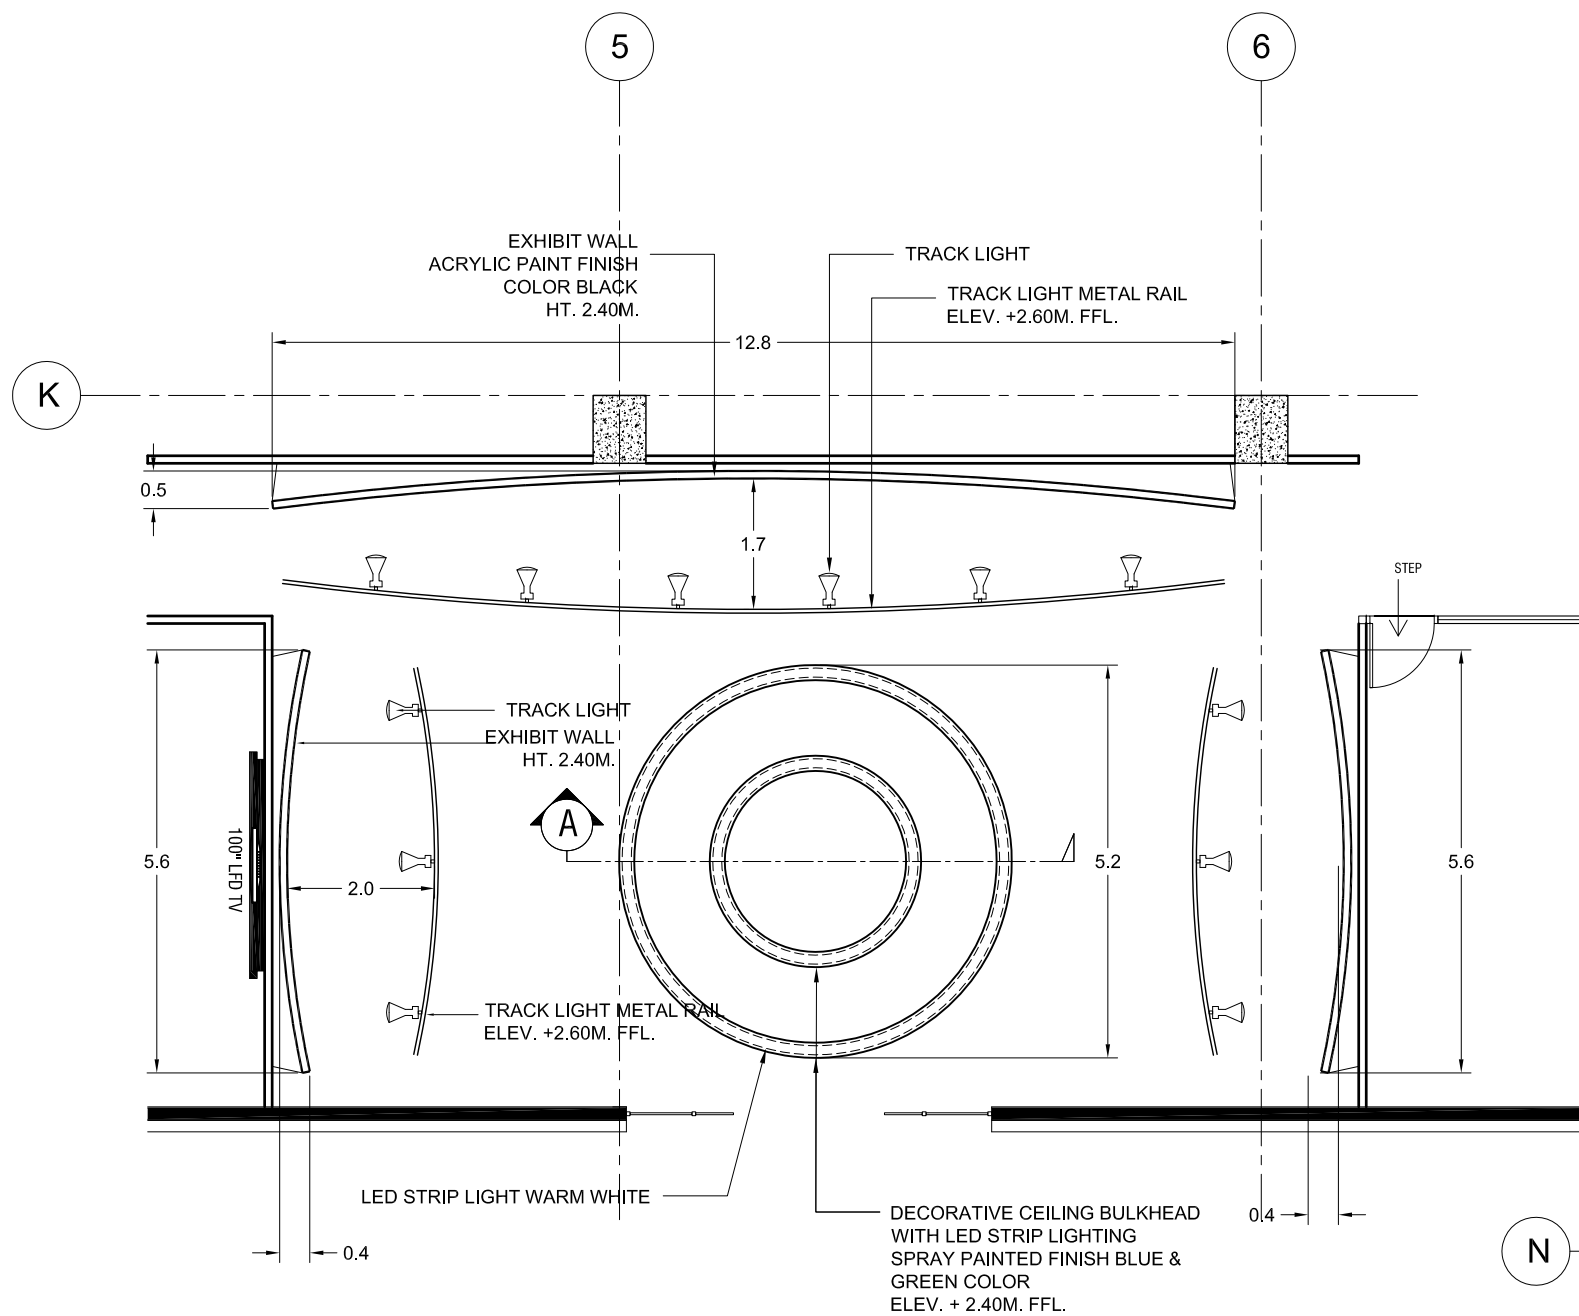

A17
1
SCALE 1:100M
INTERACTIVE EXHIBIT AREA DECORATIVE CEILING

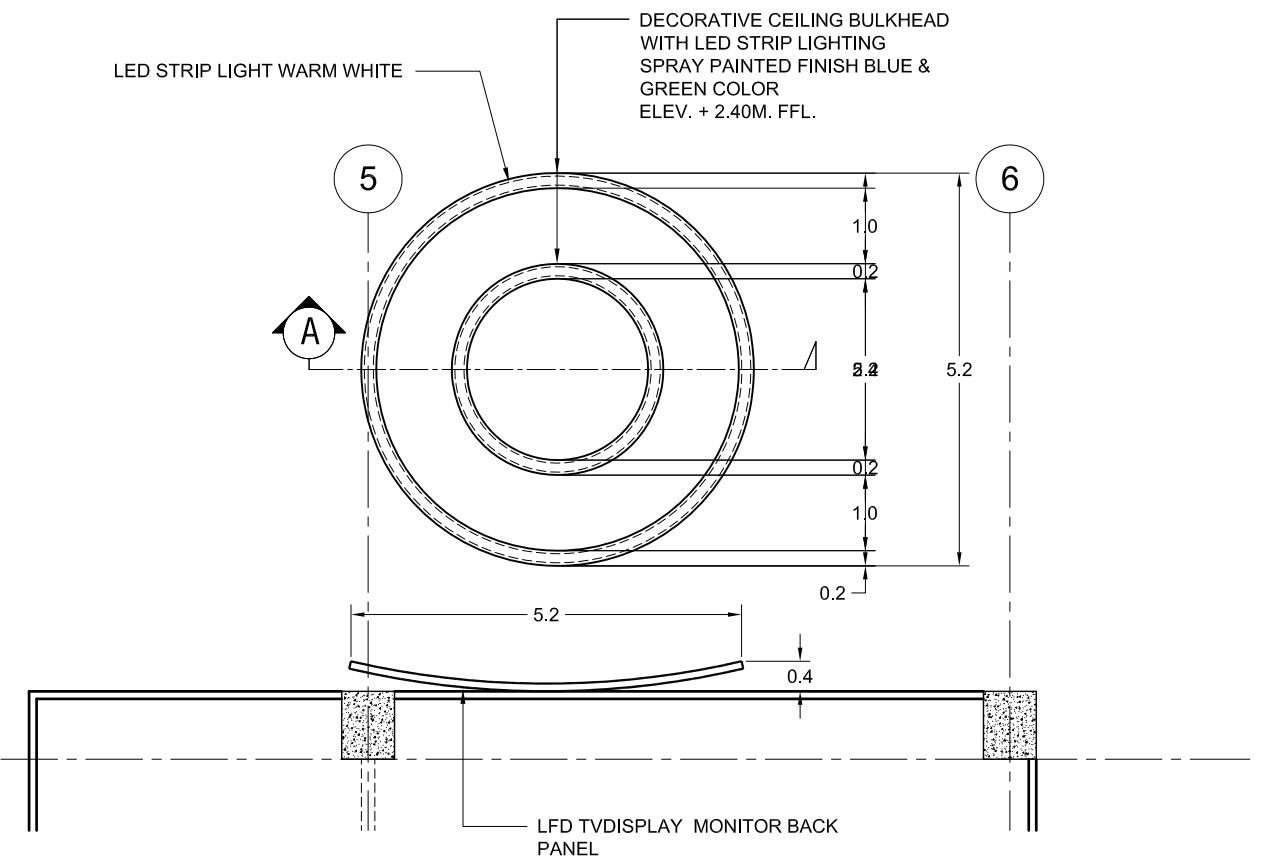


A17
2
SCALE 1:100M
RECEPTION AREA DECORATIVE CEILING

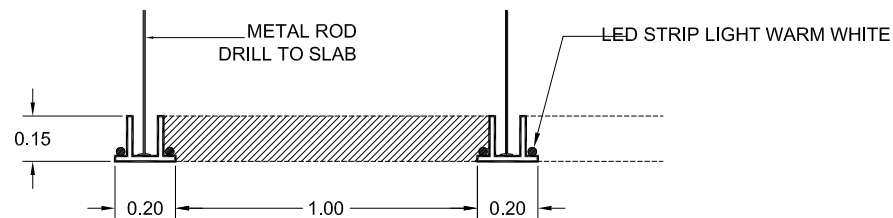

A17
3
SCALE 1:100M
SECTION A-A

BIDDERS AUTHORIZED REPRESENTATIVES

Signature Over Printed Name

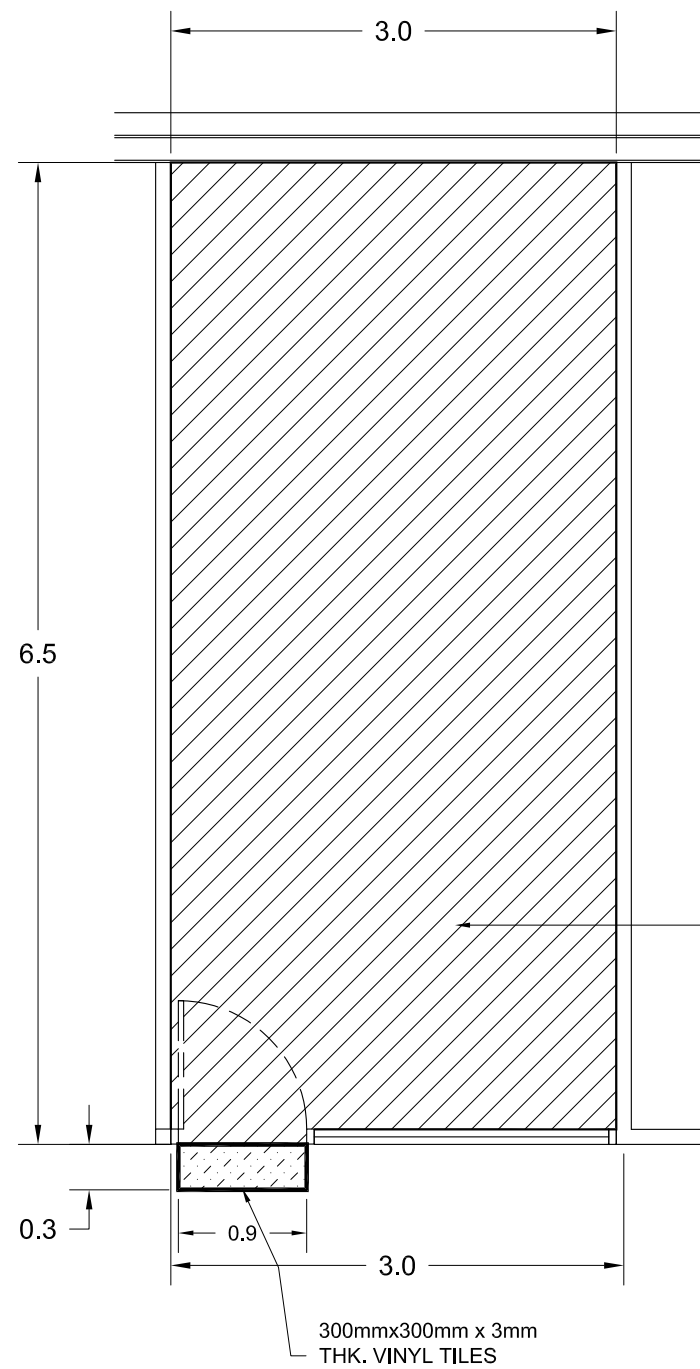

50mm x 150mm x3mm THK. TUBULAR FRAME WELDED

300mm x 300mm x 3mm THK. VINYL TILES ON 19mm THK. PLYBOARD


600mmx600mm x 7.5mm THK. CARPET TILES

300mmx300mm x 3mm THK. VINYL TILES

A-18
02

RAISED FLOOR (SERVER ROOM)
FLOOR FINISH DESIGN

SCALE 1:50M

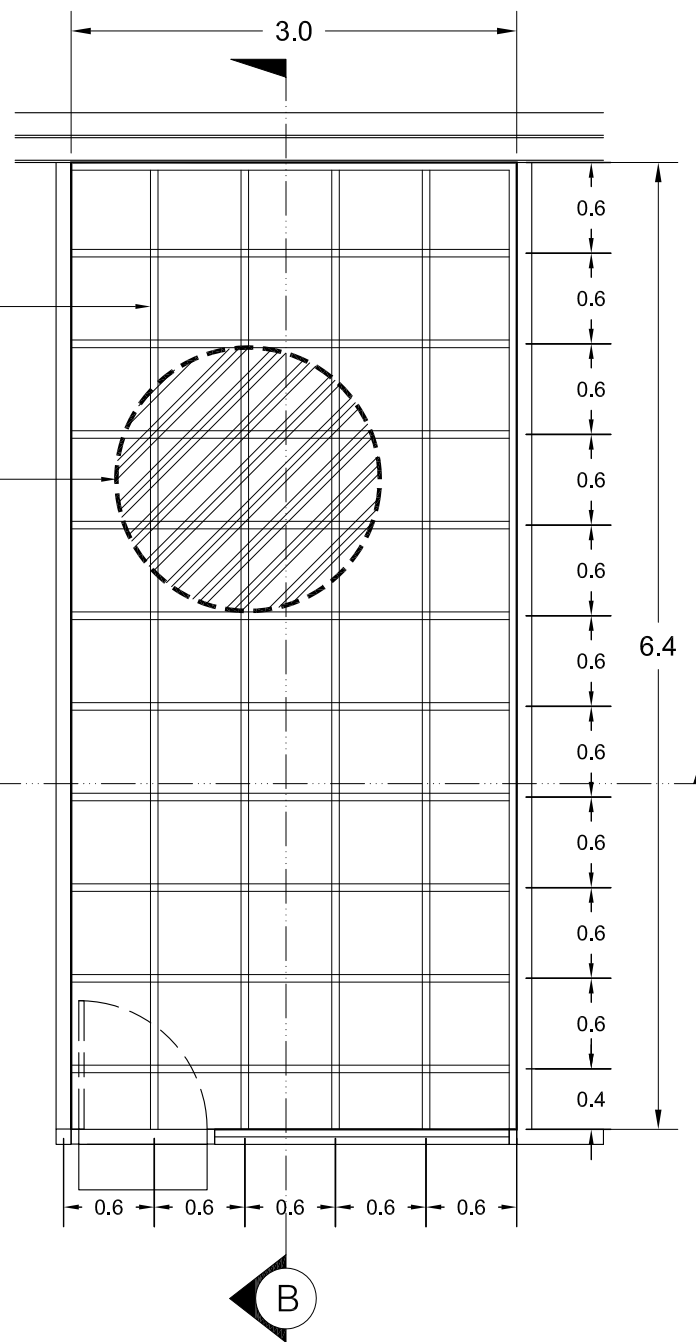

A-18
02

RAISED FLOOR (SERVER ROOM)
FLOOR FINISH DESIGN

SCALE 1:50M

50mm x 150mm x3mm THK. TUBULAR FRAME WELDED

19mm THK. PLYBOARD

600mmx600mm x 7.5mm THK. CARPET TILES

19mm THK. PLYBOARD

300mmx300mm x 3mm THK. VINYL TILES

50mm WIDE ALUMINUM GRATED STAIR NOSING

10mm THK. STEEL PLATE WITH EXPANSION BOLT

600mm x 600mm x 31mm FLOOR PANELS

A-18
03

RAISED FLOOR (SERVER ROOM)
TYPICAL PLATFORM SECTION

SCALE 1:50M


BIDDERS AUTHORIZED REPRESENTATIVES

Signature Over Printed Name

NOTE : FIBER CEMENT BOARD 12MM THICK ON GALVANIZED STEEL STUDS ON 300MM HIGH CHB BASE ZOCALO AS PER FIT OUT GUIDELINES.

NOTE : GYPSUM WALL BOARD 16MM THICK TYPE X WITH INSULATION (1 HOUR RATING)

NOTE : FIBER CEMENT BOARD 12MM THICK ON GALVANIZED STEEL STUDS ON 300MM HIGH CHB BASE ZOCALO AS PER FIT OUT GUIDELINES.

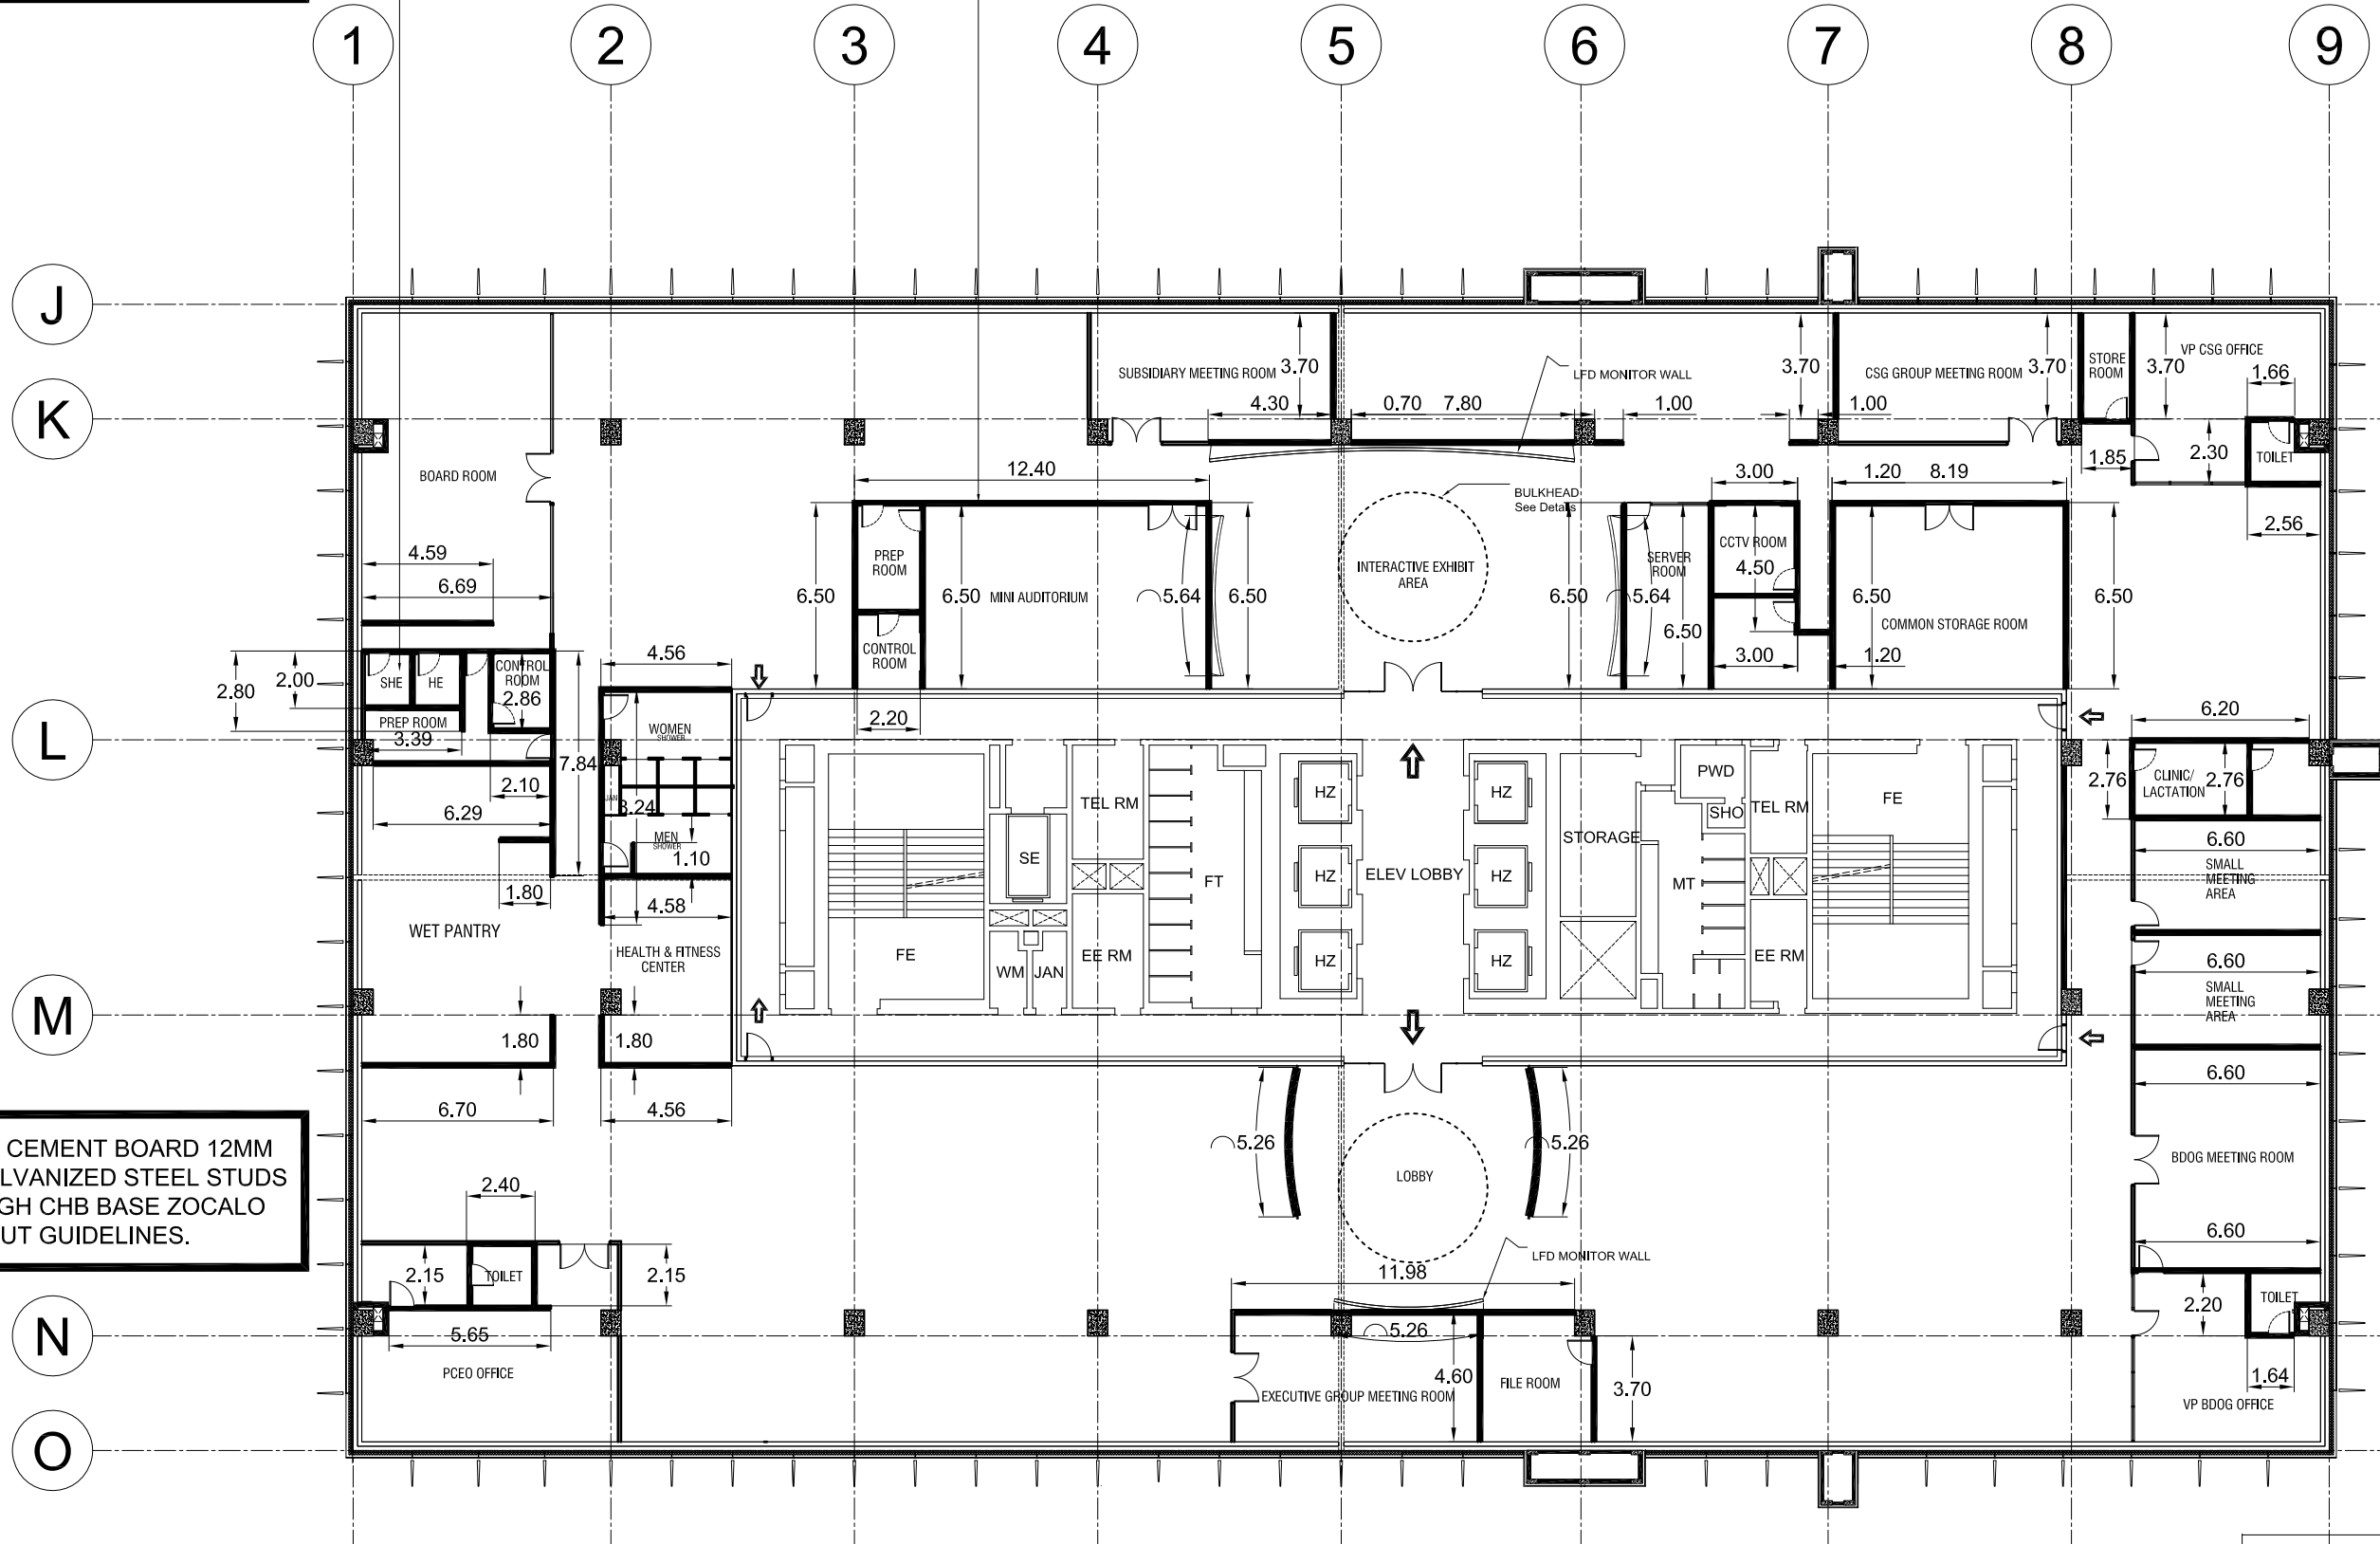

HIGH WALL PARTITION

BIDDERS AUTHORIZED REPRESENTATIVES

 Signature Over Printed Name



PROJECT NAME
 PROPOSED BCDA OFFICE
 CLARK FREE PORT ZONE , PAMPANGA

PREPARED BY
 JUDENE G. LAGOY
 NCC PMO

CHECKED & REVIEWED BY
 REINO STEPHEN A. AYO
 OIC GSD


RECOMMENDING APPROVAL
 BGEN CARLOS F. QUITA (RET.)
 VP CSG

APPROVED BY
 VIVENCIO B. DIZON
 PRESIDENT AND CEO

SHEET CONTENT
 HIGH WALL PARTITION
 SCALE 1 : 250 M. DATE : 03-07-2018

SHEET NO.
 A
 02

NOTE : 12MM THICK CLEAR TEMPERED FRAMELESS AS PER FIT OUT GUIDELINES.

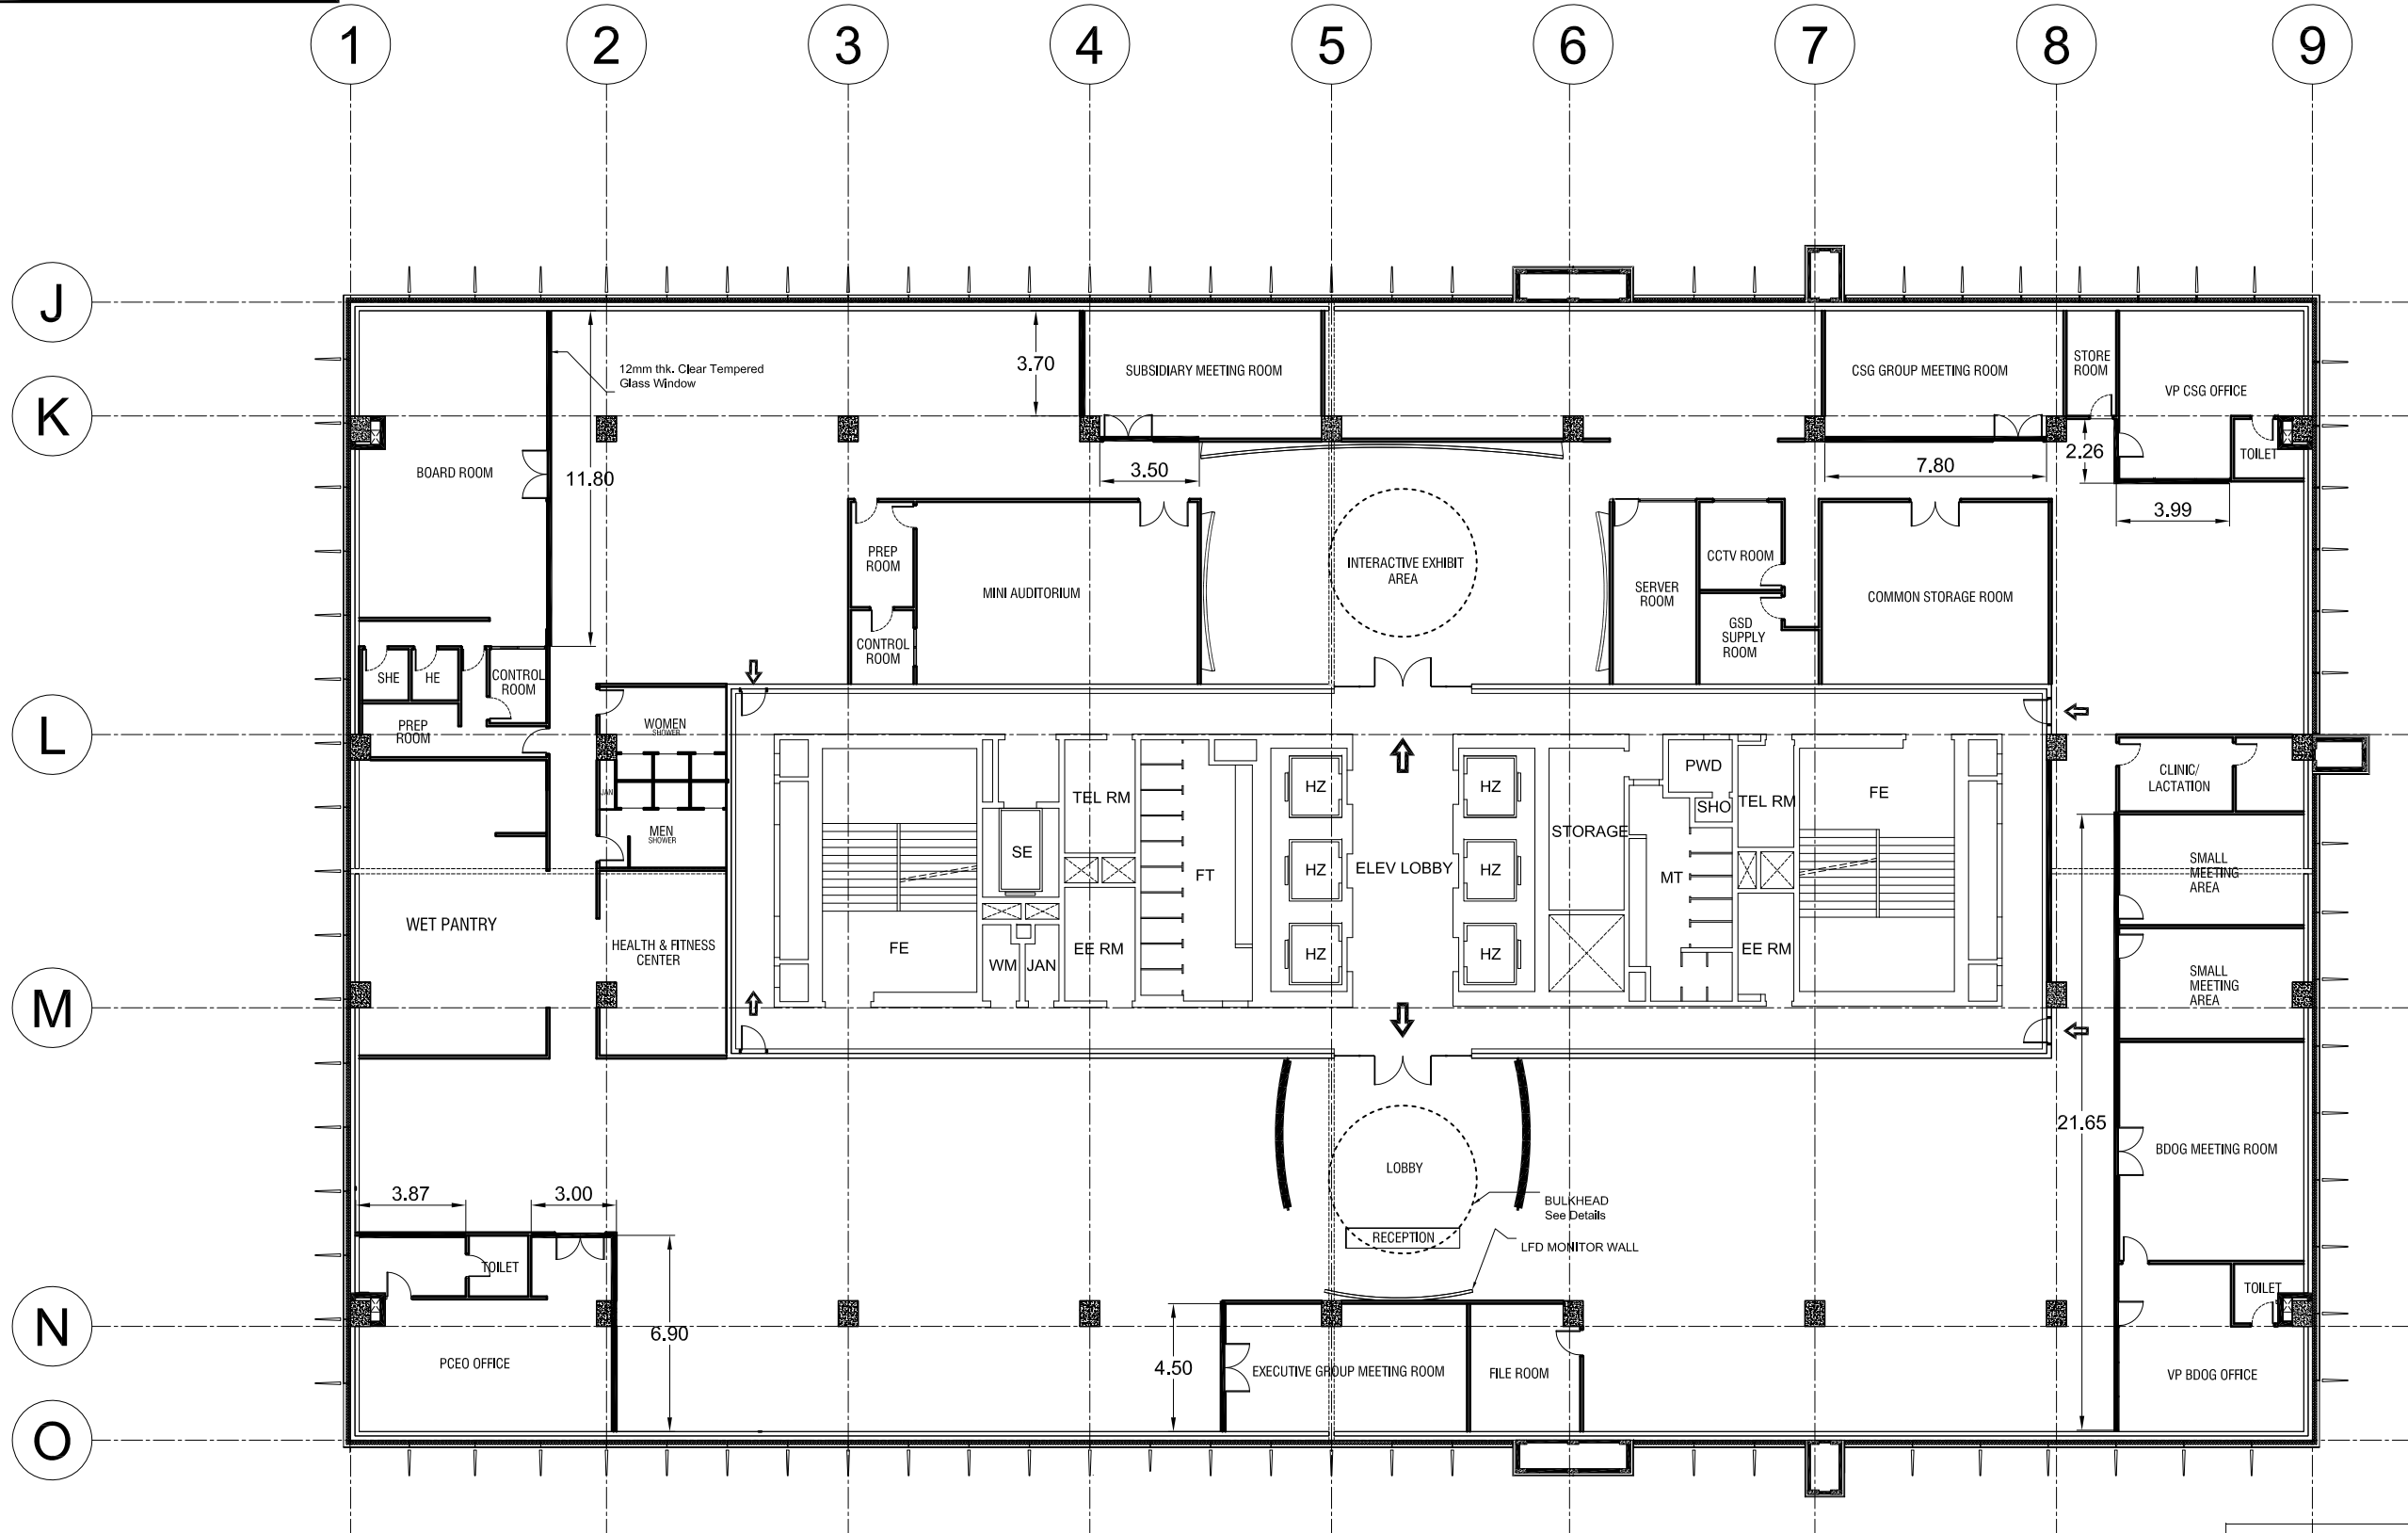

GLASS WALL PARTITION

BIDDERS AUTHORIZED REPRESENTATIVES

 Signature Over Printed Name



PROJECT NAME
 PROPOSED BCDA OFFICE
 CLARK FREE PORT ZONE, PAMPANGA

PREPARED BY
 JUDENE G. LAGOY
 NCC PMO


CHECKED & REVIEWED BY
 REINO STEPHEN A. AYO
 OIC GSD

RECOMMENDING APPROVAL
 BGEN CARLOS F. QUITA (RET.)
 VP CSG

APPROVED BY
 VIVENCIO B. DIZON
 PRESIDENT AND CEO

SHEET CONTENT
 GLASS WALL PARTITION
 SCALE 1 : 250 M. DATE : 03-07-2018

SHEET NO.
 A
 03

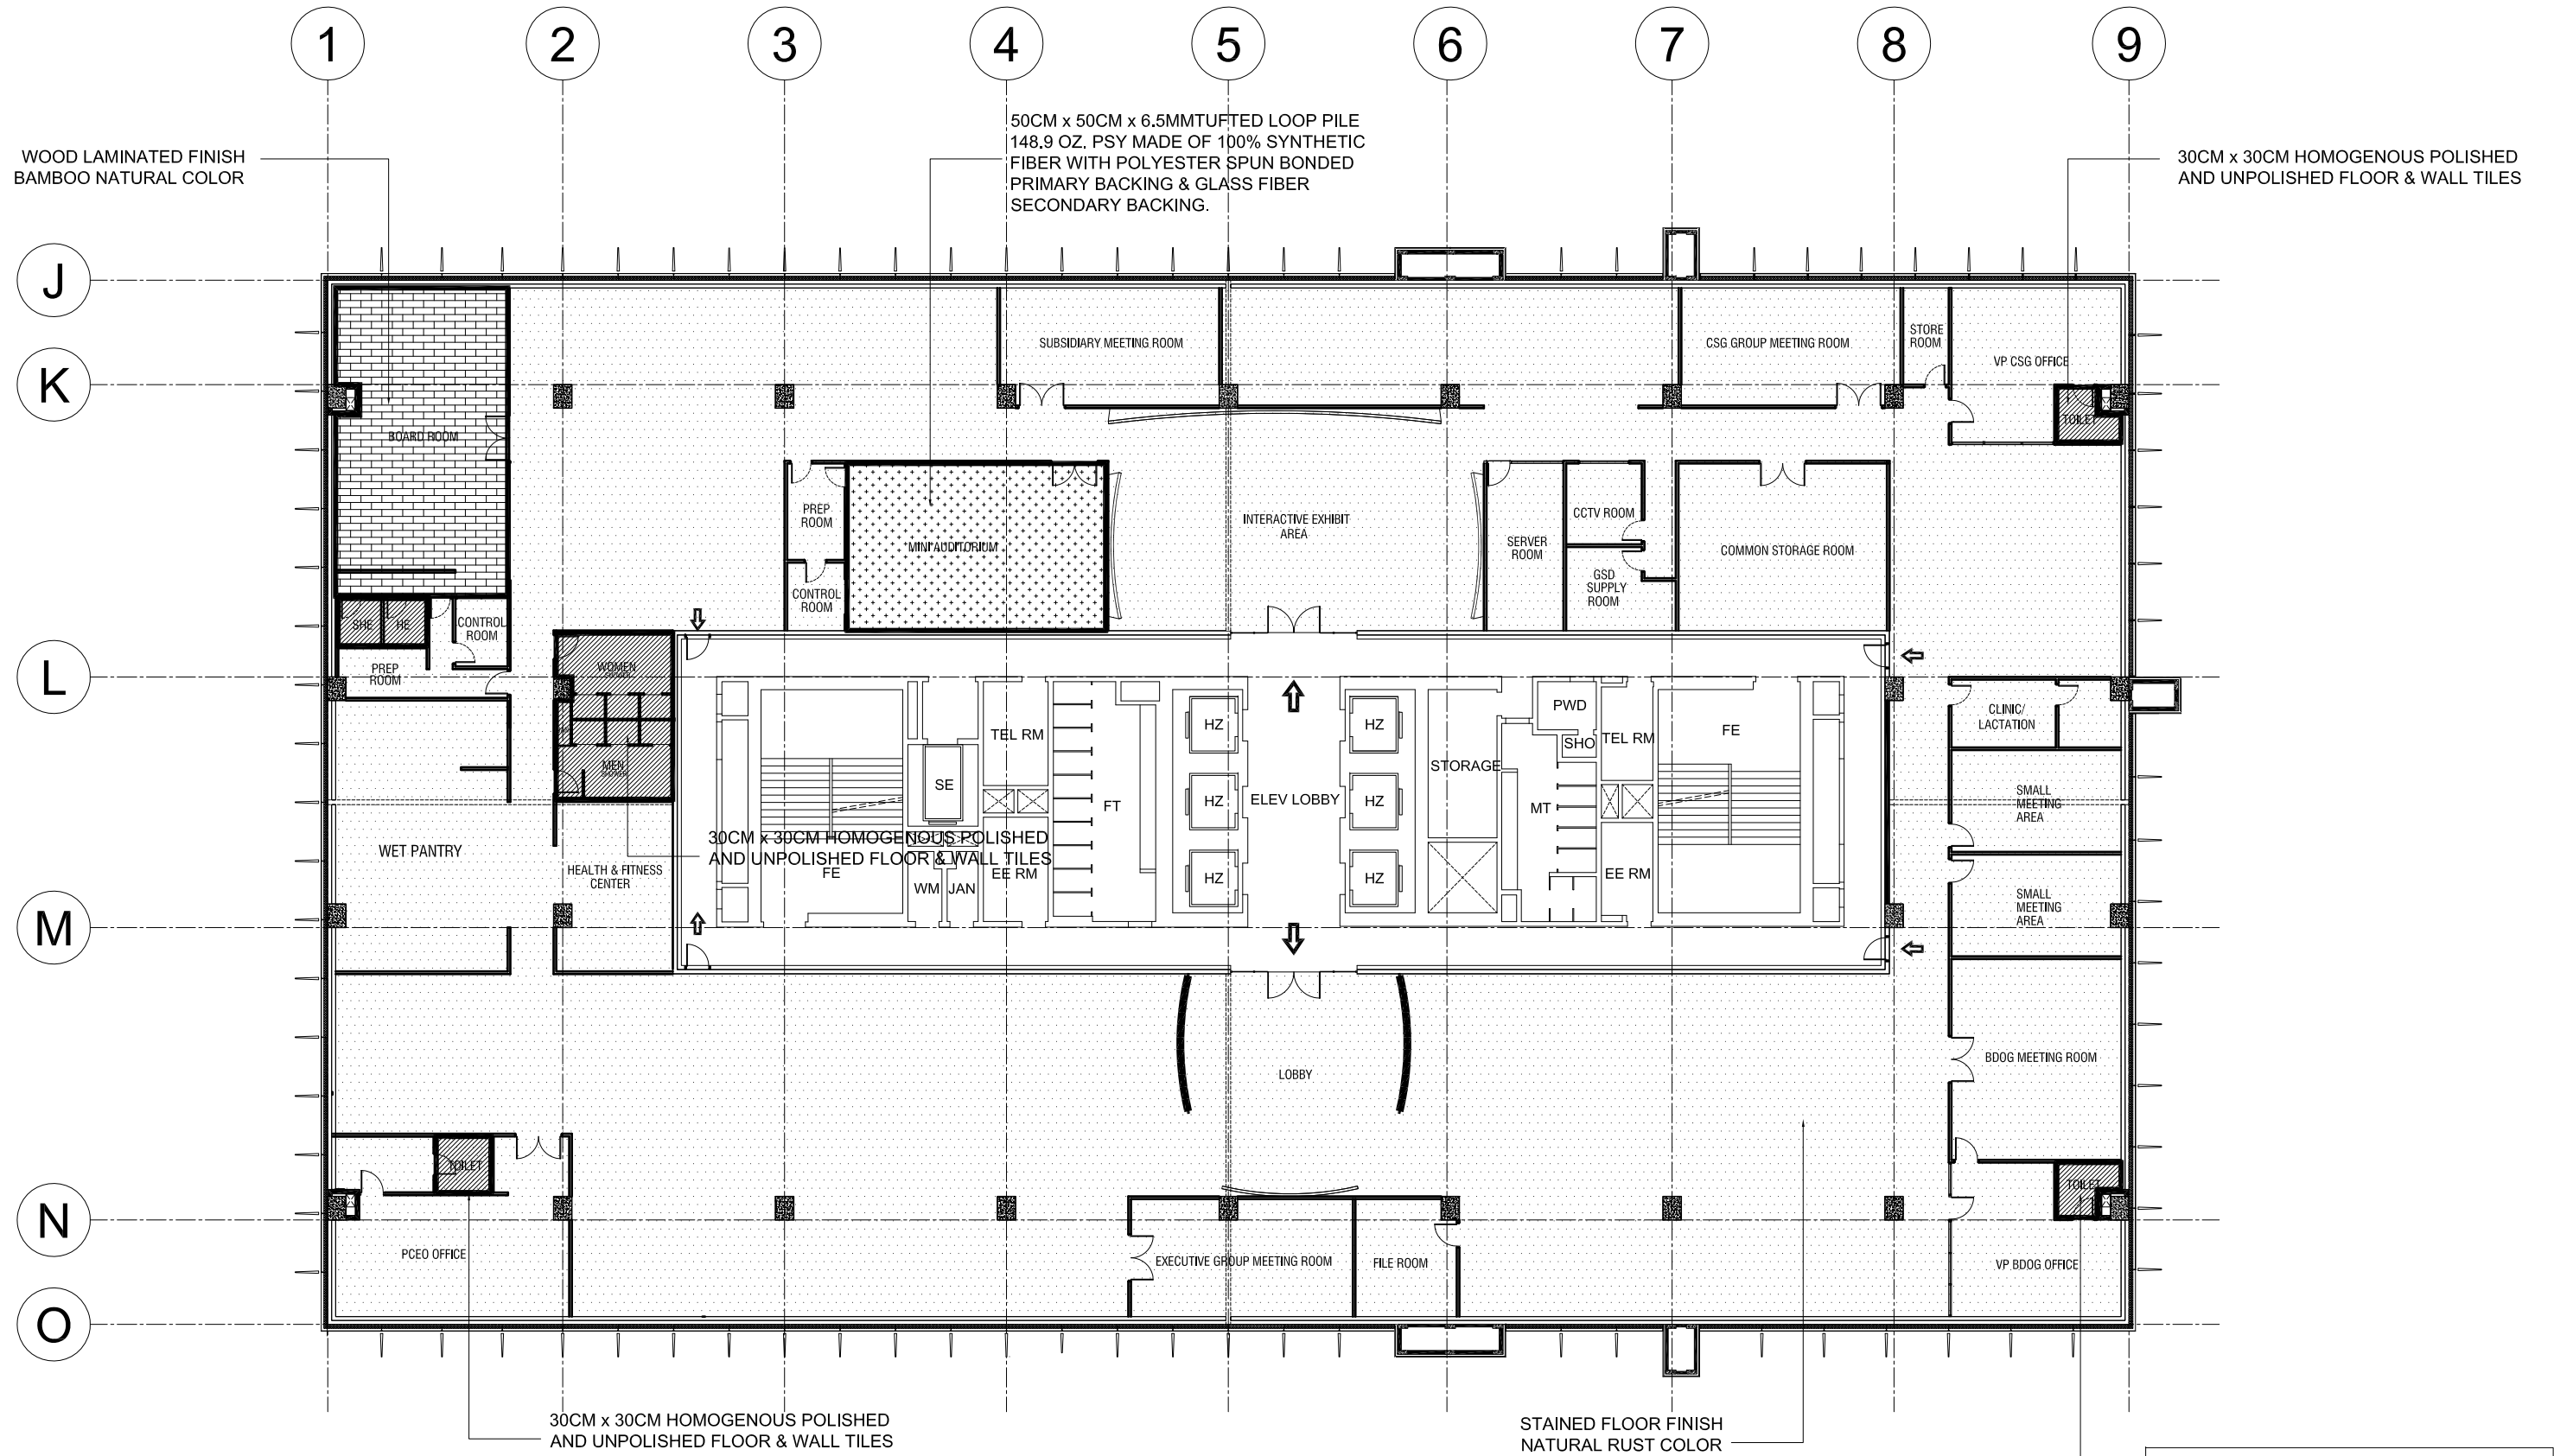

FLOOR FINISHES PLAN

BIDDERS AUTHORIZED REPRESENTATIVES

Signature Over Printed Name



PROJECT NAME	PROPOSED BCDA OFFICE CLARK FREE PORT ZONE, PAMPANGA
--------------	--

PREPARED BY	JUDENE G. LAGOY NCC PMO
-------------	----------------------------

CHECKED & REVIEWED BY	REINO STEPHEN A. AYO OIC GSD
-----------------------	---------------------------------


RECOMMENDING APPROVAL	BGEN CARLOS F. QUITA (RET.) VP CSG
-----------------------	---------------------------------------

APPROVED BY	VIVENCIO B. DIZON PRESIDENT AND CEO
-------------	--


SHEET CONTENT	FLOOR FINISHES PLAN
SCALE	1 : 250 M.
DATE	: 03-07-2018

SHEET NO.	A
	04


NOTE : PROVIDE ACOUSTIC INSULATION FOR MINI AUDITORIUM WALL.

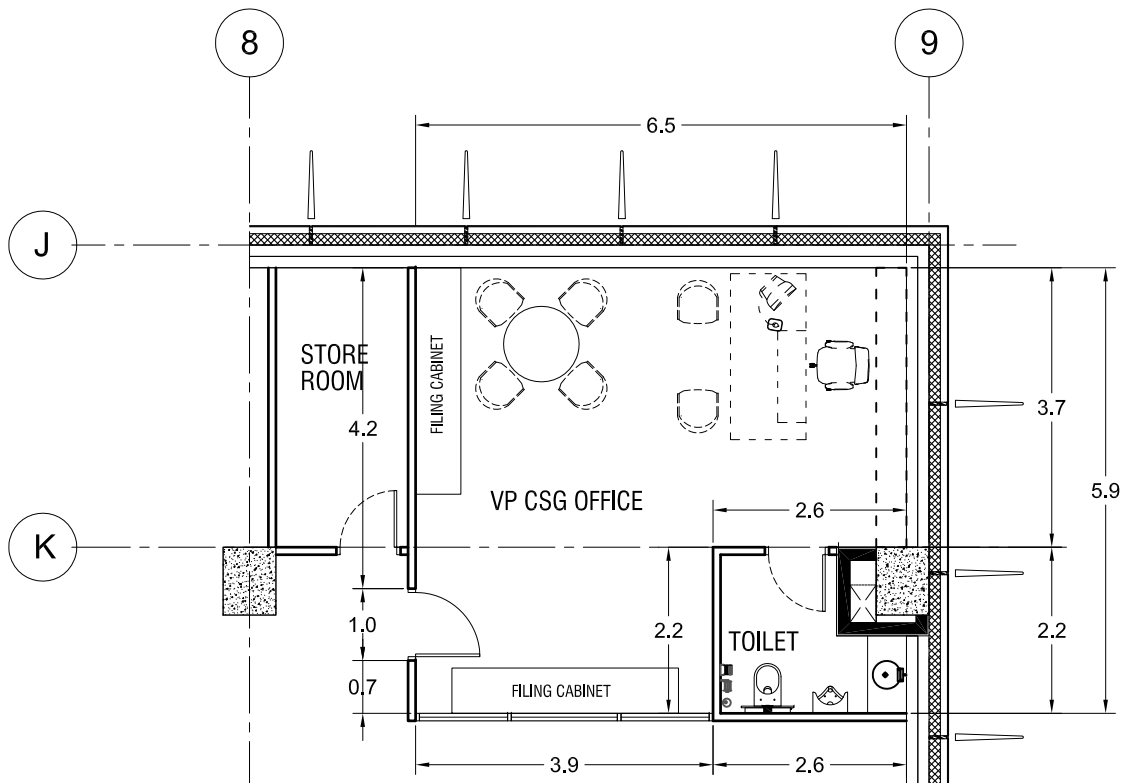


A-05
02 **CSG OFFICE**
SCALE 1:100M

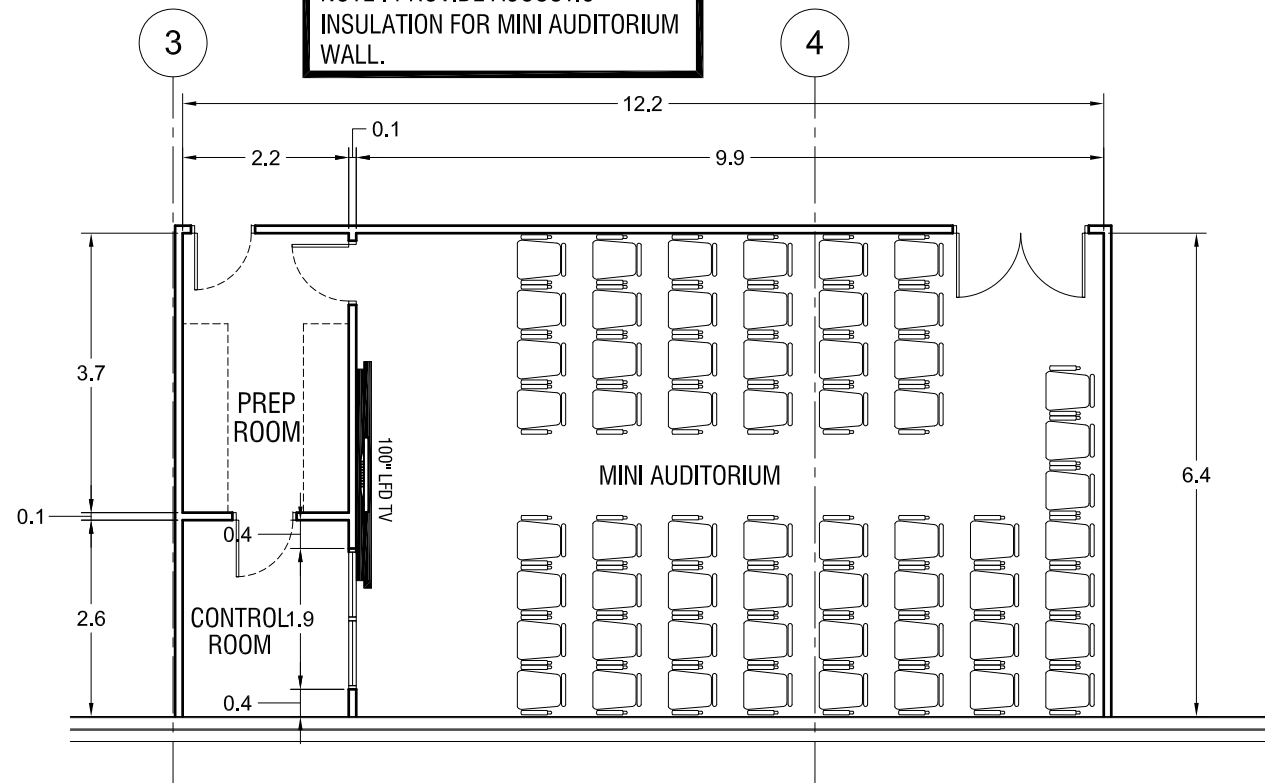

A-05
02 **CONFERENCE ROOM**
SCALE 1:100M

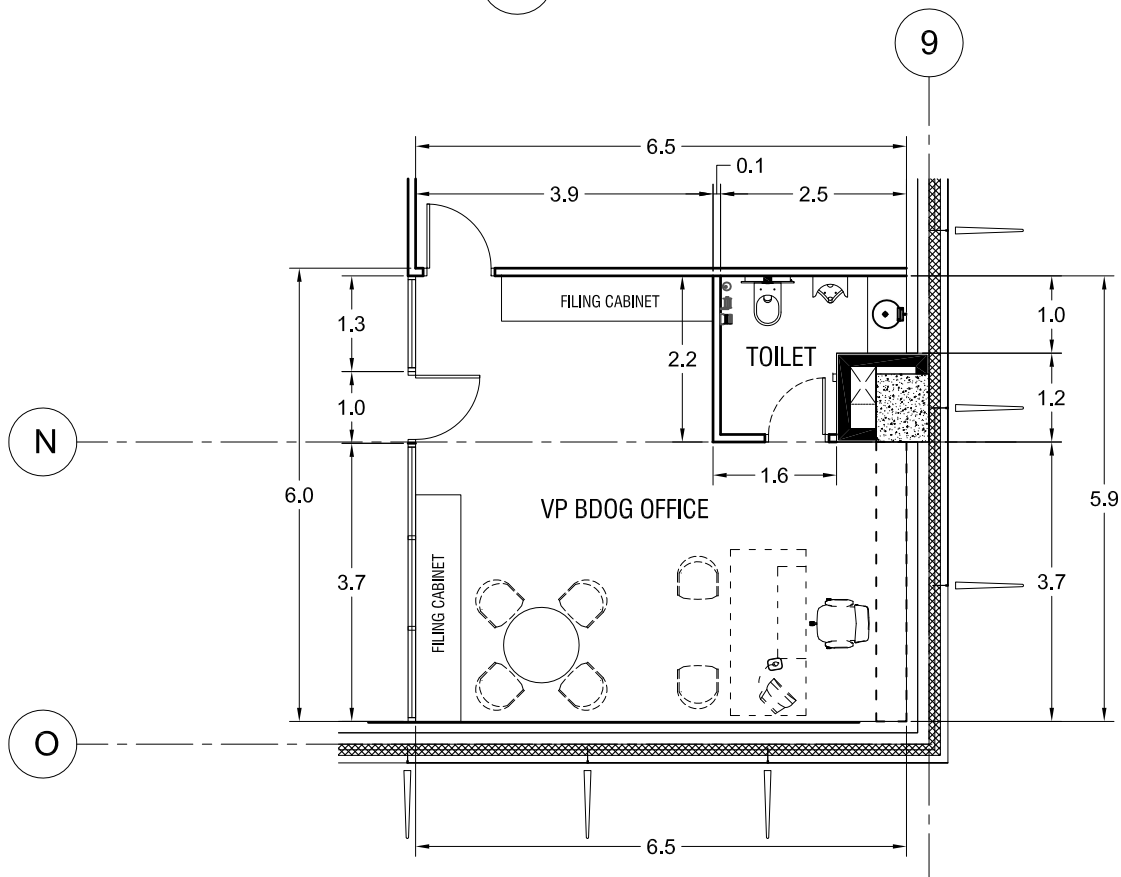






A-05
02 **BDOG OFFICE**
SCALE 1:100M

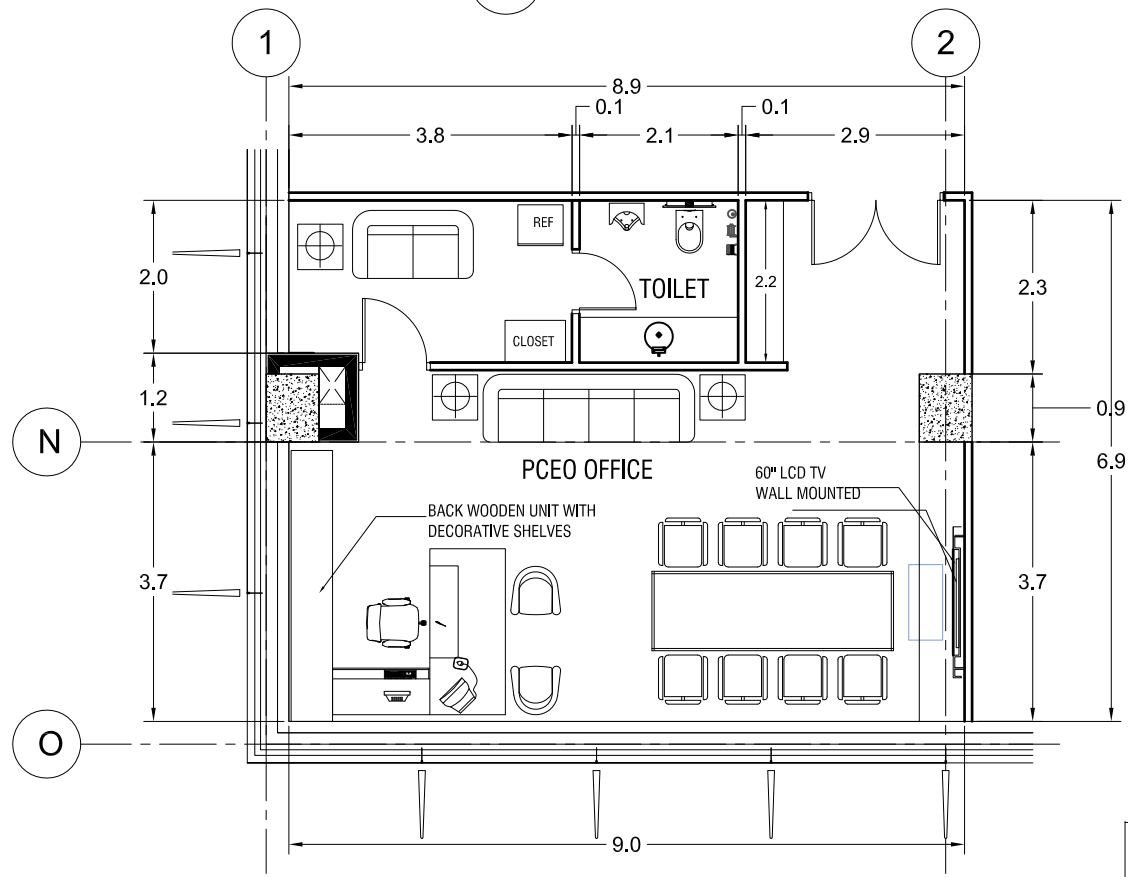

A-05
02 **PCEO OFFICE**
SCALE 1:100M

BIDDERS AUTHORIZED REPRESENTATIVES

Signature Over Printed Name

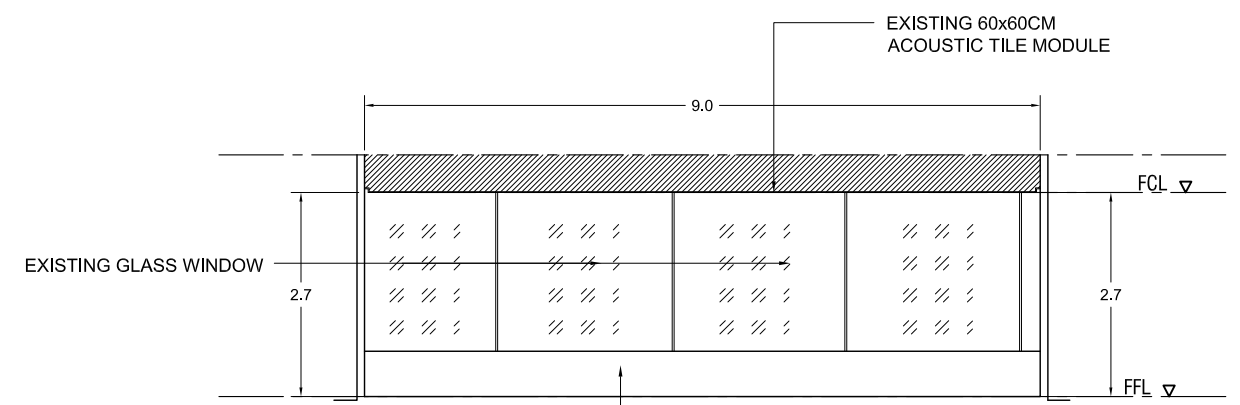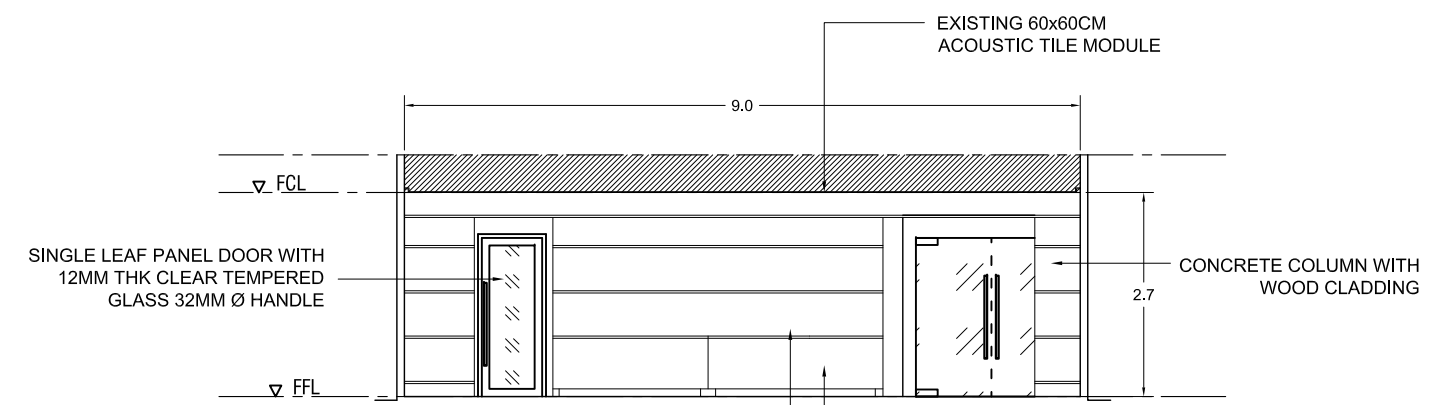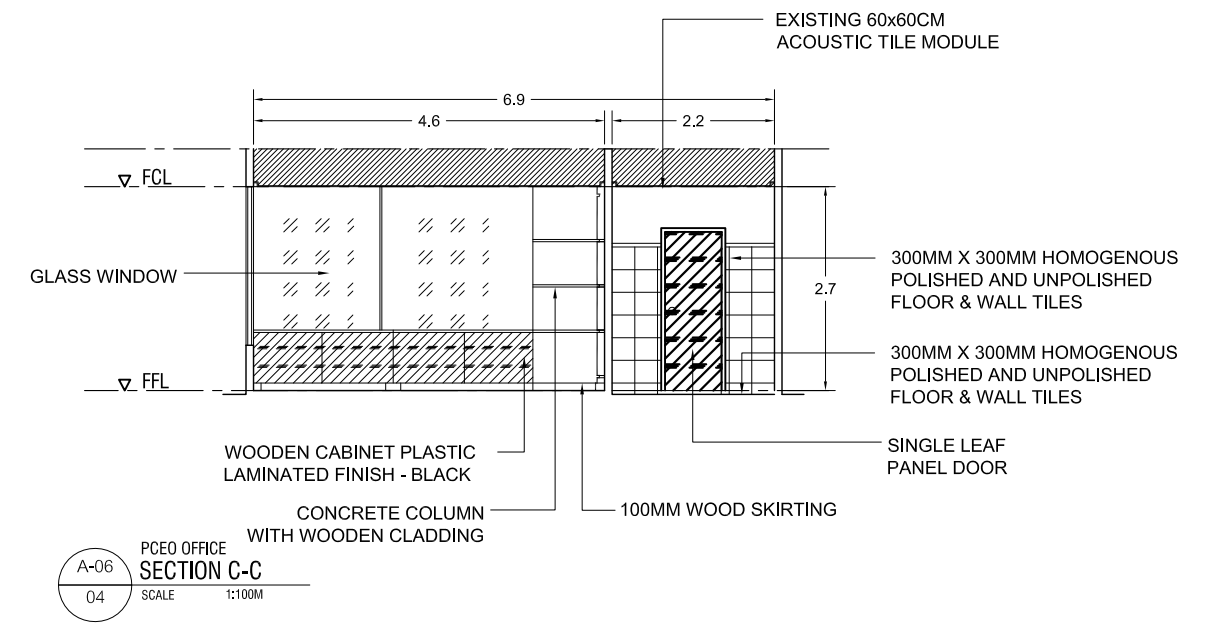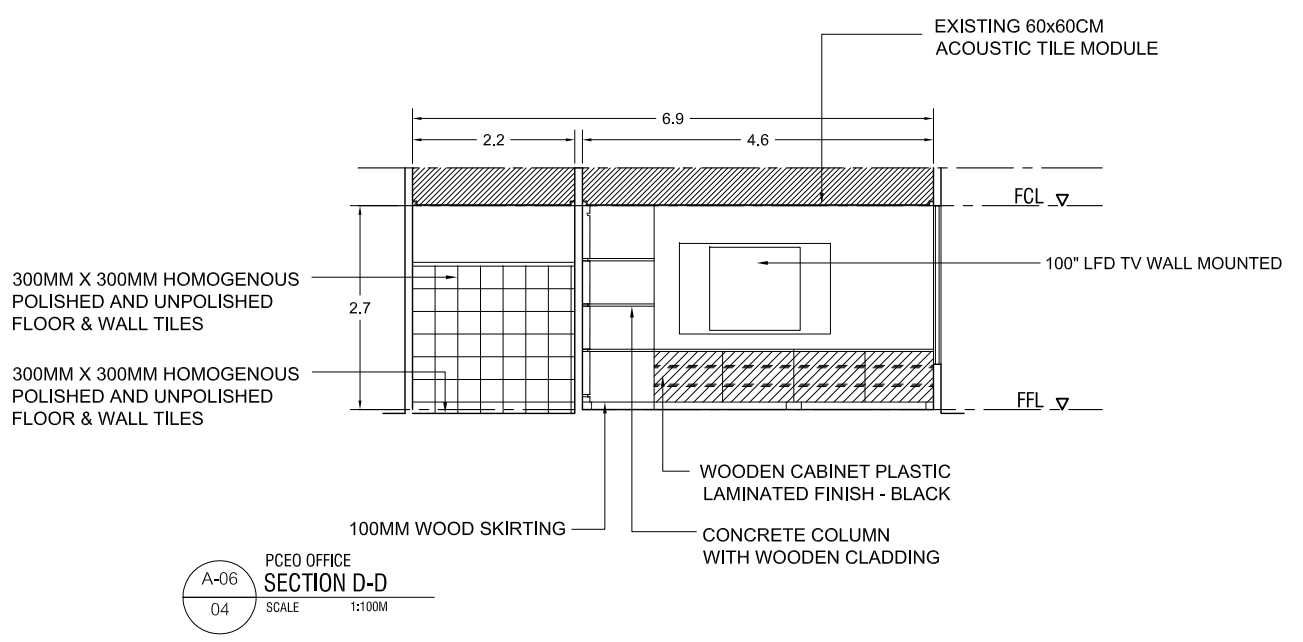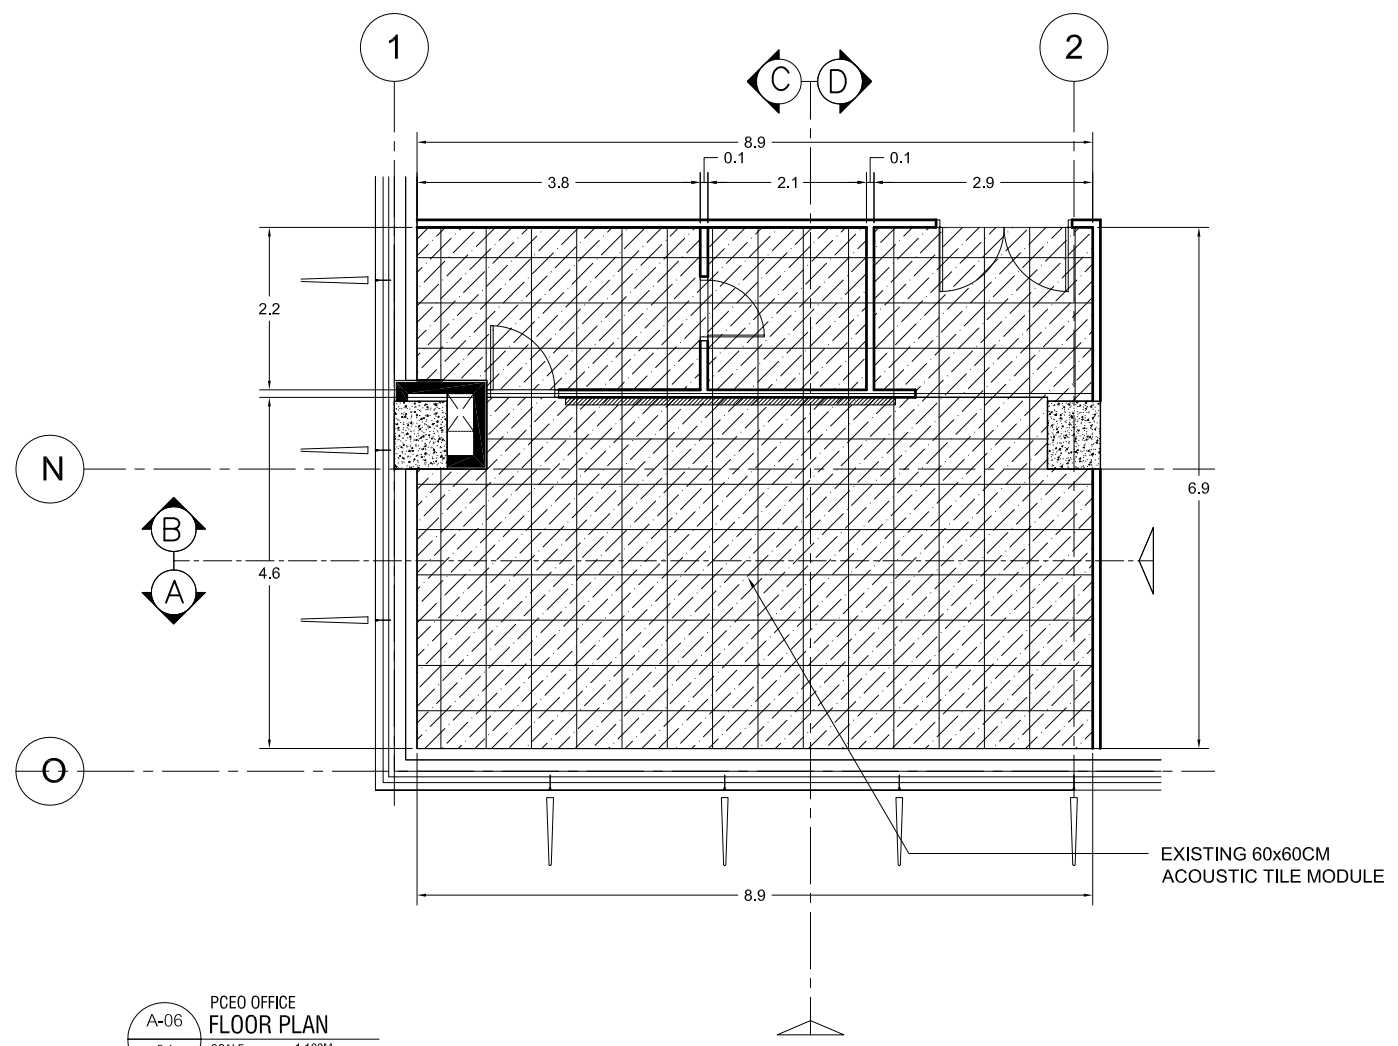


BIDDERS AUTHORIZED REPRESENTATIVES


Signature Over Printed Name



PROJECT NAME	PREPARED BY	CHECKED & REVIEWED BY	RECOMMENDING APPROVAL	APPROVED BY	SHEET CONTENT	SHEET NO.
PROPOSED BCDA OFFICE CLARK FREE PORT ZONE, PAMPANGA	JUDENE G. LAGOY NCC PMO	REINO STEPHEN AYO OIC GSD	BGEN CARLOS F. QUITA (RET.) VP CSG	VIVENCIO B. DIZON PRESIDENT AND CEO	PCEO OFFICE DETAILS SCALE 1:100 M. DATE: 03-07-2018	A 06

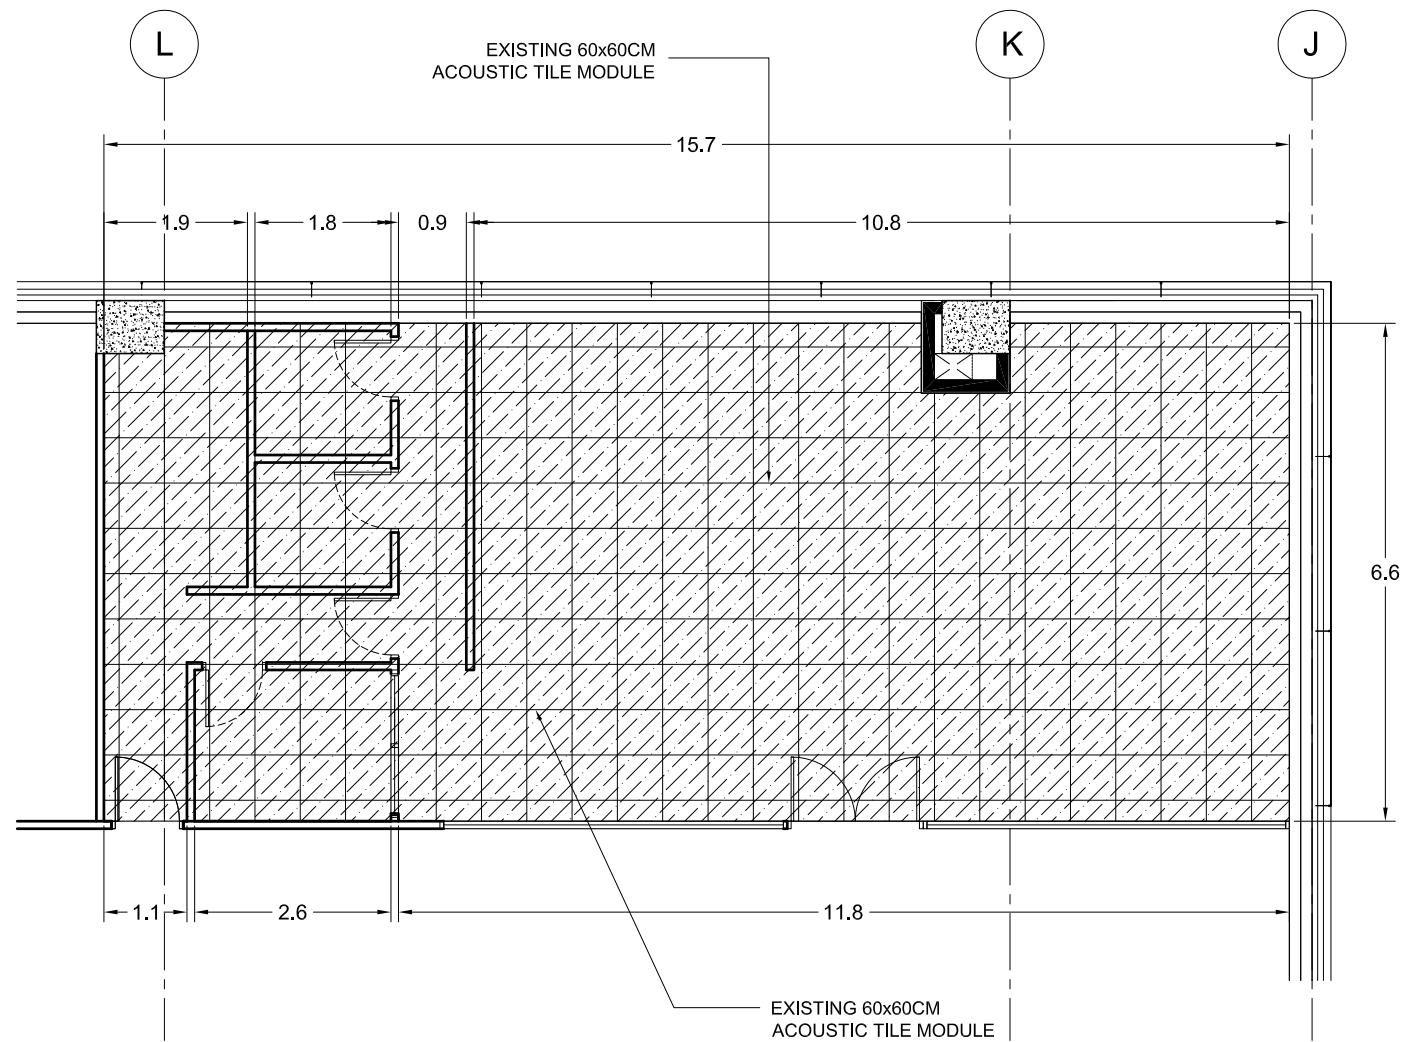


A-07
02 BOARD ROOM CEILING PLAN
SCALE 1:100M

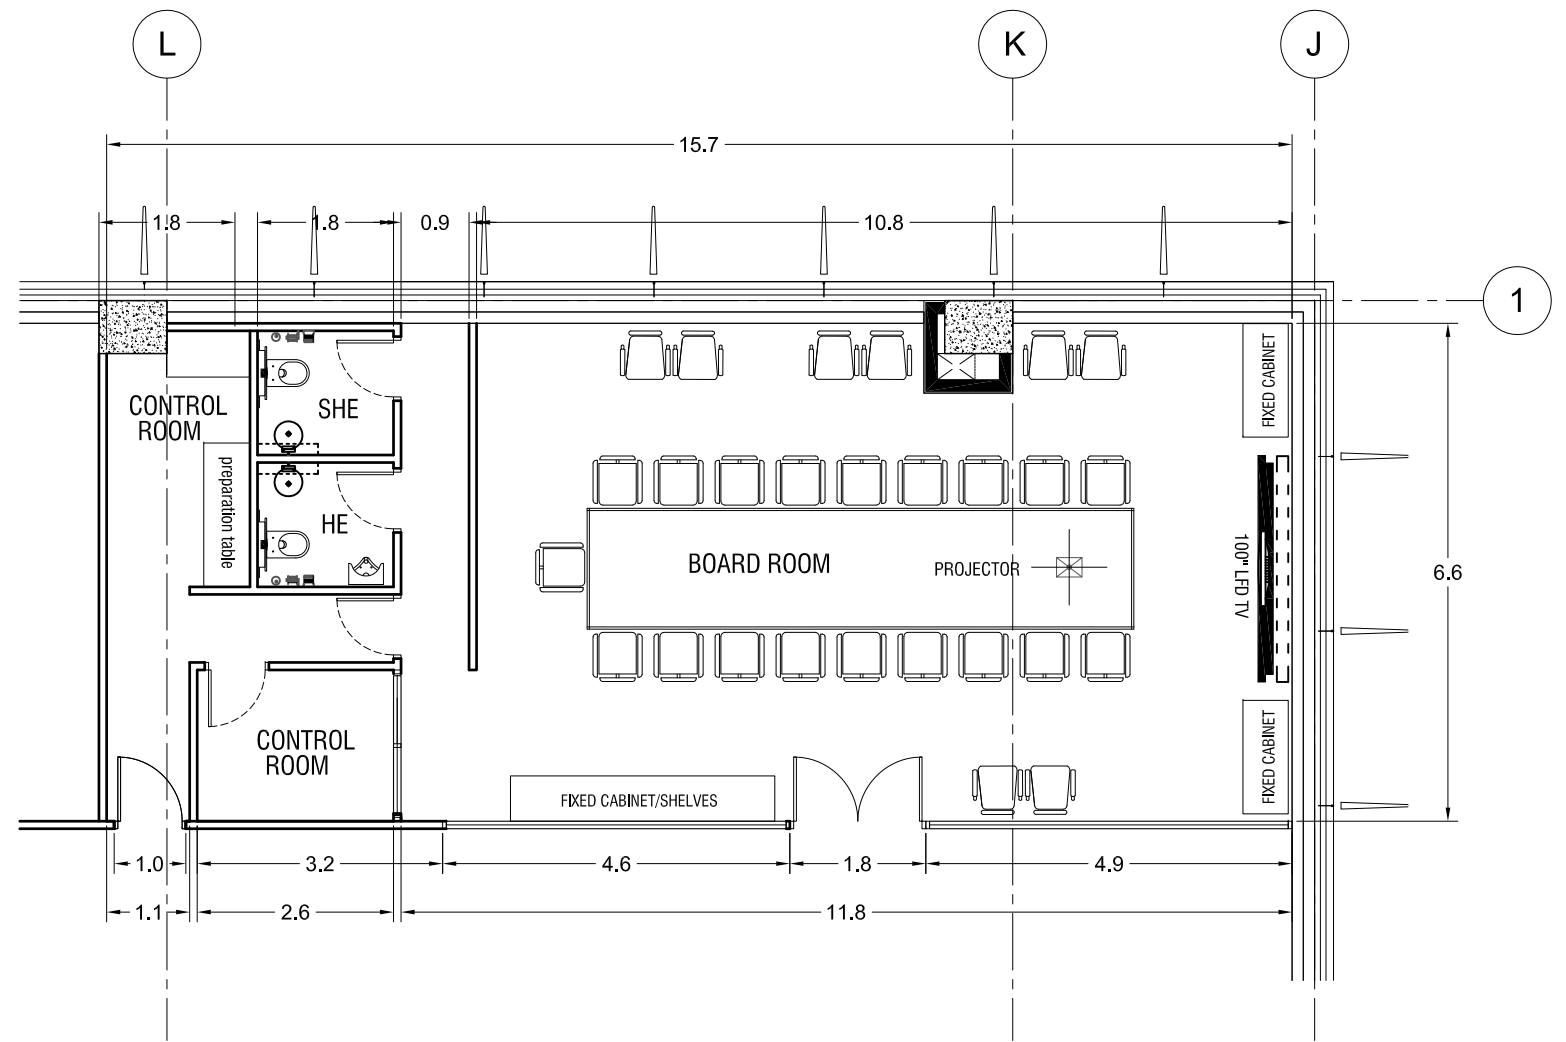


A-07
01 BOARD ROOM PLAN
SCALE 1:100M

BIDDERS AUTHORIZED REPRESENTATIVES

Signature Over Printed Name

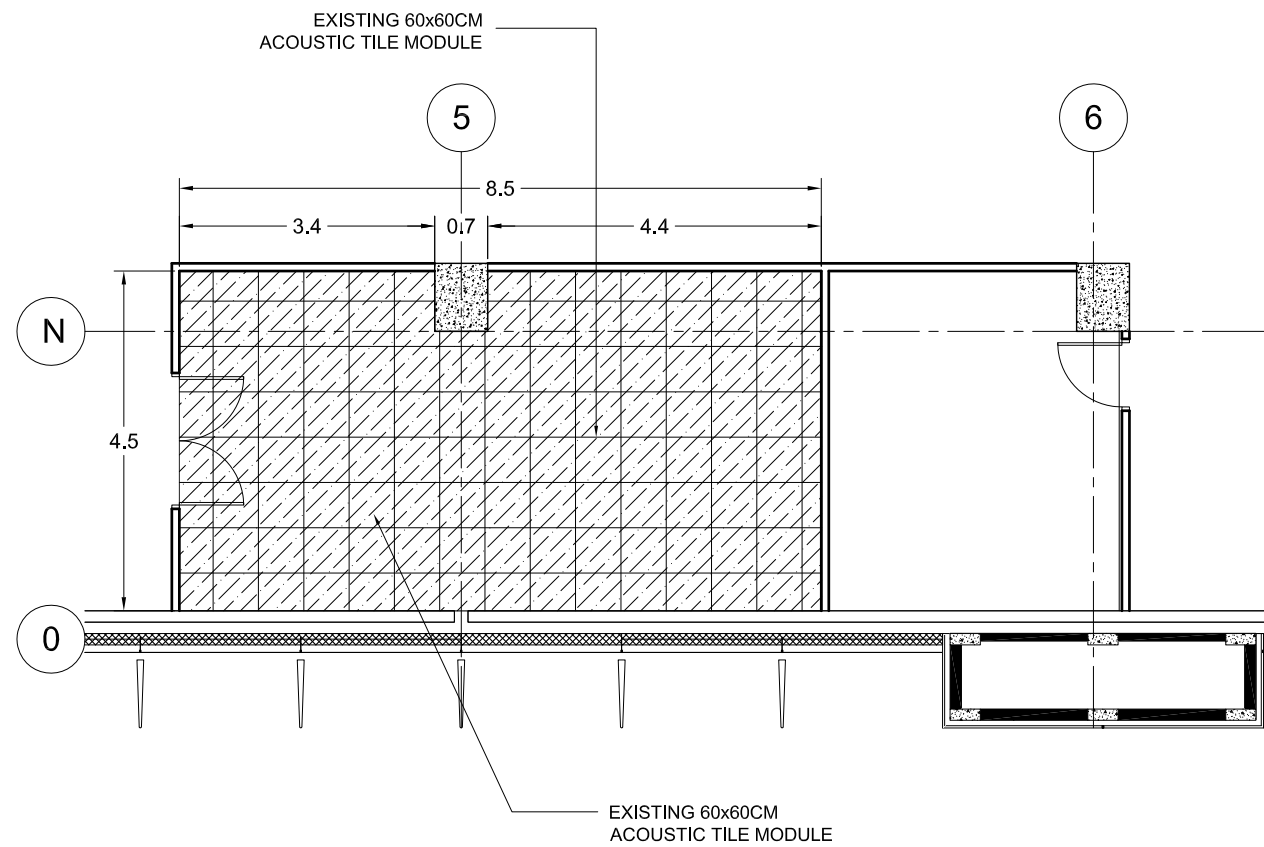


A-08
02 EXECUTIVE GROUP CEILING PLAN
SCALE 1:100M

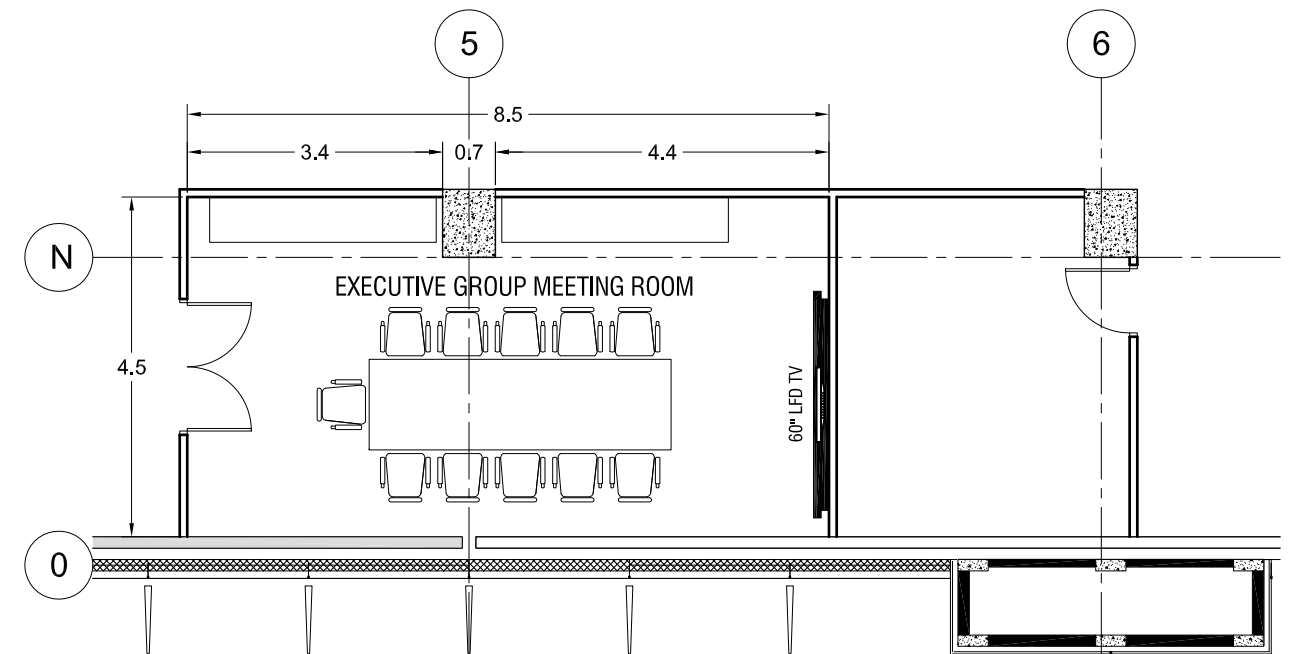

A-08
01 EXECUTIVE GROUP MEETING ROOM
SCALE 1:100M

BIDDERS AUTHORIZED REPRESENTATIVES

Signature Over Printed Name

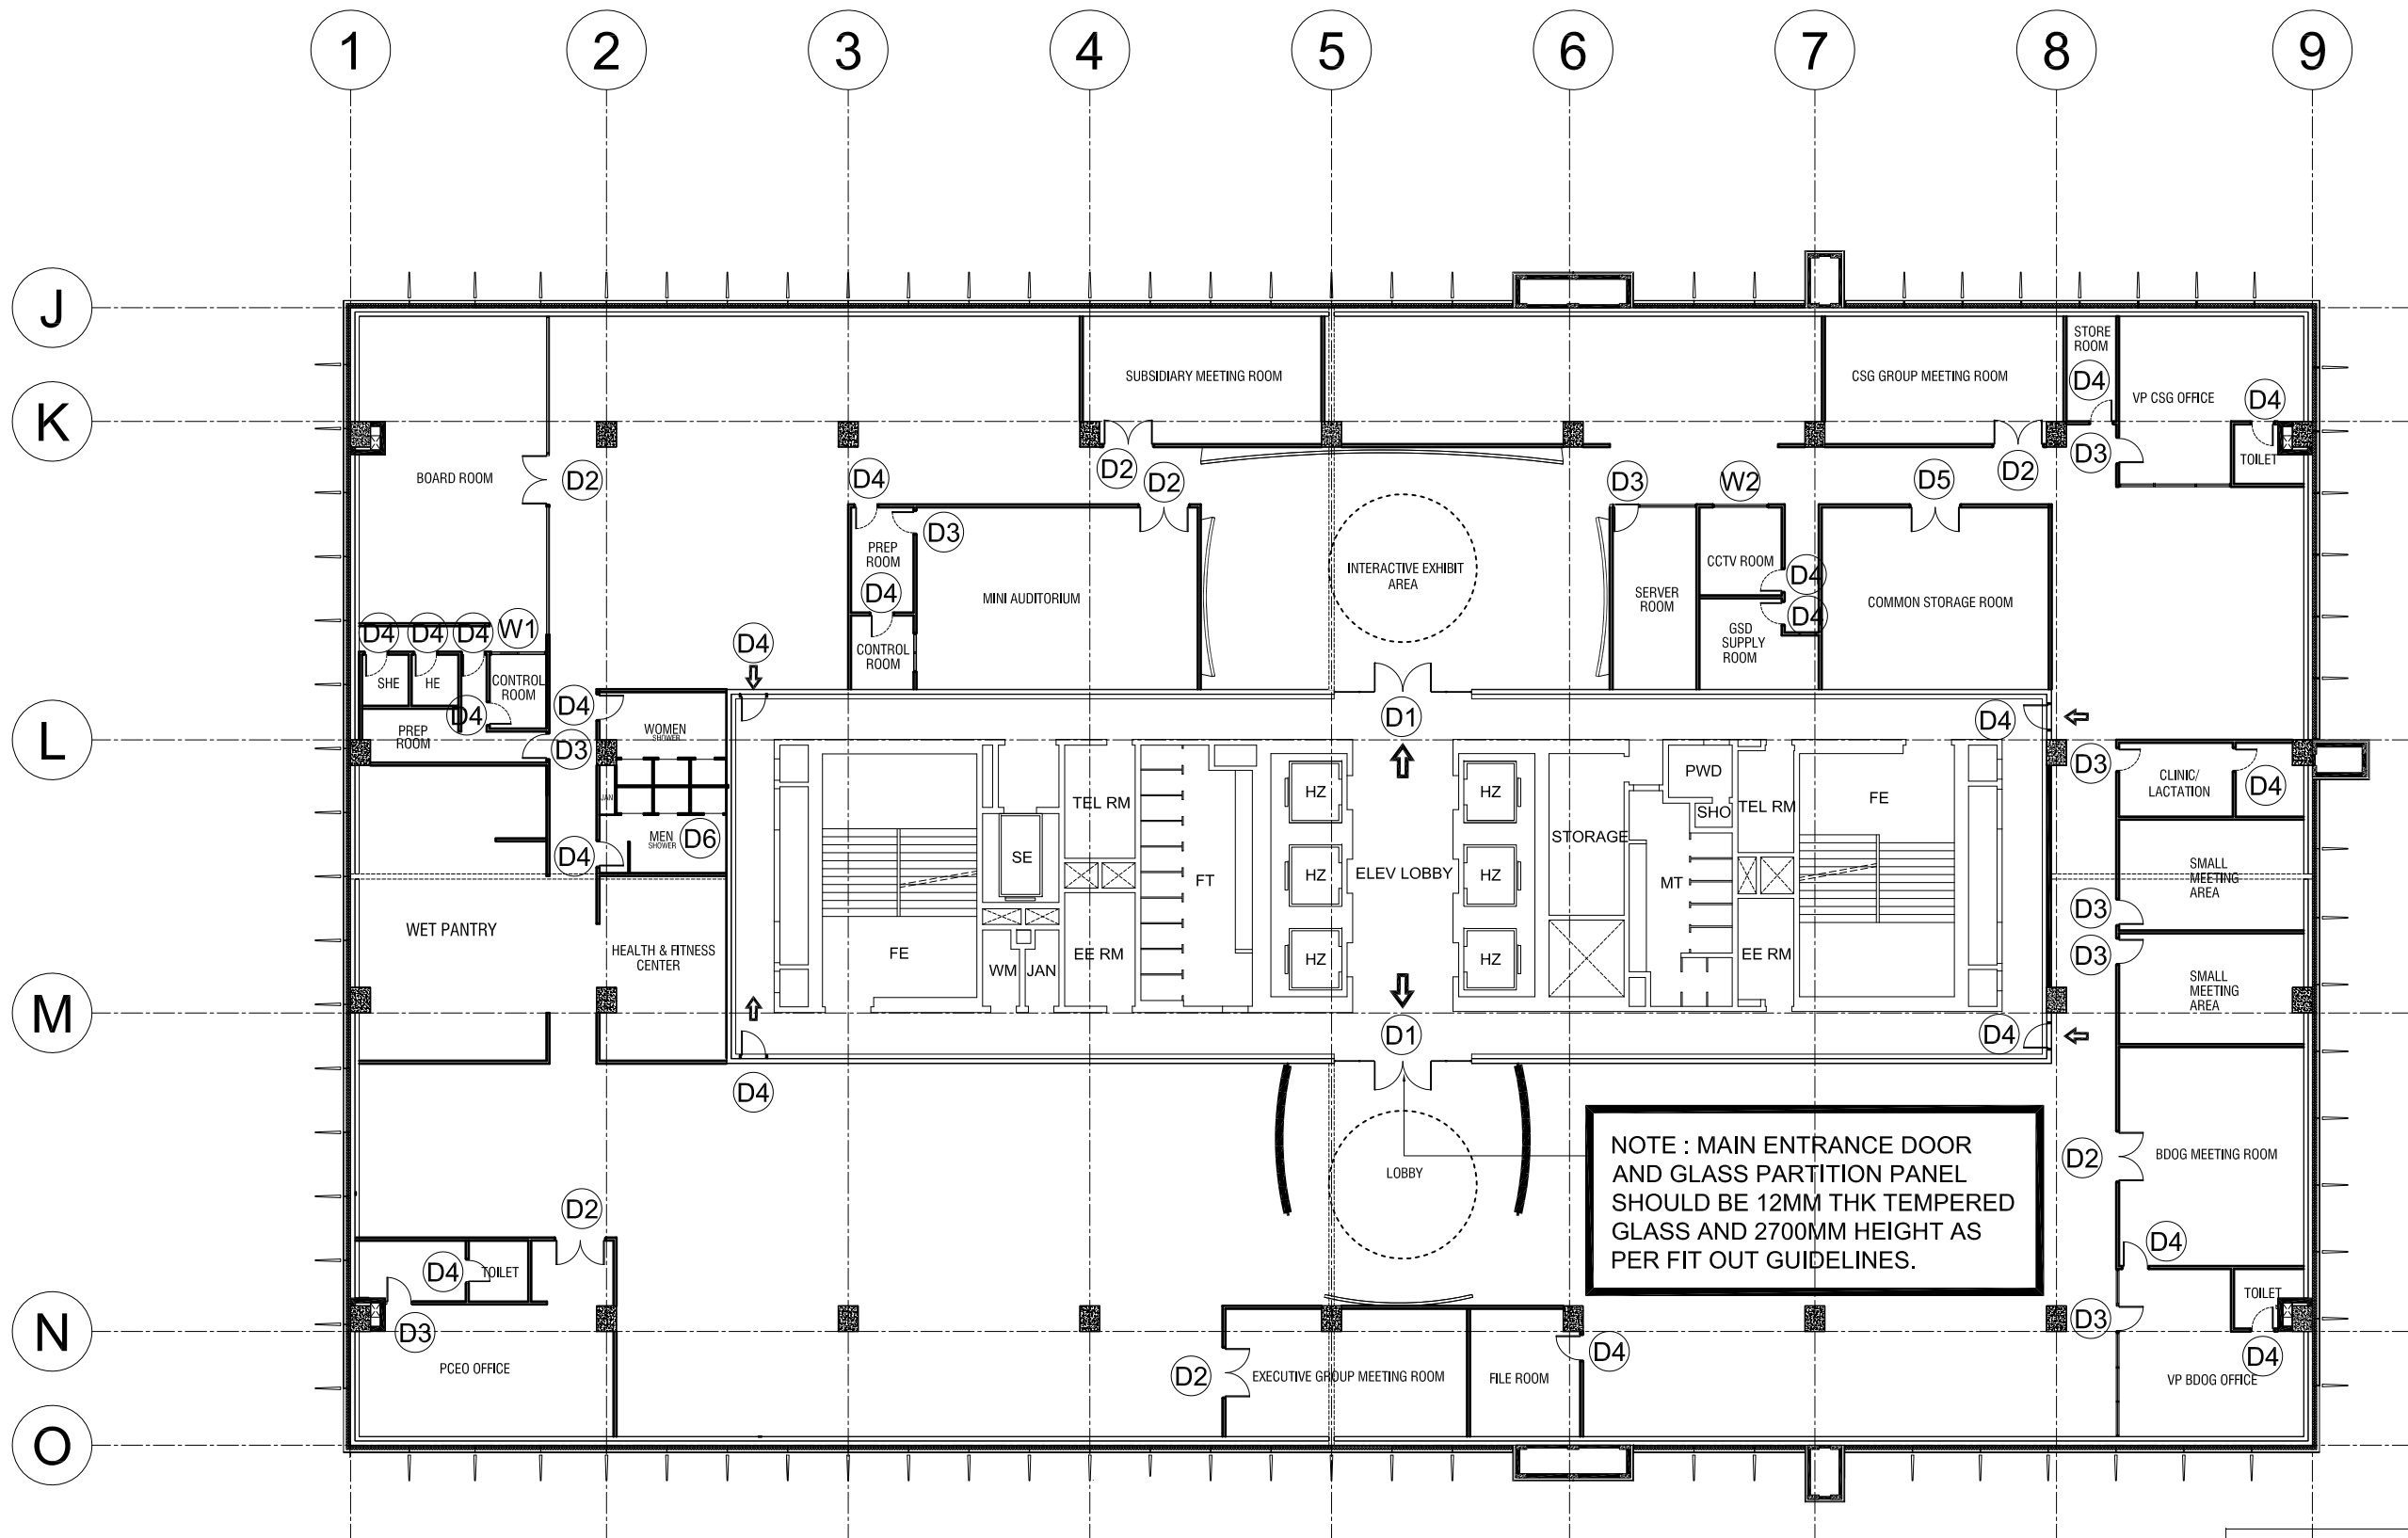

NOTE : MAIN ENTRANCE DOOR AND GLASS PARTITION PANEL SHOULD BE 12MM THK TEMPERED GLASS AND 2700MM HEIGHT AS PER FIT OUT GUIDELINES.

SCHEDULE OF DOORS & WINDOWS

BIDDERS AUTHORIZED REPRESENTATIVES

 Signature Over Printed Name



PROJECT NAME
 PROPOSED BCDA OFFICE
 CLARK FREE PORT ZONE, PAMPANGA

PREPARED BY
 JUDENE G. LAGOY
 NCC PMO

CHECKED & REVIEWED BY
 REINO STEPHEN A. AYO
 OIC GSD



RECOMMENDING APPROVAL
 BGEN CARLOS F. QUITA (RET.)
 VP CSG


APPROVED BY
 VIVENCIO B. DIZON
 PRESIDENT AND CEO

SHEET CONTENT
 SCHEDULE OF DOORS & WINDOWS
 SCALE 1 : 250 M. DATE : 03-07-2018

SHEET NO.
 A
 09

LEGEND:

-  POWER OUTLET
-  TELEPHONE OUTLET

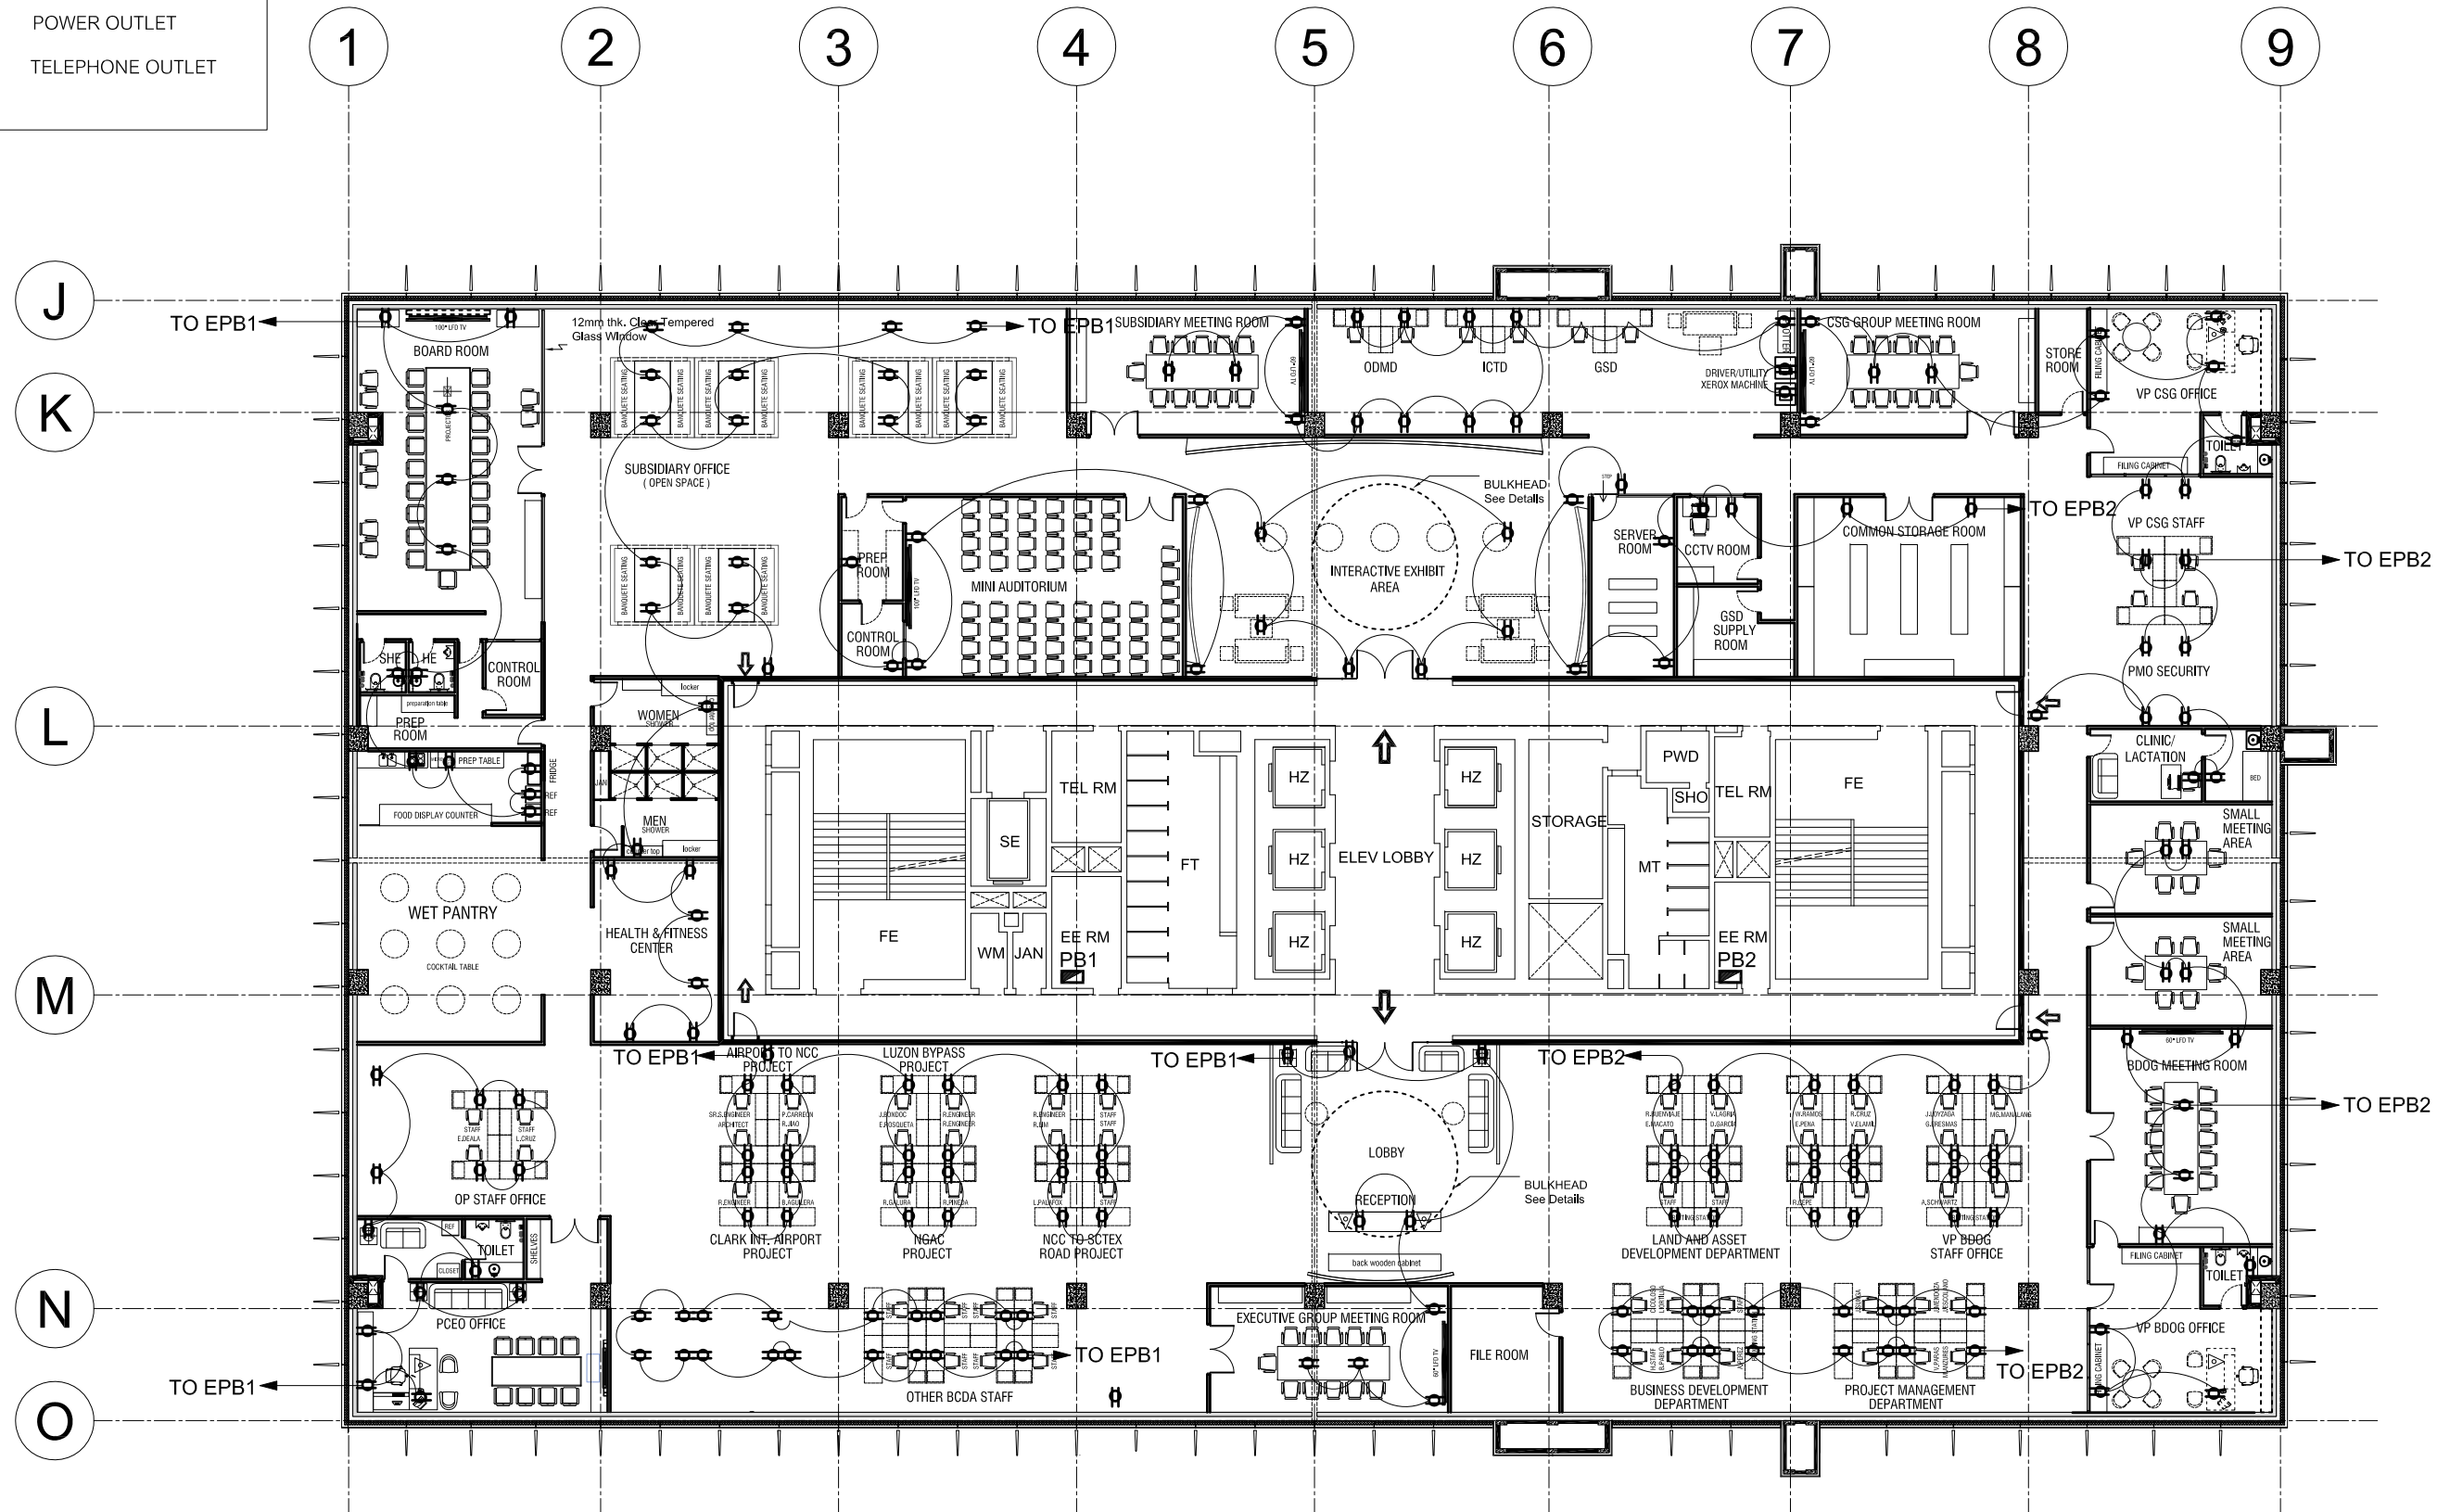

BIDDERS AUTHORIZED REPRESENTATIVES

Signature Over Printed Name



PROJECT NAME
PROPOSED BCDA OFFICE
CLARK FREE PORT ZONE, PAMPANGA

PREPARED BY
JUDENE G. LAGOY
NCC PMO

CHECKED & REVIEWED BY
REINO STEPHEN A. AYO
OIC GSD

 
 
RECOMMENDING APPROVAL
BGEN CARLOS F. QUITA (RET.)
VP CSG


APPROVED BY
VIVENCIO B. DIZON
PRESIDENT AND CEO

SHEET CONTENT
POWER LAYOUT
TELEPHONE LAYOUT
SCALE 1:250 M, DATE: 03-07-2018

SHEET NO.
E
01

LEGEND:

-  120 NODES (DATA POINT)
-  4 NODES (PROVIDERS)
- TOTAL = 124 NODES

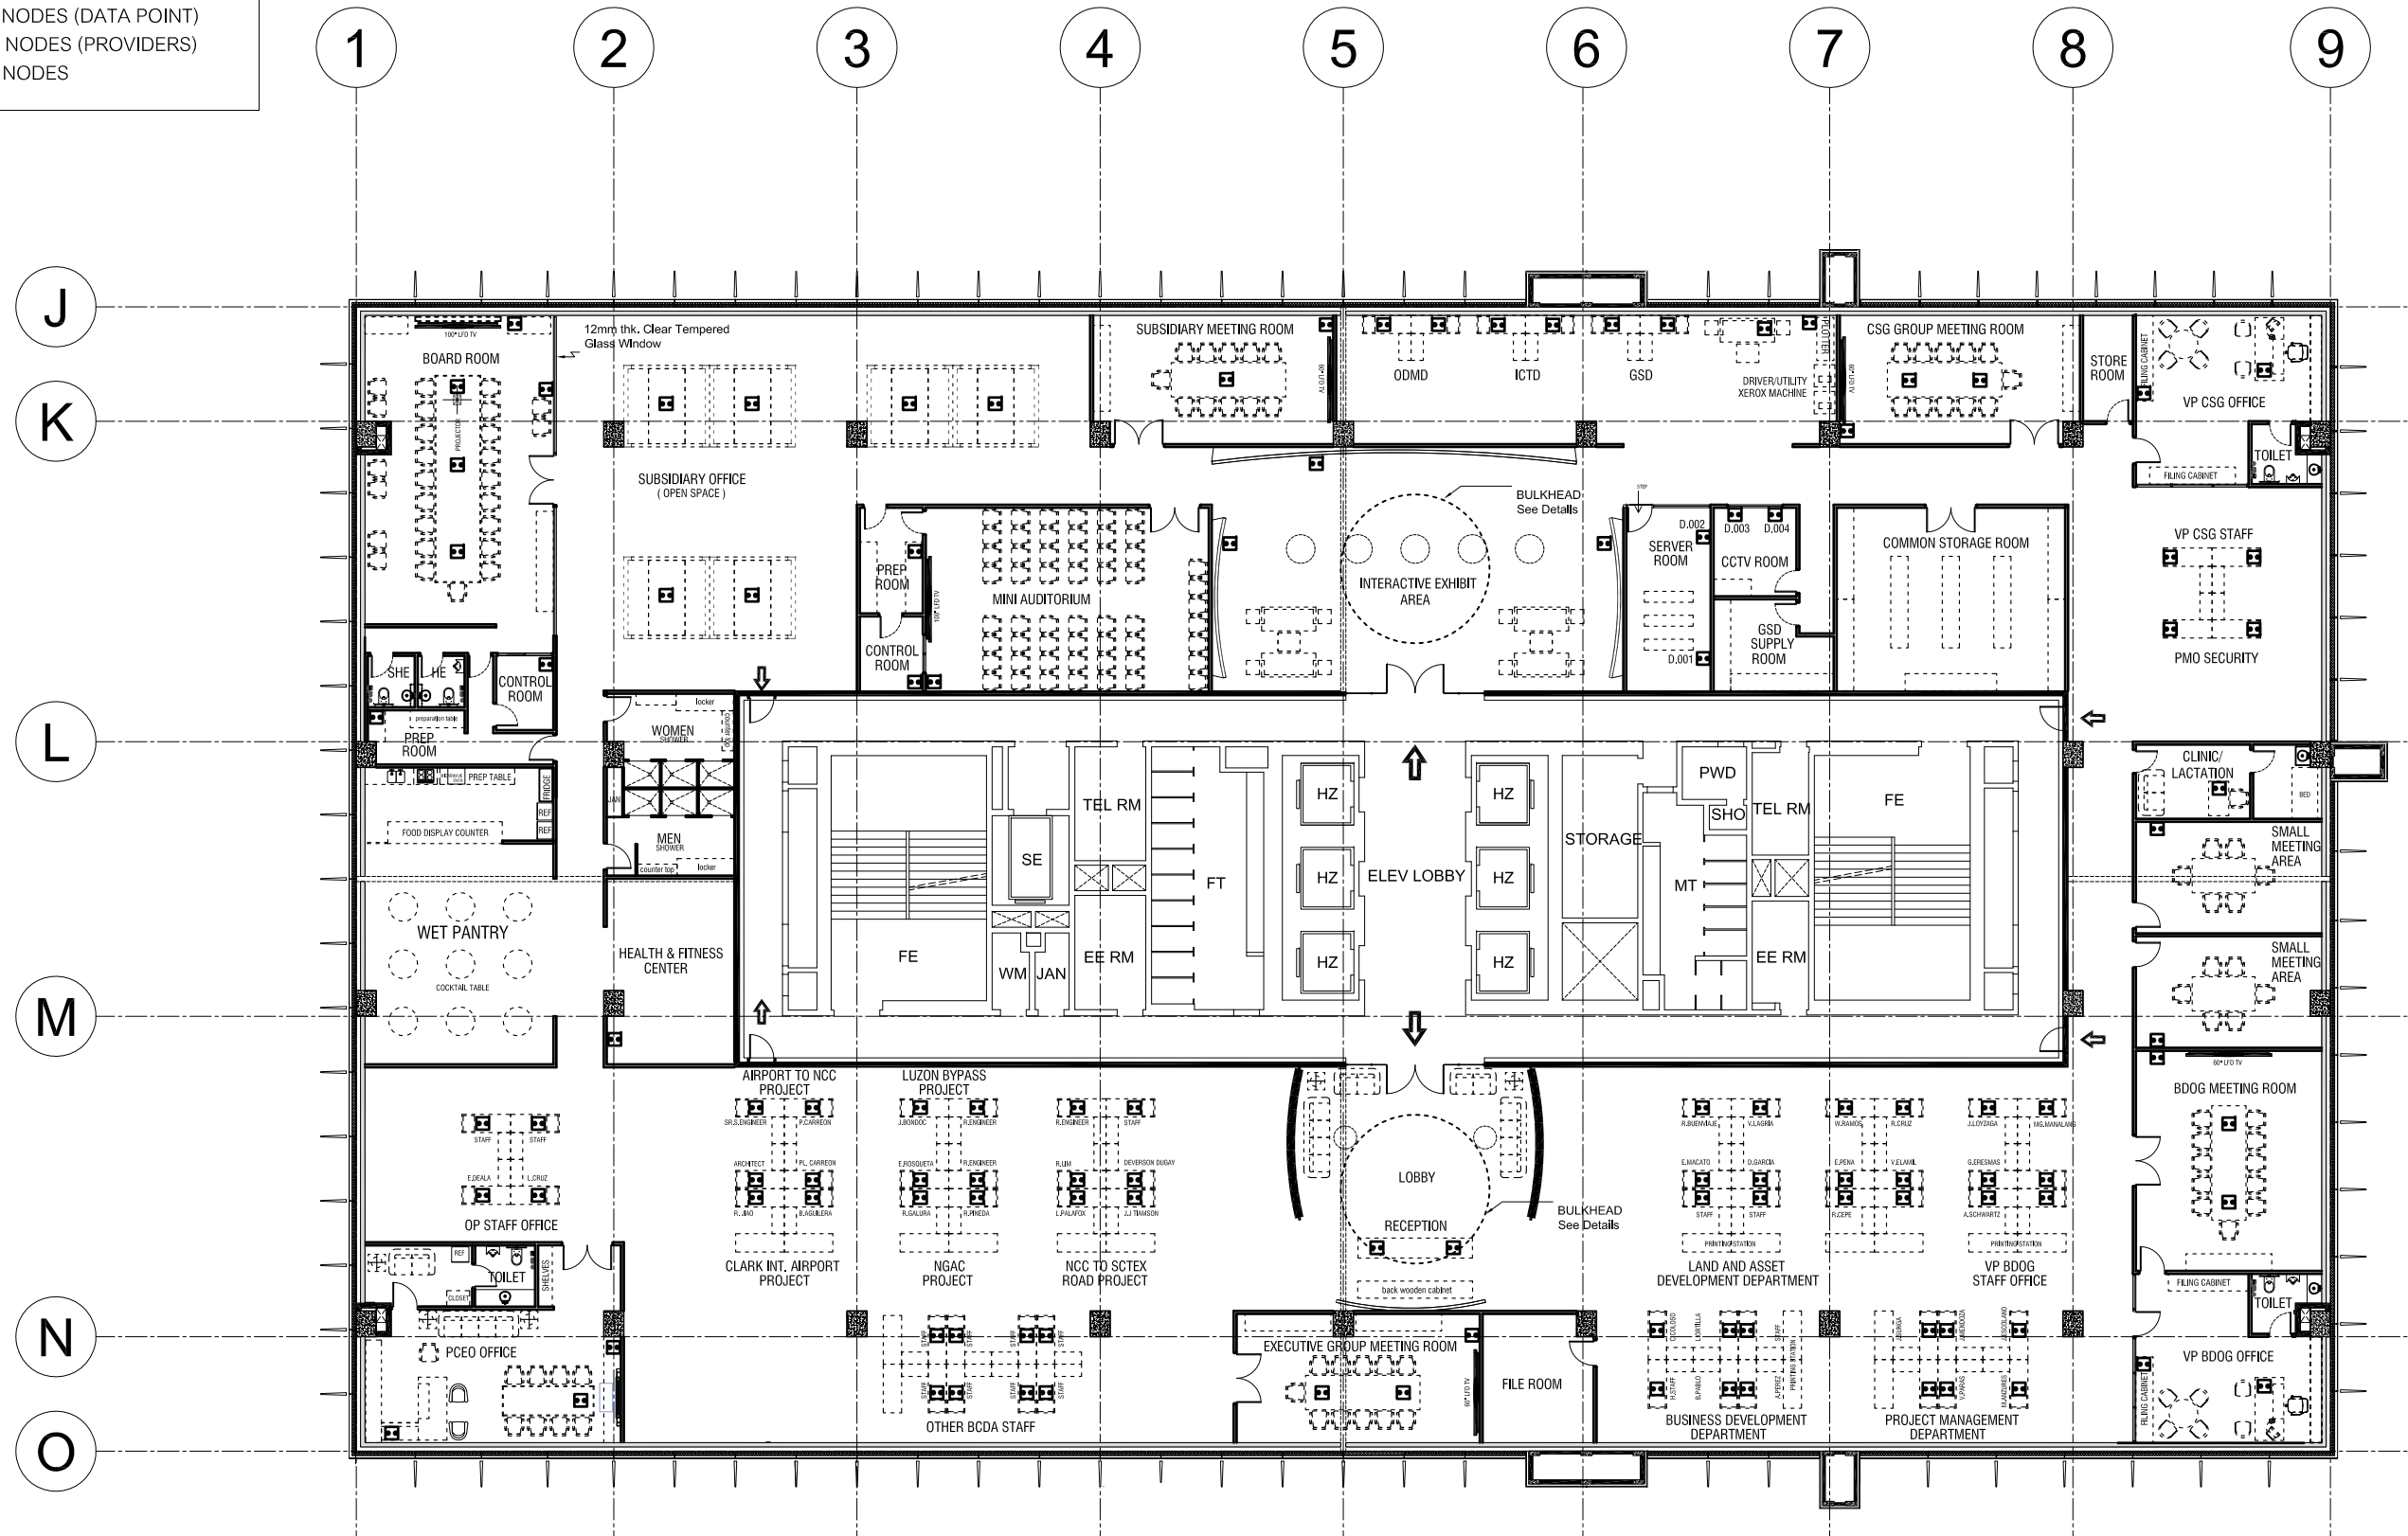

BIDDERS AUTHORIZED REPRESENTATIVES

Signature Over Printed Name



PROJECT NAME
PROPOSED BCDA OFFICE
CLARK FREE PORT ZONE, PAMPANGA

PREPARED BY
ALEX S. MIJARES
ICTD

CHECKED & REVIEWED BY
REINO STEPHEN A. AYO
OIC GSD




RECOMMENDING APPROVAL
BGEN CARLOS F. QUITA (RET.)
VP CSG


APPROVED BY
VIVENCIO B. DIZON
PRESIDENT AND CEO

SHEET CONTENT
DATA NODS PLAN
SCALE 1:250 M, DATE: 03-19-2018

SHEET NO.
E
02

LEGEND:

-  11 pcs. WIFI ACCESS POINT WITH LAN NODE EACH
-  DOOR ACCESS WITH POWER OUTLET & LAN NODE EACH
-  12 NODES (IP CAMERA) WITH LAN NODE EACH

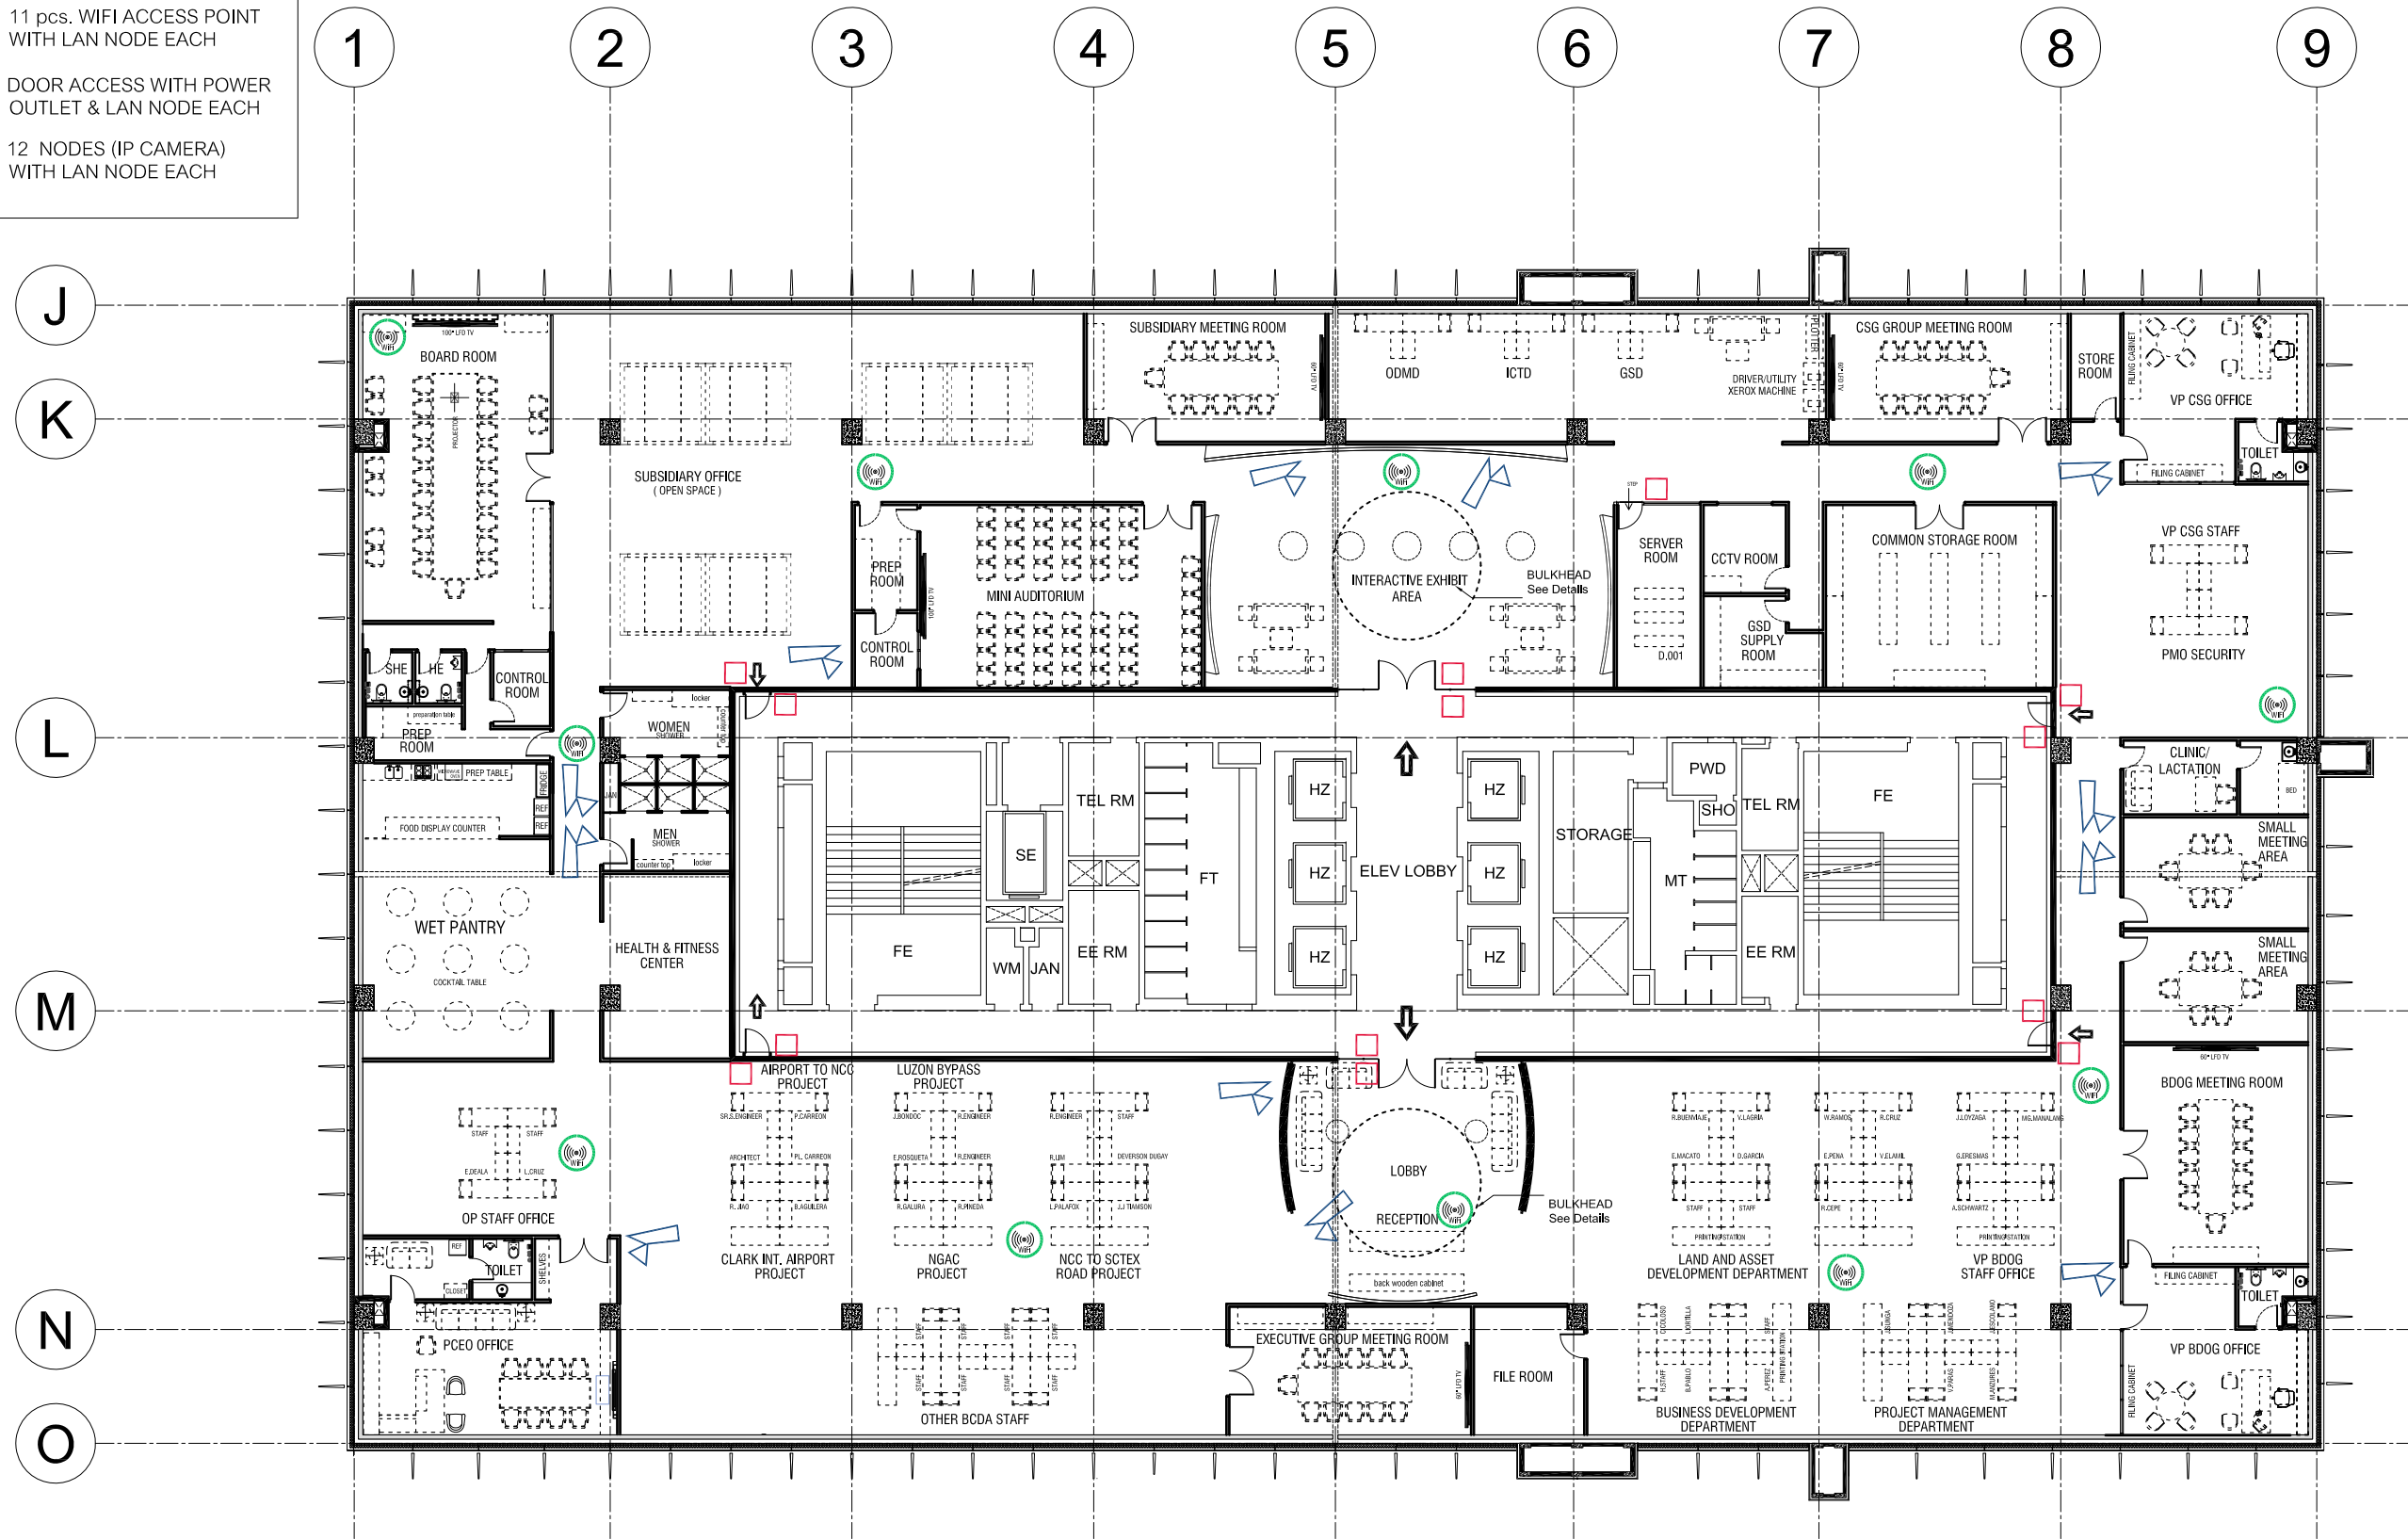


BIDDERS AUTHORIZED REPRESENTATIVES

Signature Over Printed Name



PROJECT NAME	PREPARED BY	CHECKED & REVIEWED BY	RECOMMENDING APPROVAL	APPROVED BY	SHEET CONTENT	SHEET NO.
PROPOSED BCDA OFFICE CLARK FREE PORT ZONE, PAMPANGA	ALEX S. MIJARES ICTD	REINO STEPHEN A. AYO OIC GSD	BGEN CARLOS F. QUITA (RET.) VP CSG	VIVENCIO B. DIZON PRESIDENT AND CEO	WIFI ACCESS POINT IP CAMERA	E
					SCALE 1: 250 M.	DATE: 03-19-2018
						03

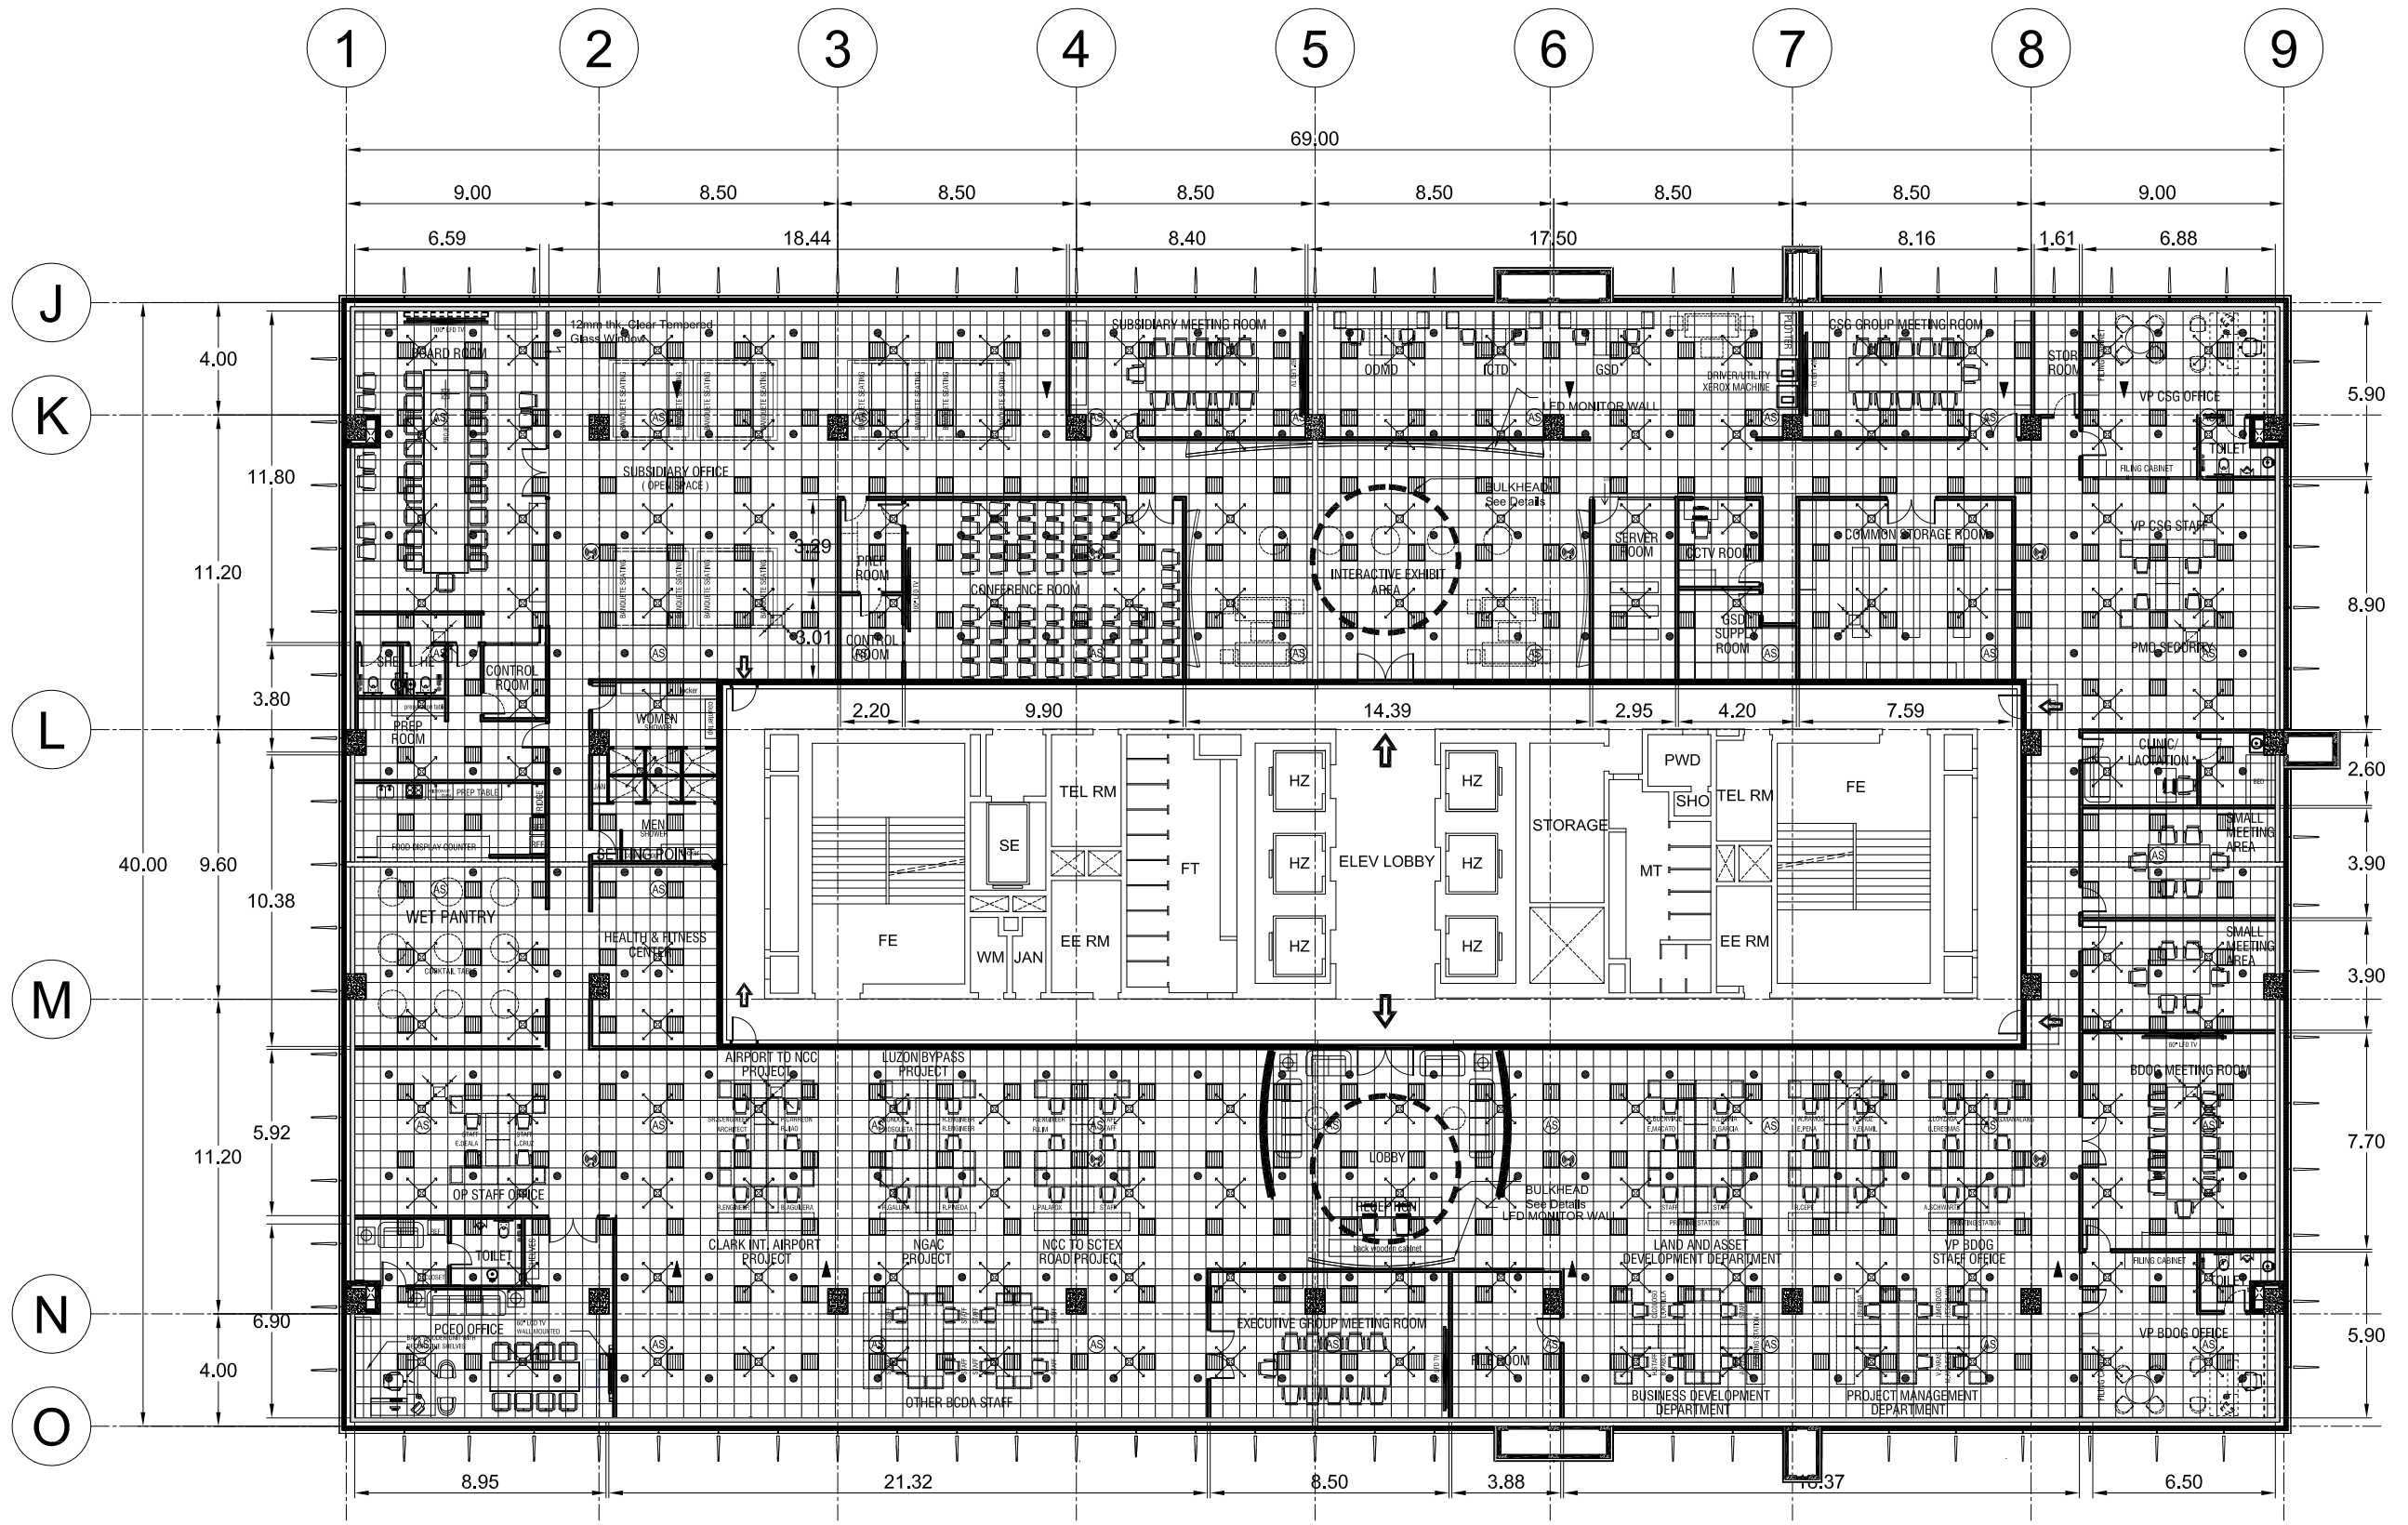

NOTE : PROVIDE THE NECESSARY ADJUSTMENTS ON THE FIRE ALARM SYSTEM SPRINKLER HEADS, LIGHTINGS AND AC DUCTING IN THE INSTALATION OF WALL PARTITION.


REFLECTED CEILING PLAN

BIDDERS AUTHORIZED REPRESENTATIVES


Signature Over Printed Name




PROJECT NAME	PREPARED BY	CHECKED & REVIEWED BY	RECOMMENDING APPROVAL	APPROVED BY	SHEET CONTENT	SHEET NO.
PROPOSED BCDA OFFICE CLARK FREE PORT ZONE , PAMPANGA	JUDENE G. LAGOY NCC PMO	REINO STEPHEN A. AYO OIC GSD	BGEN CARLOS F. QUITA (RET.) VP CSG	VIVENCIO B. DIZON PRESIDENT AND CEO	REFLECTED CEILING PLAN	M
					SCALE 1 : 250 M. DATE : 03-07-2018	01

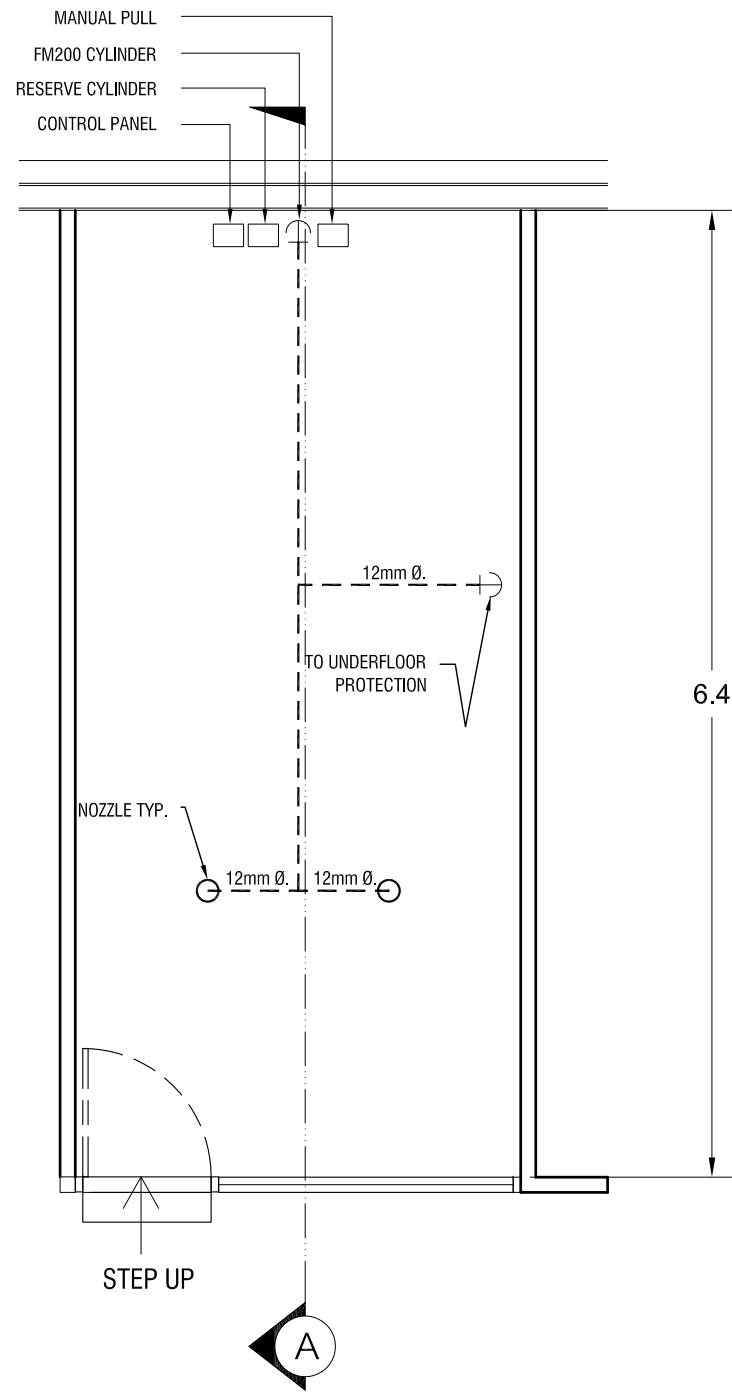

M2
3
FM-200 LAYOUT
SCALE 1:50M

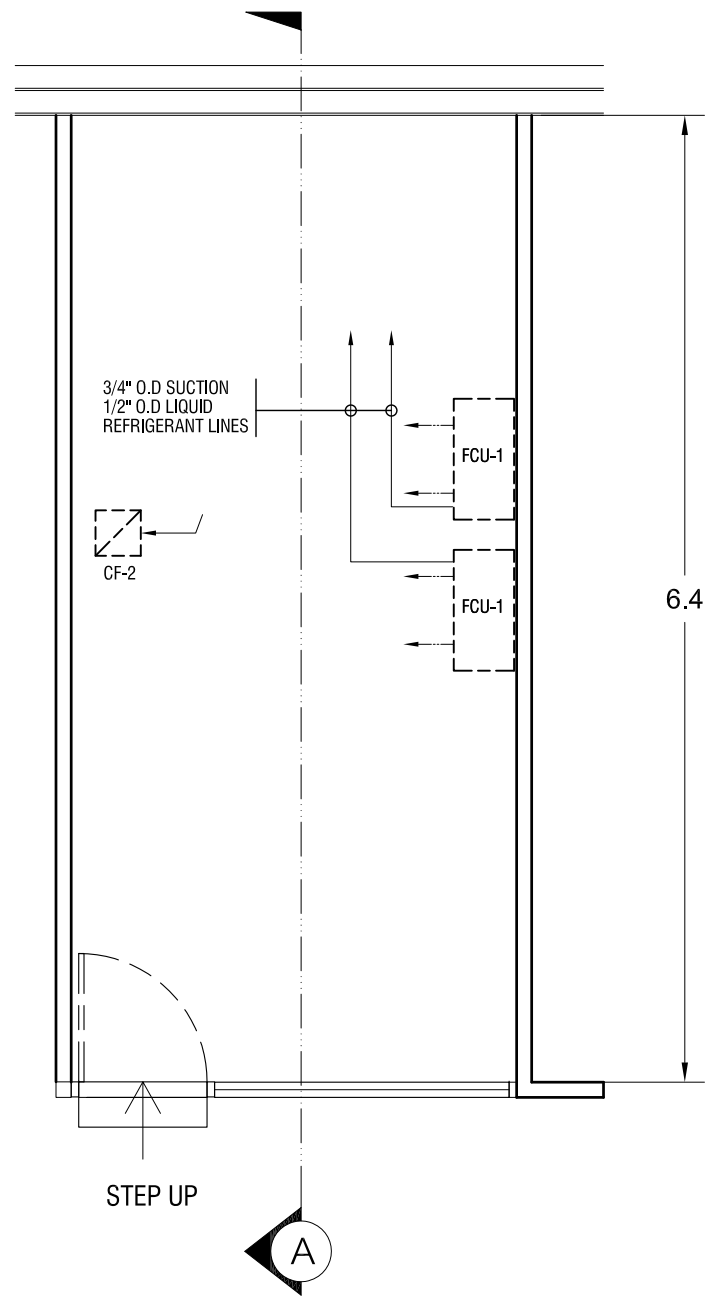

M2
2
SERVER ROOM AC LAYOUT
SCALE 1:50M

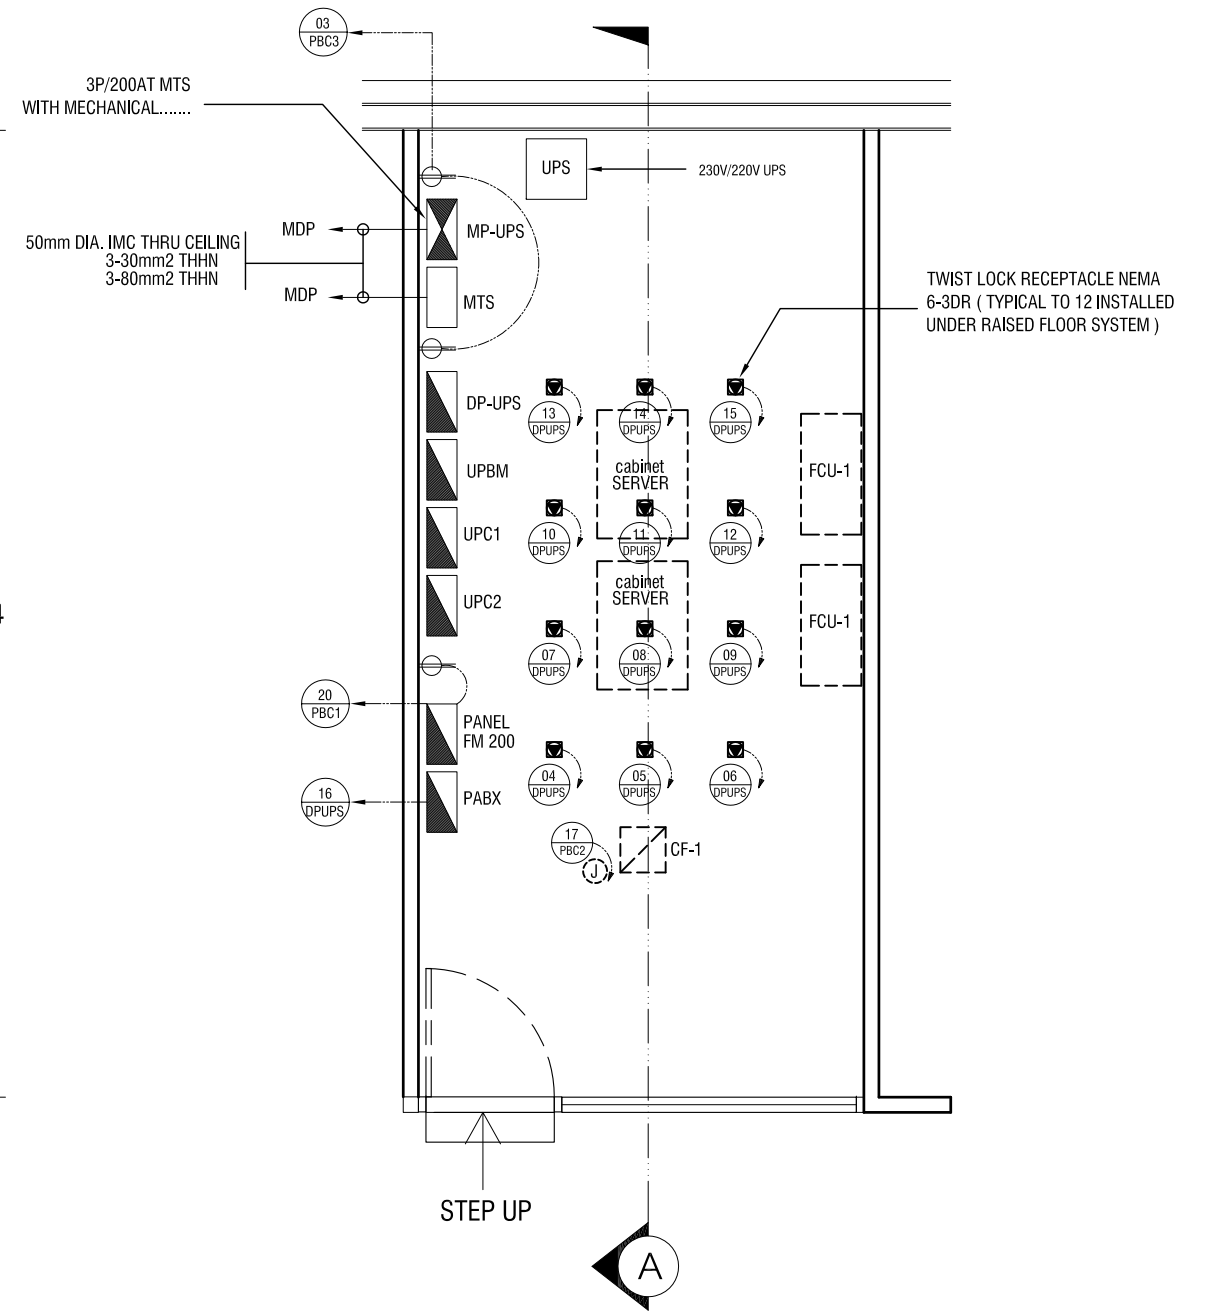

M2
1
SERVER ROOM ELECTRICAL BLOW UP PLAN
SCALE 1:50M

BIDDERS AUTHORIZED REPRESENTATIVES

Signature Over Printed Name



PROJECT NAME
PROPOSED BCDA OFFICE
CLARK FREE PORT ZONE, PAMPANGA

PREPARED BY
JUDENE G. LAGOY
NCC PMO


CHECKED & REVIEWED BY
REINO STEPHEN AYO
OIC GSD

RECOMMENDING APPROVAL
BGEN CARLOS F. QUITA (RET.)
VP CSG


APPROVED BY
VIVENCIO B. DIZON
PRESIDENT AND CEO

SHEET CONTENT
SERVER ROOM LAYOUT
SCALE 1:50 M. DATE: 03-07-2018

SHEET NO.
M
2

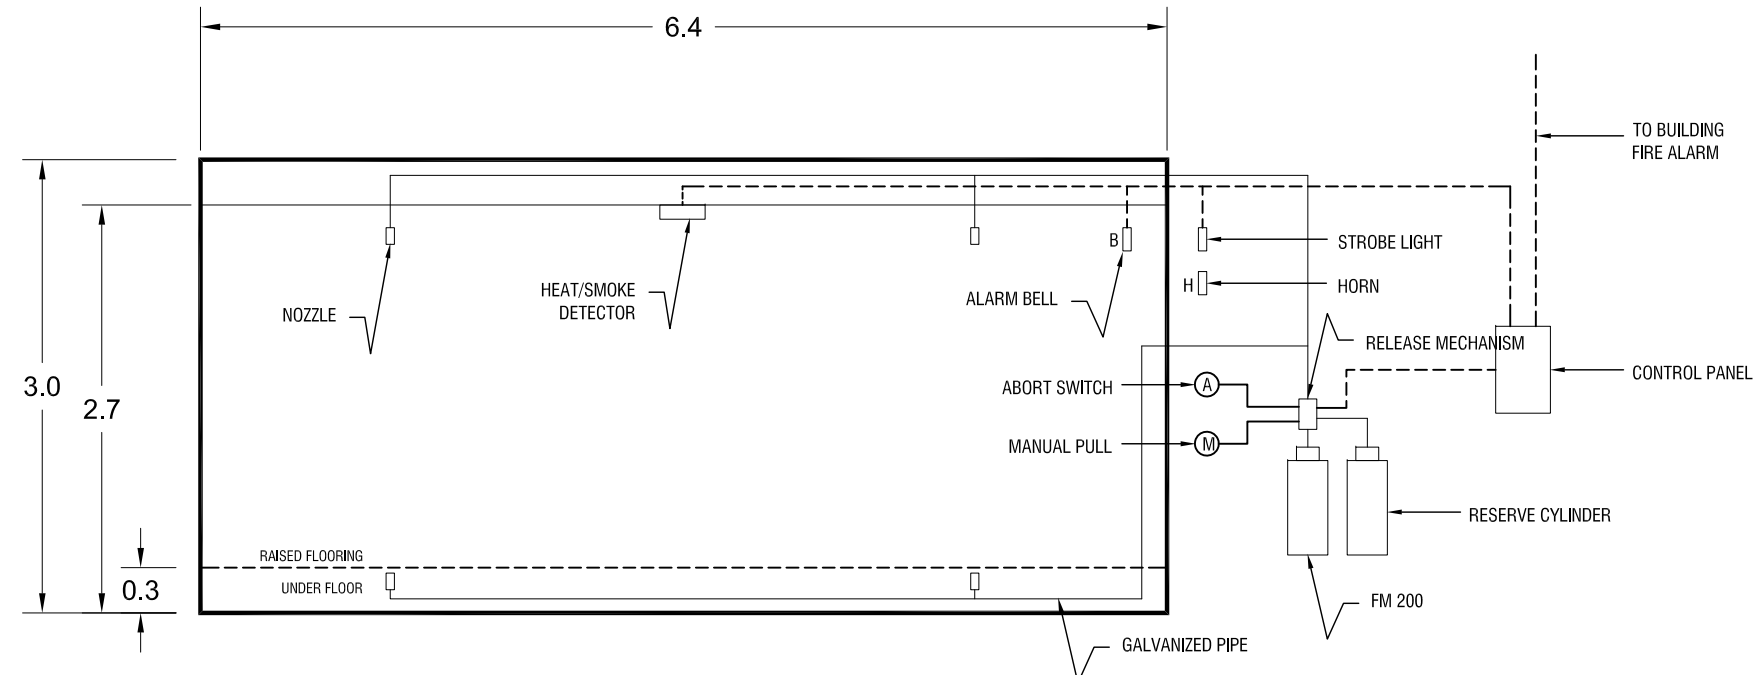

M3
2
FM- 200 SCHEMATIC DIAGRAM
SCALE 1:50M

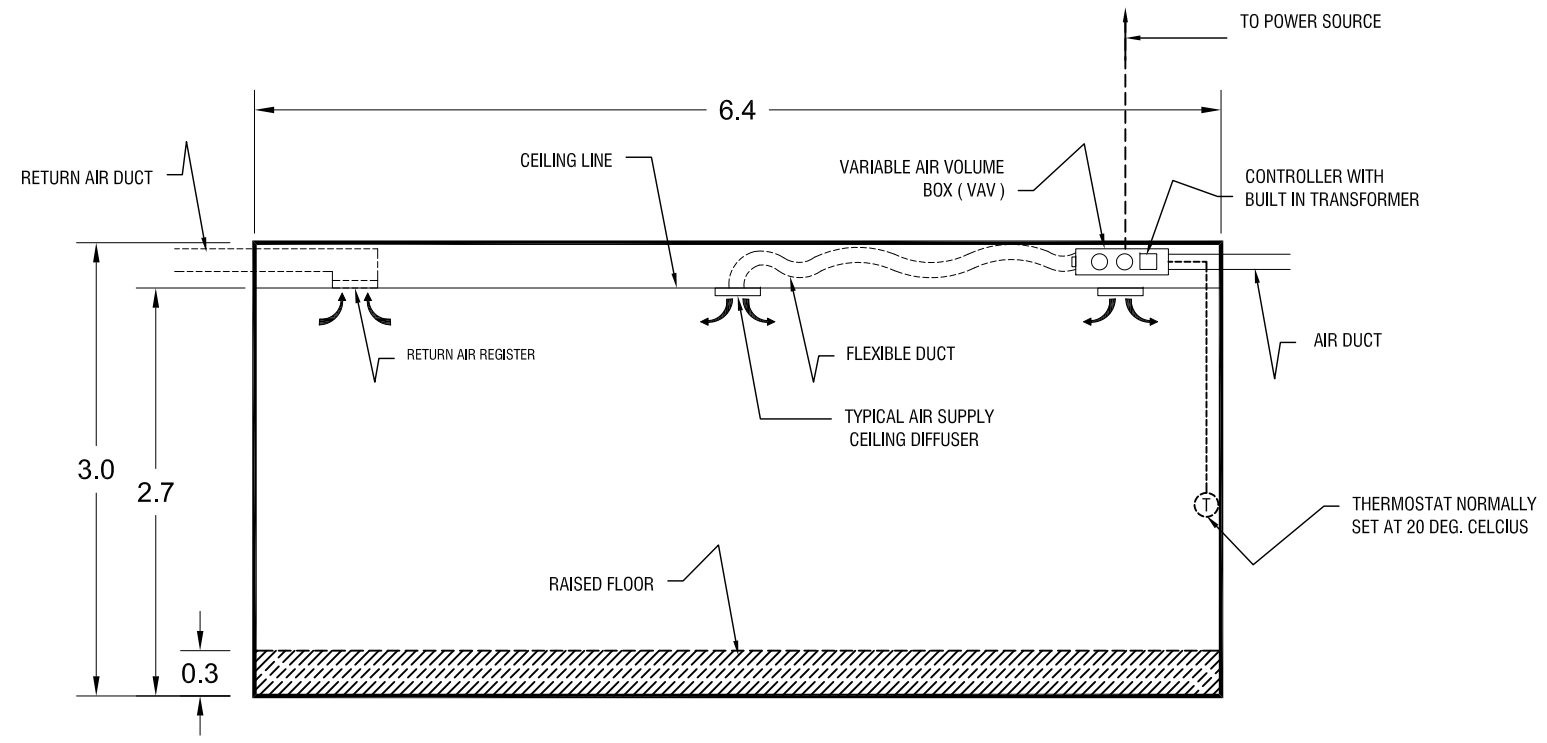

M3
1
**SECTION A-A
TYPICAL ROOM COOLING
SYSTEM DIAGRAM**
SCALE 1:50M

BIDDERS AUTHORIZED REPRESENTATIVES

Signature Over Printed Name



PROJECT NAME
PROPOSED BCDA OFFICE
CLARK FREE PORT ZONE , PAMPANGA

PREPARED BY
JUDENE G. LAGOY
NCC PMO

CHECKED & REVIEWED BY
REINO STEPHEN AYO
OIC GSD

RECOMMENDING APPROVAL
BGEN CARLOS F. QUITA (RET.)
VP CSG


APPROVED BY
VIVENCIO B. DIZON
PRESIDENT AND CEO

SHEET CONTENT
SCHEMATIC DIAGRAM
TYPICAL SECTION
SCALE 1:50 M. DATE: 03-07-2018

SHEET NO.
M
3

NOTE : FLUID APPLIED WATER PROOFING MEMBRANE MATERIALS MUST BE PROVIDED ON THE FLOORING WITH SLOPE TOWARDS THE DRAIN. SUCH WATER PROOFING SHALL BE APPLIED UP TO 200MM ON ADJACENT WALLS. THE WATER PROOFING INSTALLATION SHOULD BE TESTED FOR LEAKS (24-HOUR FLOOD TEST)

NOTE : CORING FOR PIPE PENETRATION FOR PLUMBING AND DRAINAGE IN ACCORDANCE WITH THE APPROVED FIT OUT DESIGN. THE CONTRACTOR IS RESPONSIBLE FOR PROTECTING THE STRUCTURAL INTEGRITY OF THE FLOOR AND SHALL PROVIDE CONCRETE SCANNING TO ENSURE THAT NO REINFORCING STEEL WILL CUT THROUGH. SUCH CORING SHALL BE SUBJECT TO THE OWNERS NOMINATED STRUCTURAL ENGINEER AND OWNERS APPROVAL.

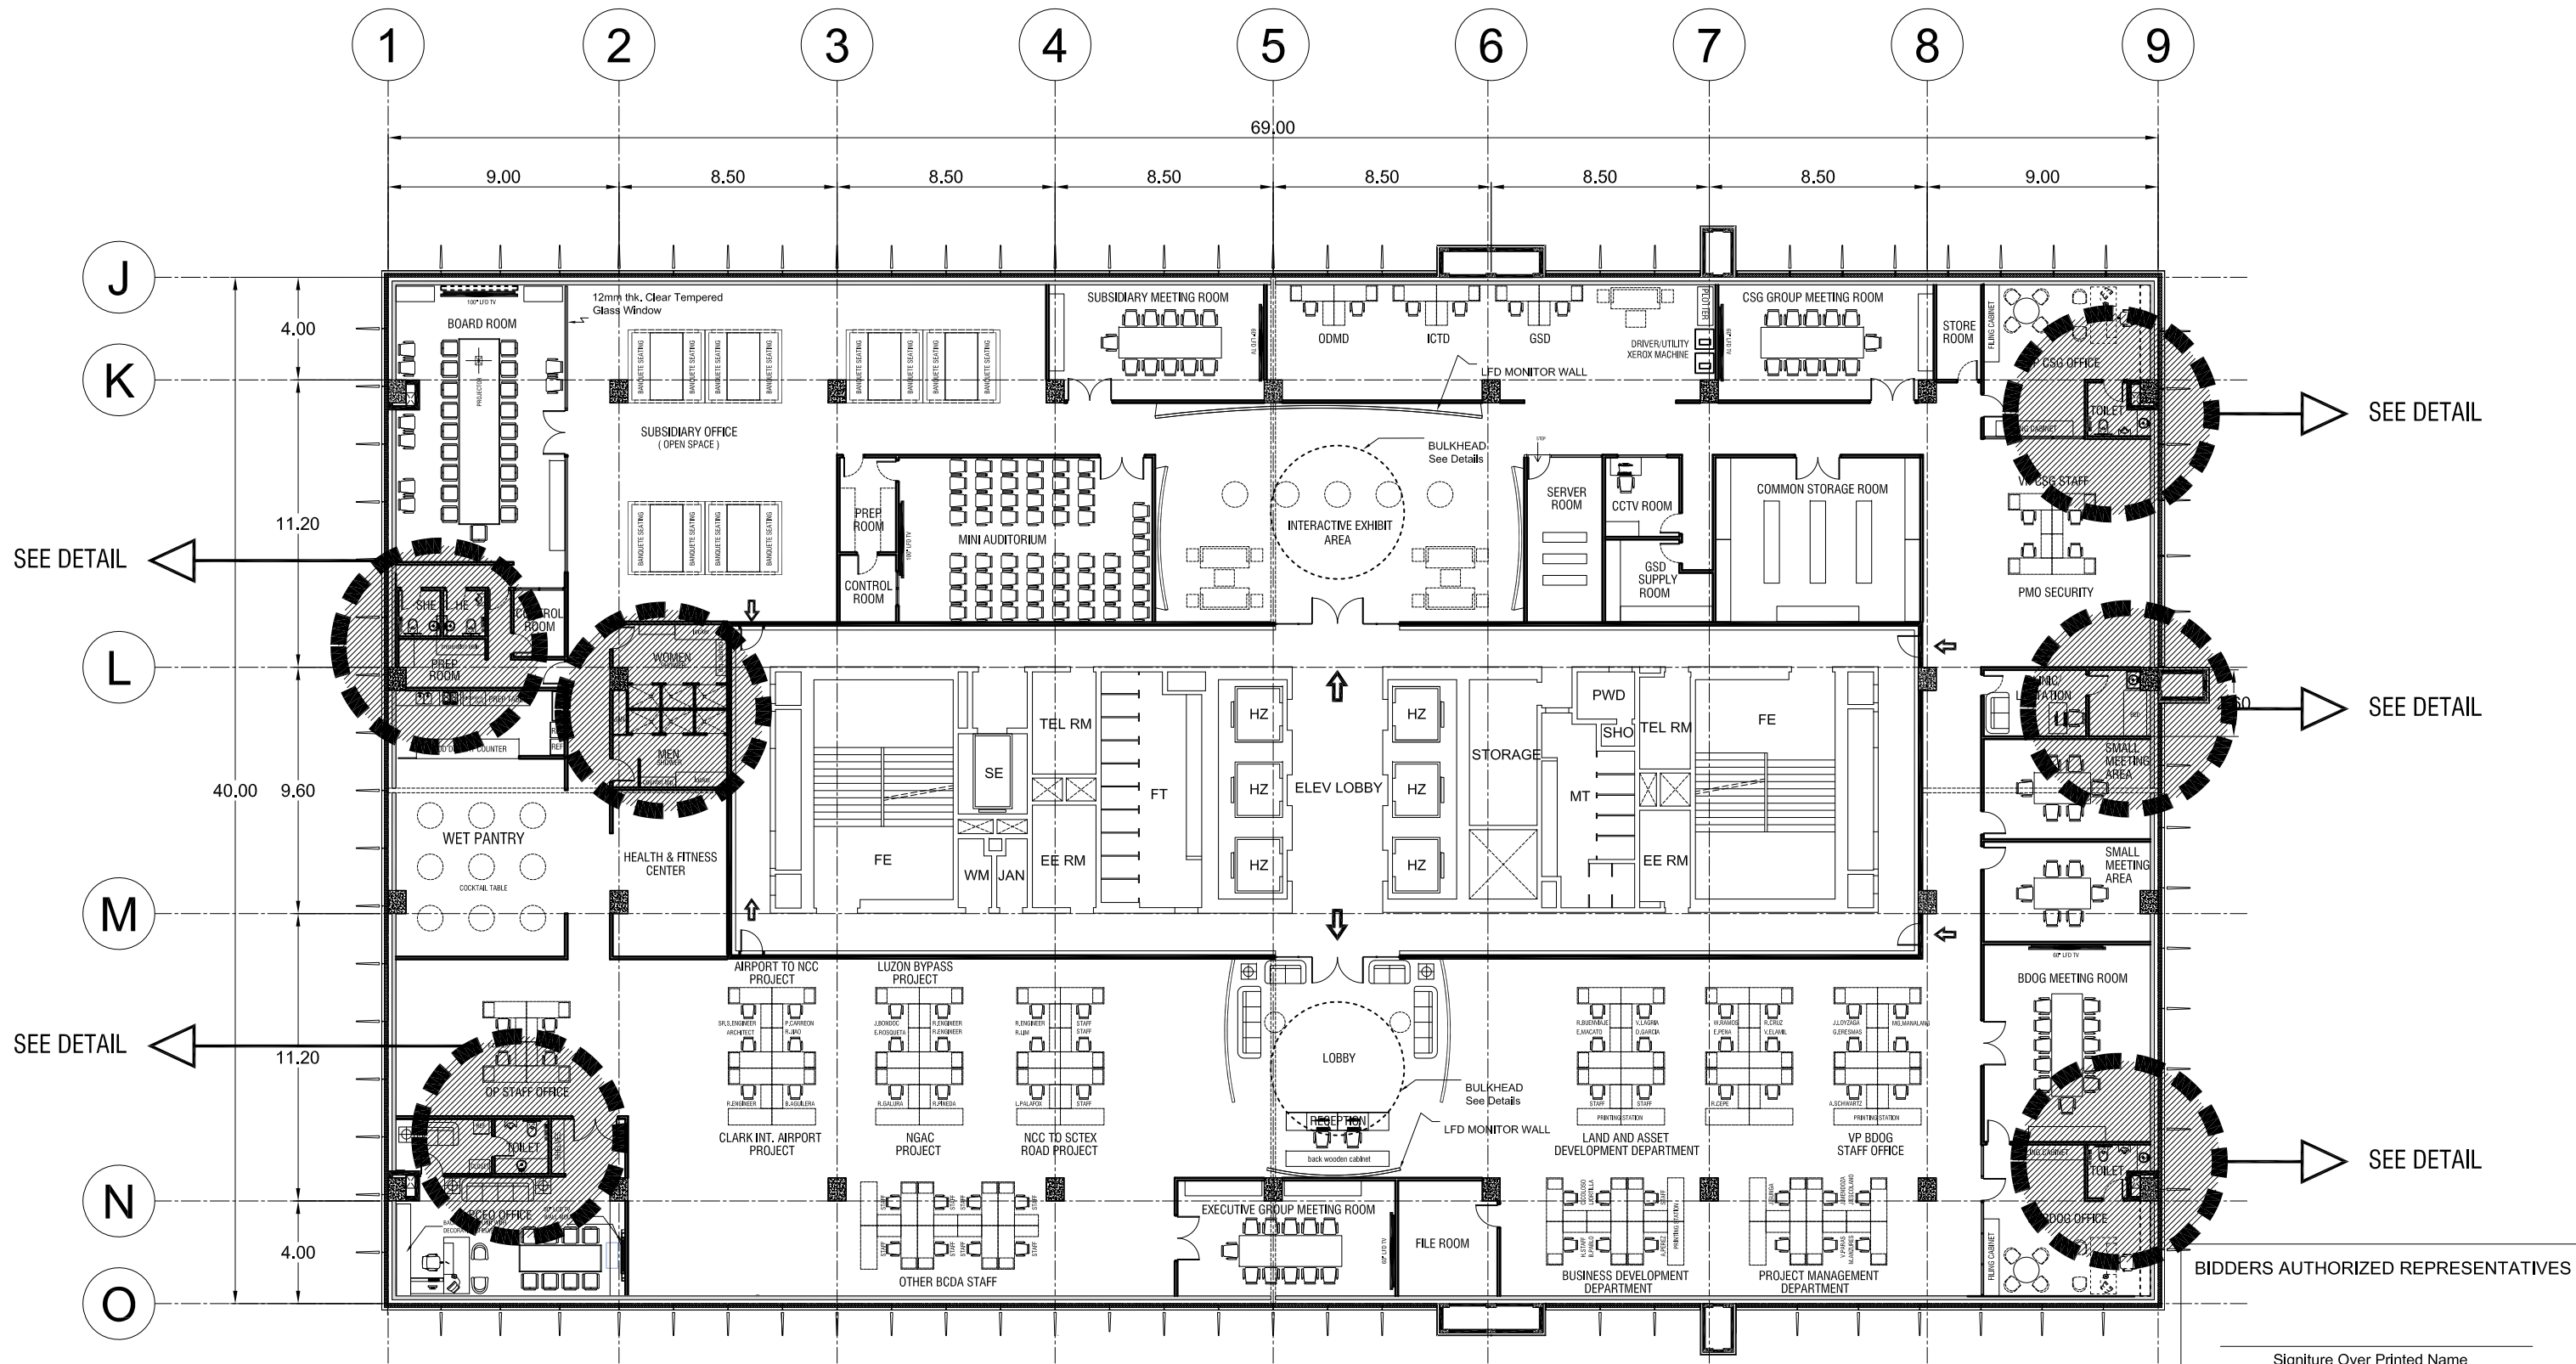


BIDDERS AUTHORIZED REPRESENTATIVES

 Signature Over Printed Name



PROJECT NAME	PREPARED BY	CHECKED & REVIEWED BY	RECOMMENDING APPROVAL	APPROVED BY	SHEET CONTENT	SHEET NO.
PROPOSED BCDA OFFICE CLARK FREE PORT ZONE , PAMPANGA	JUDENE G. LAGOY NCC PMO	REINO STEPHEN A. AYO OIC GSD	BGEN CARLOS F. QUITA (RET.) VP CSG	VIVENCIO B. DIZON PRESIDENT AND CEO	SANITARY LINE LAYOUT	P 01
					SCALE 1 : 250 M, DATE : 03-07-2018	

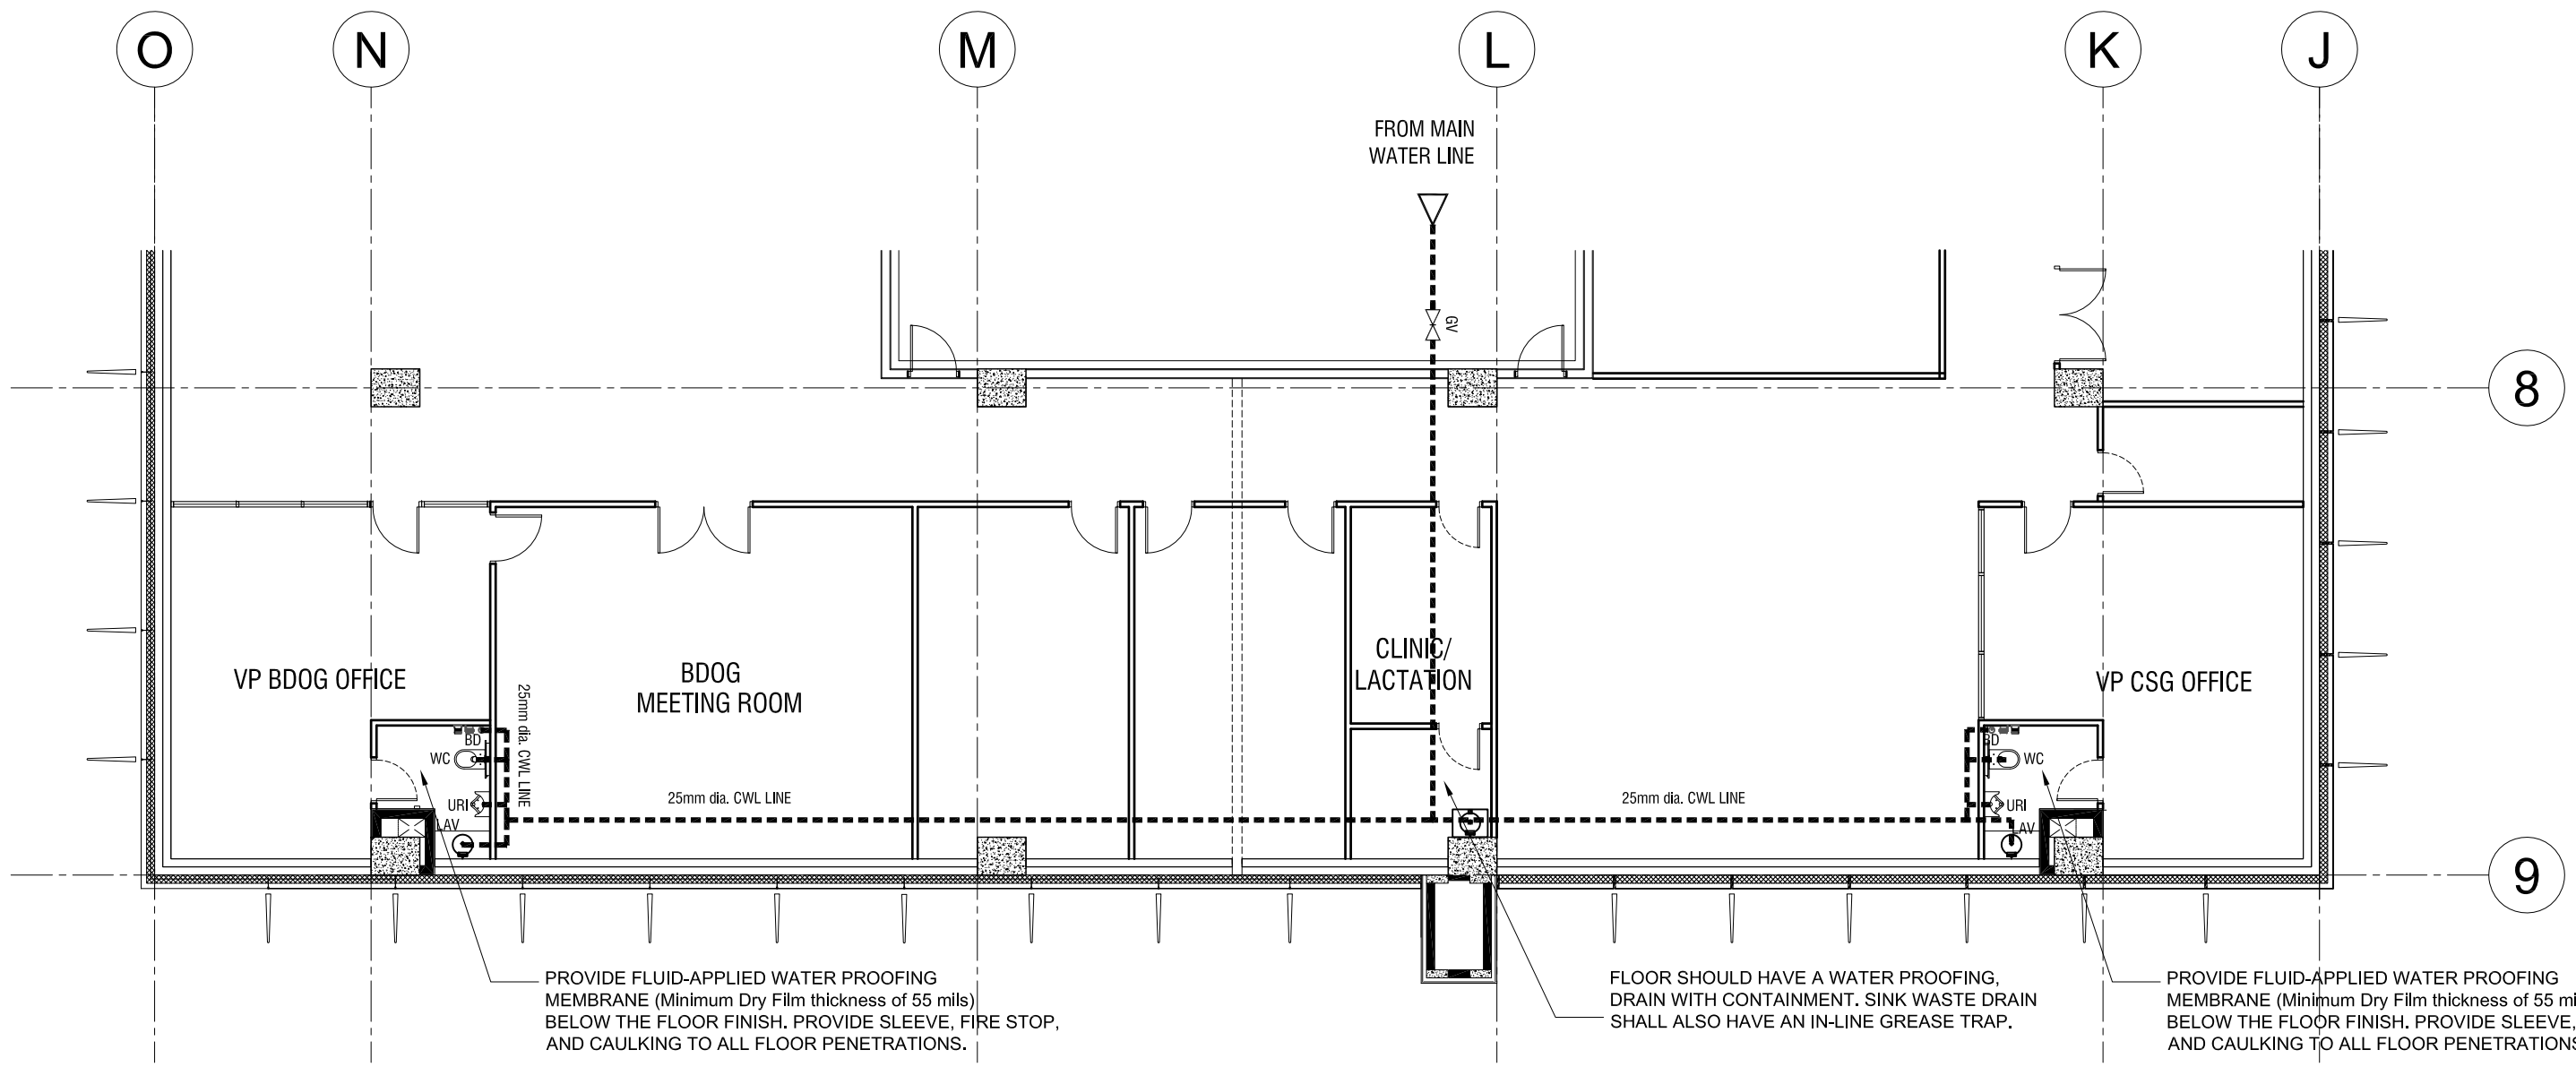

PROVIDE FLUID-APPLIED WATER PROOFING MEMBRANE (Minimum Dry Film thickness of 55 mils) BELOW THE FLOOR FINISH. PROVIDE SLEEVE, FIRE STOP, AND CAULKING TO ALL FLOOR PENETRATIONS.

FLOOR SHOULD HAVE A WATER PROOFING, DRAIN WITH CONTAINMENT. SINK WASTE DRAIN SHALL ALSO HAVE AN IN-LINE GREASE TRAP.

PROVIDE FLUID-APPLIED WATER PROOFING MEMBRANE (Minimum Dry Film thickness of 55 mils) BELOW THE FLOOR FINISH. PROVIDE SLEEVE, FIRE STOP, AND CAULKING TO ALL FLOOR PENETRATIONS.

BIDDERS AUTHORIZED REPRESENTATIVES

Signature Over Printed Name



PROJECT NAME
PROPOSED BCDA OFFICE
CLARK FREE PORT ZONE, PAMPANGA

PREPARED BY
JUDENE G. LAGOY
NCC PMO


CHECKED & REVIEWED BY
REINO STEPHEN A. AYO
OIC GSD

RECOMMENDING APPROVAL
BGEN CARLOS F. QUITA (RET.)
VP CSG

APPROVED BY
VIVENCIO B. DIZON
PRESIDENT AND CEO

SHEET CONTENT
BLOW-UP PLAN
WATER SUPPLY LINE
SCALE 1:125 M, DATE: 03-07-2018


SHEET NO.
P
02

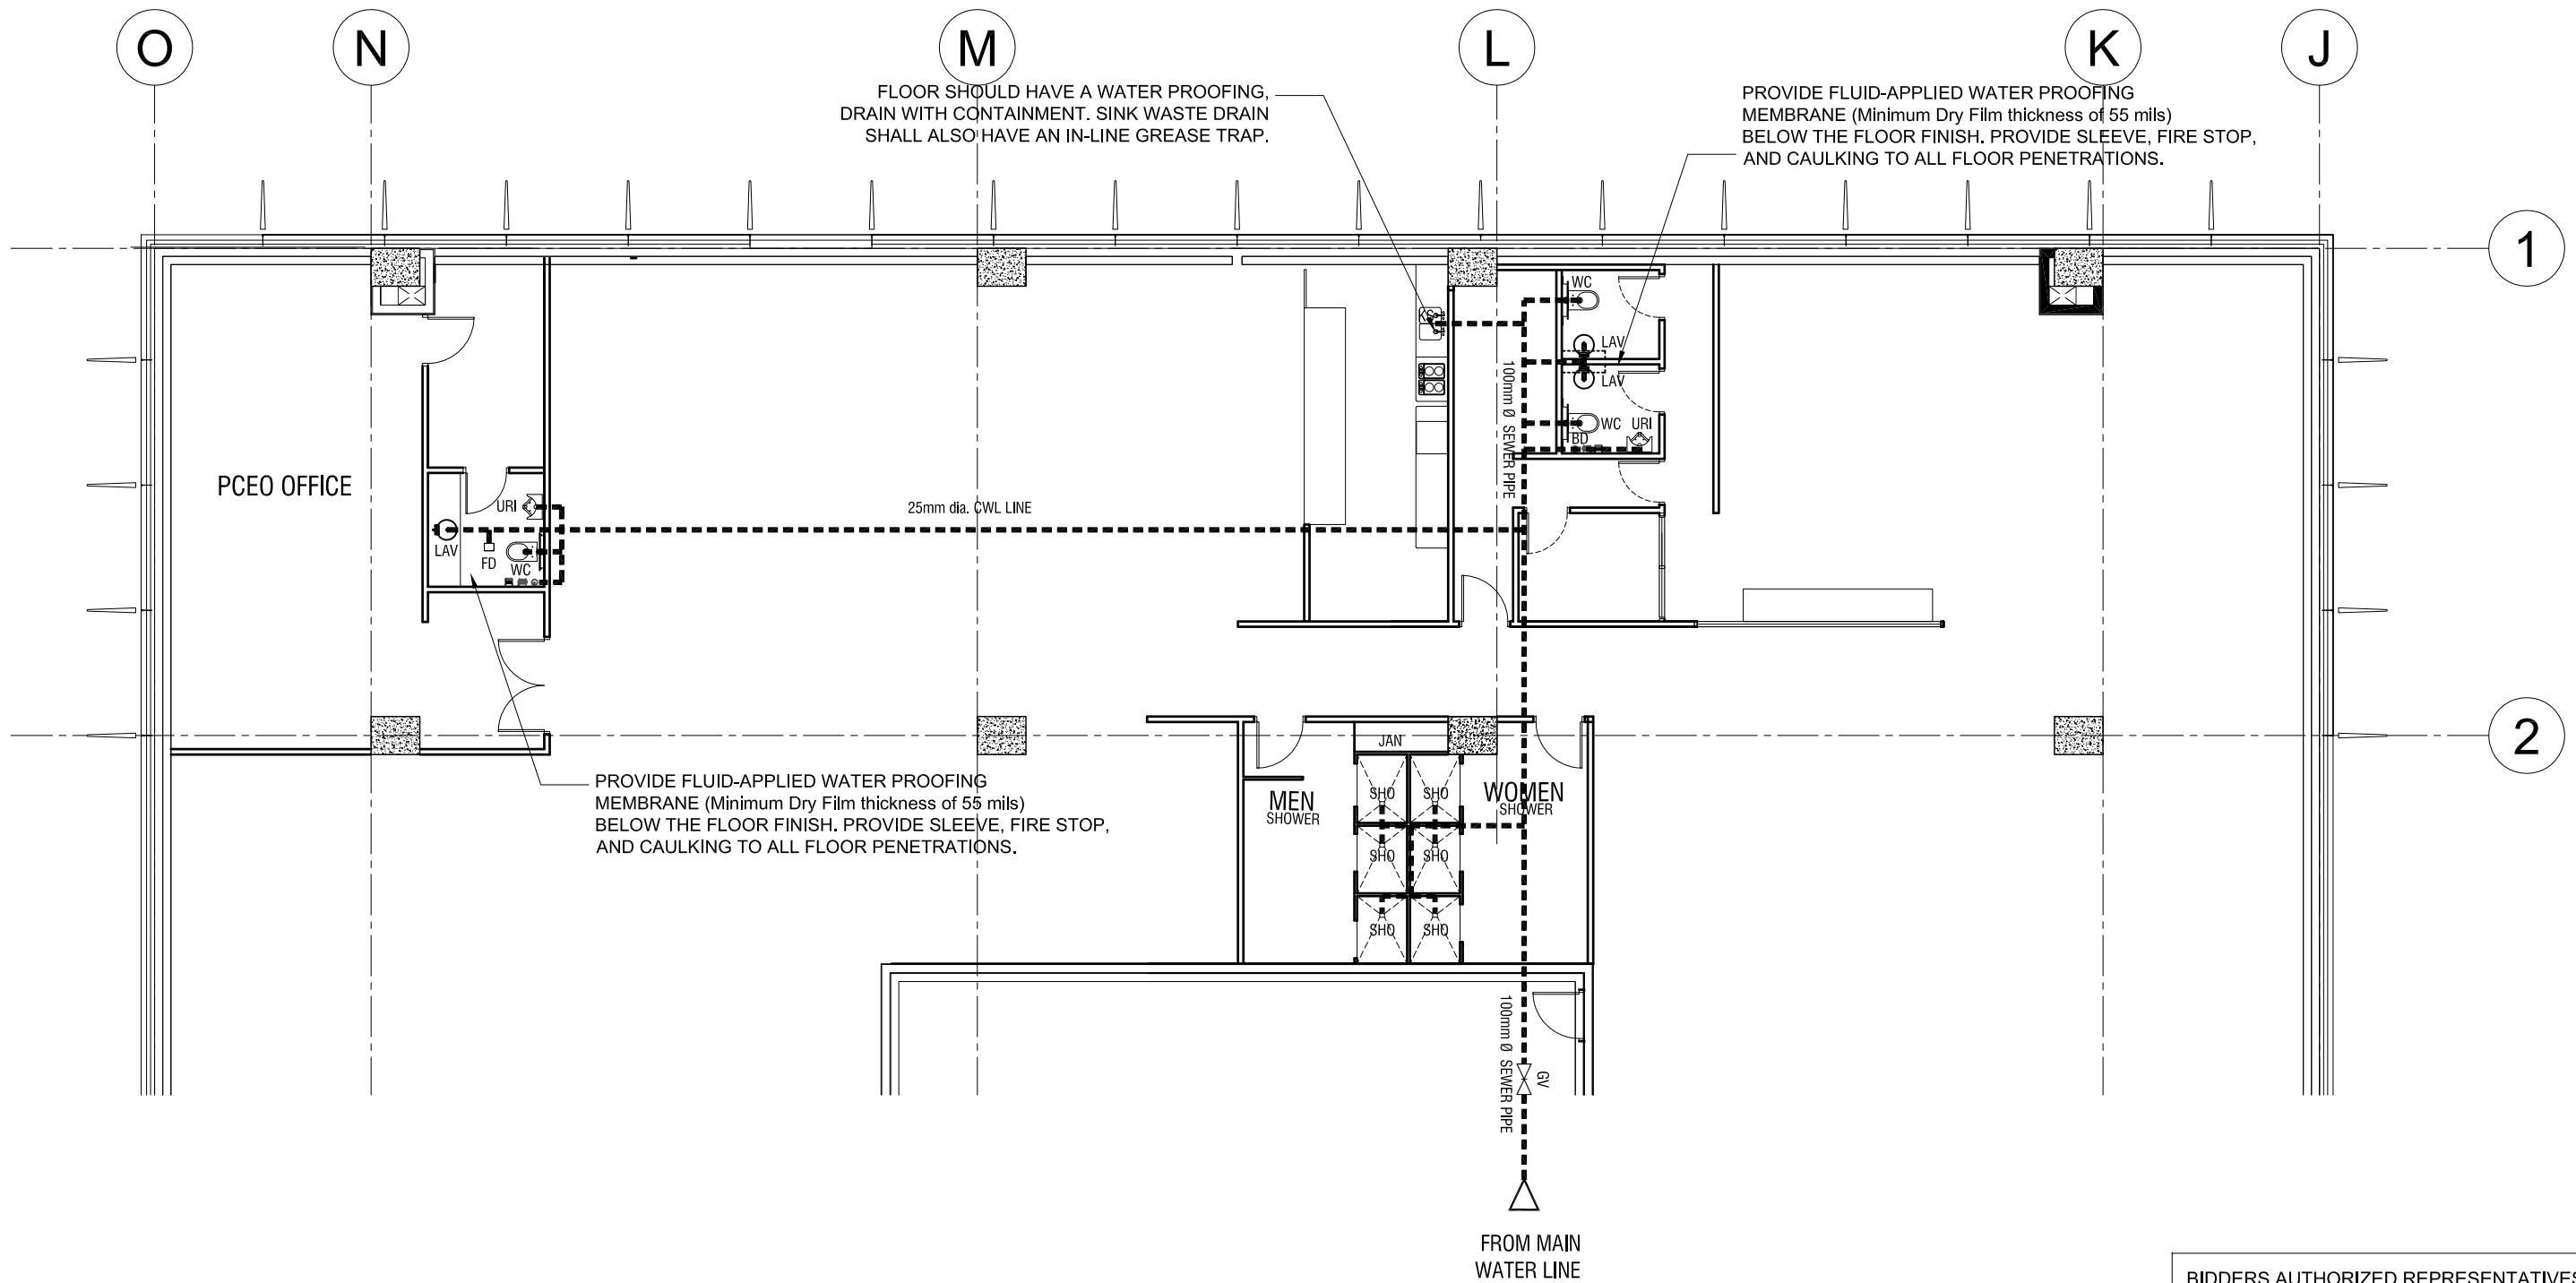

BIDDERS AUTHORIZED REPRESENTATIVES


Signature Over Printed Name



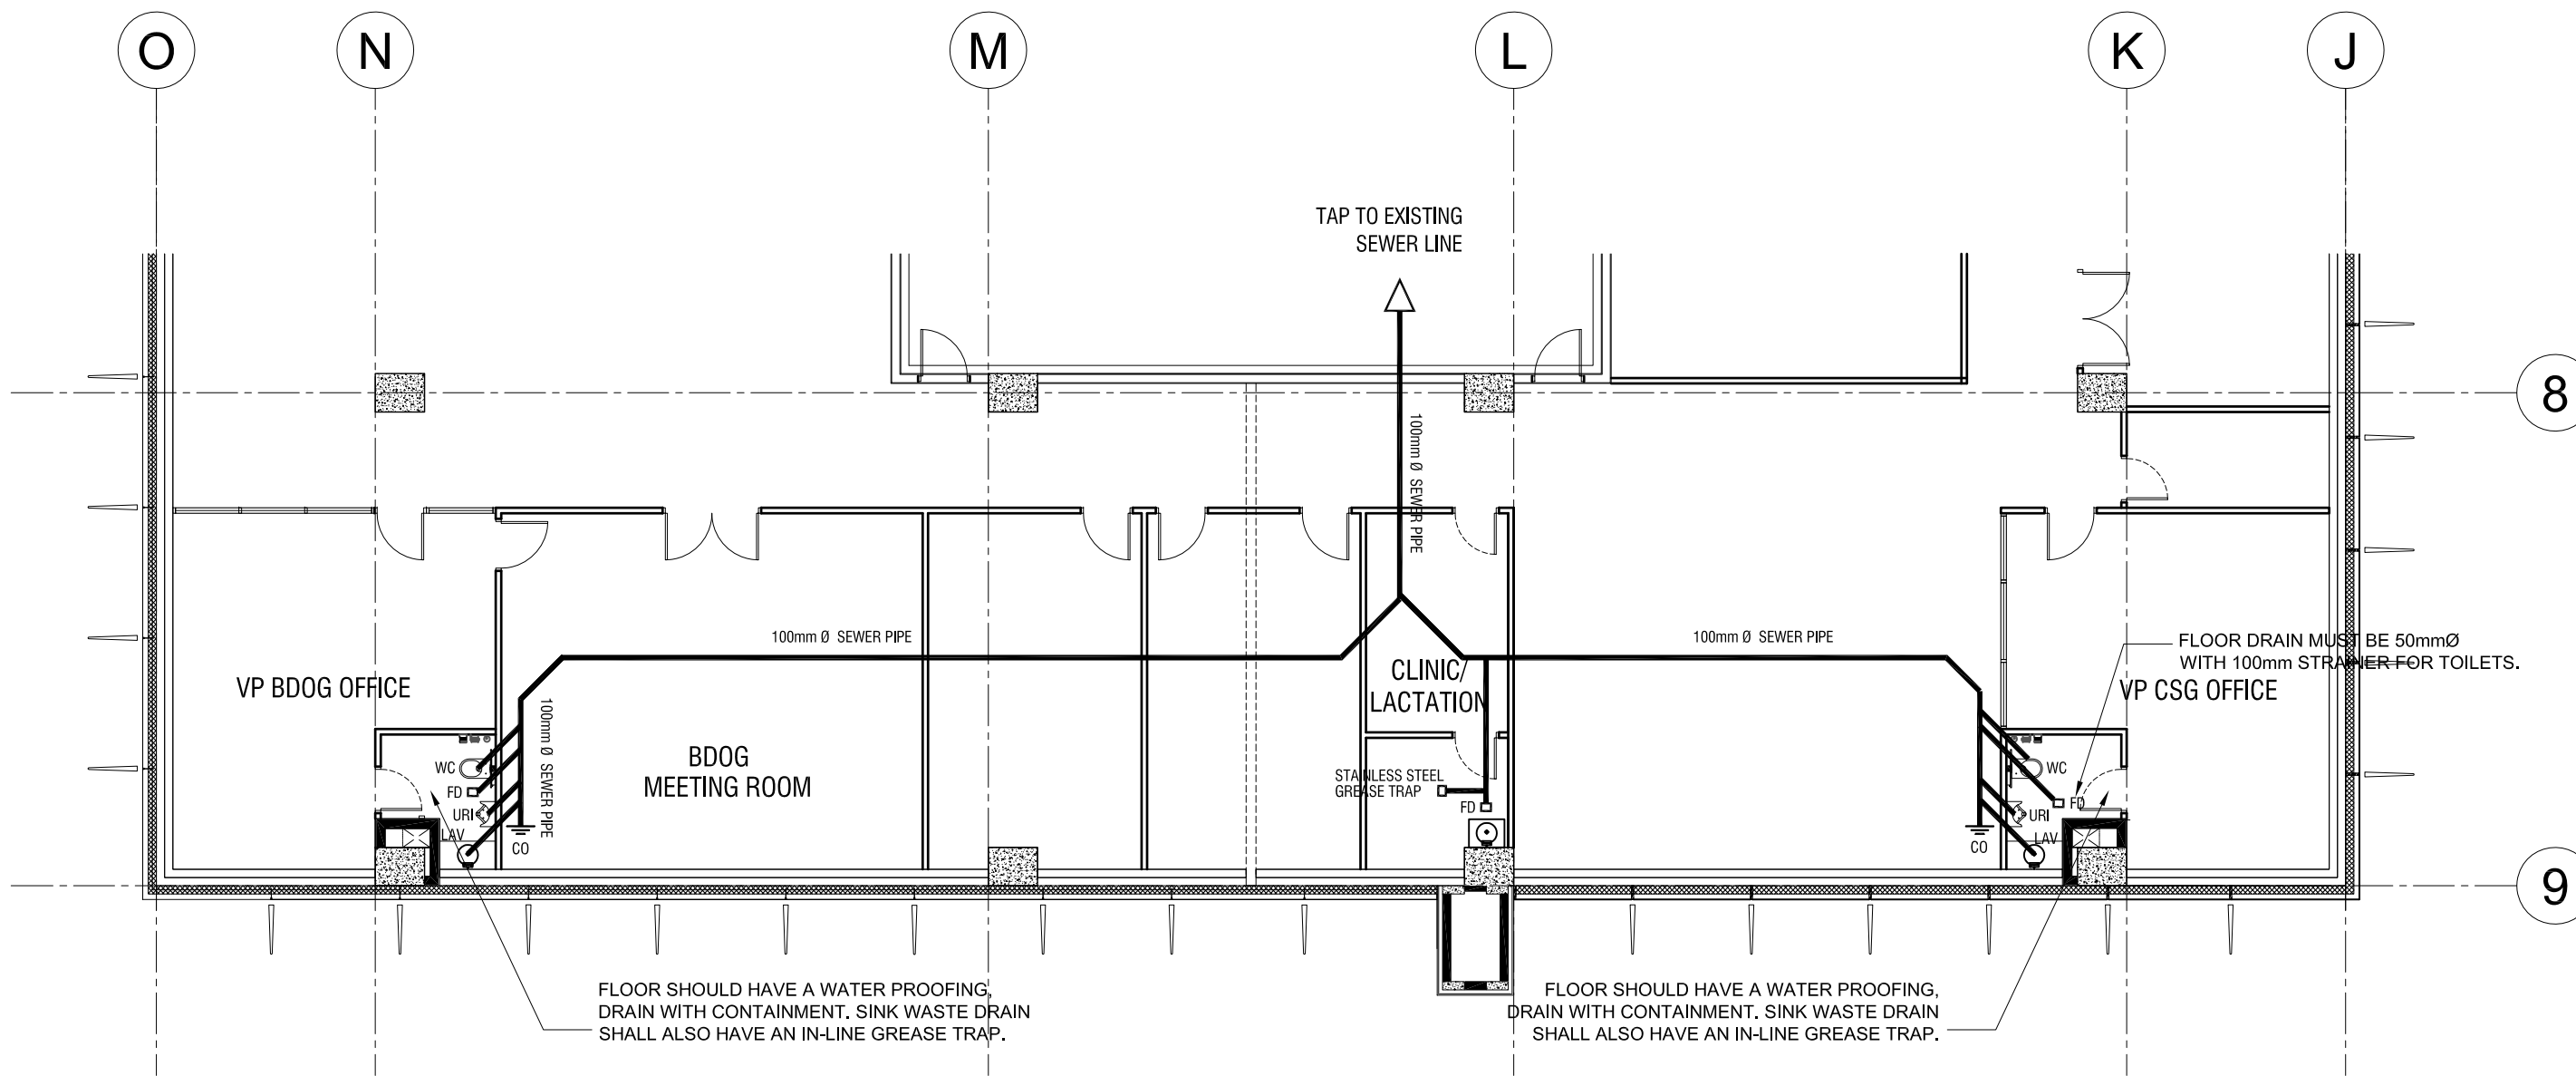

BIDDERS AUTHORIZED REPRESENTATIVES

Signature Over Printed Name

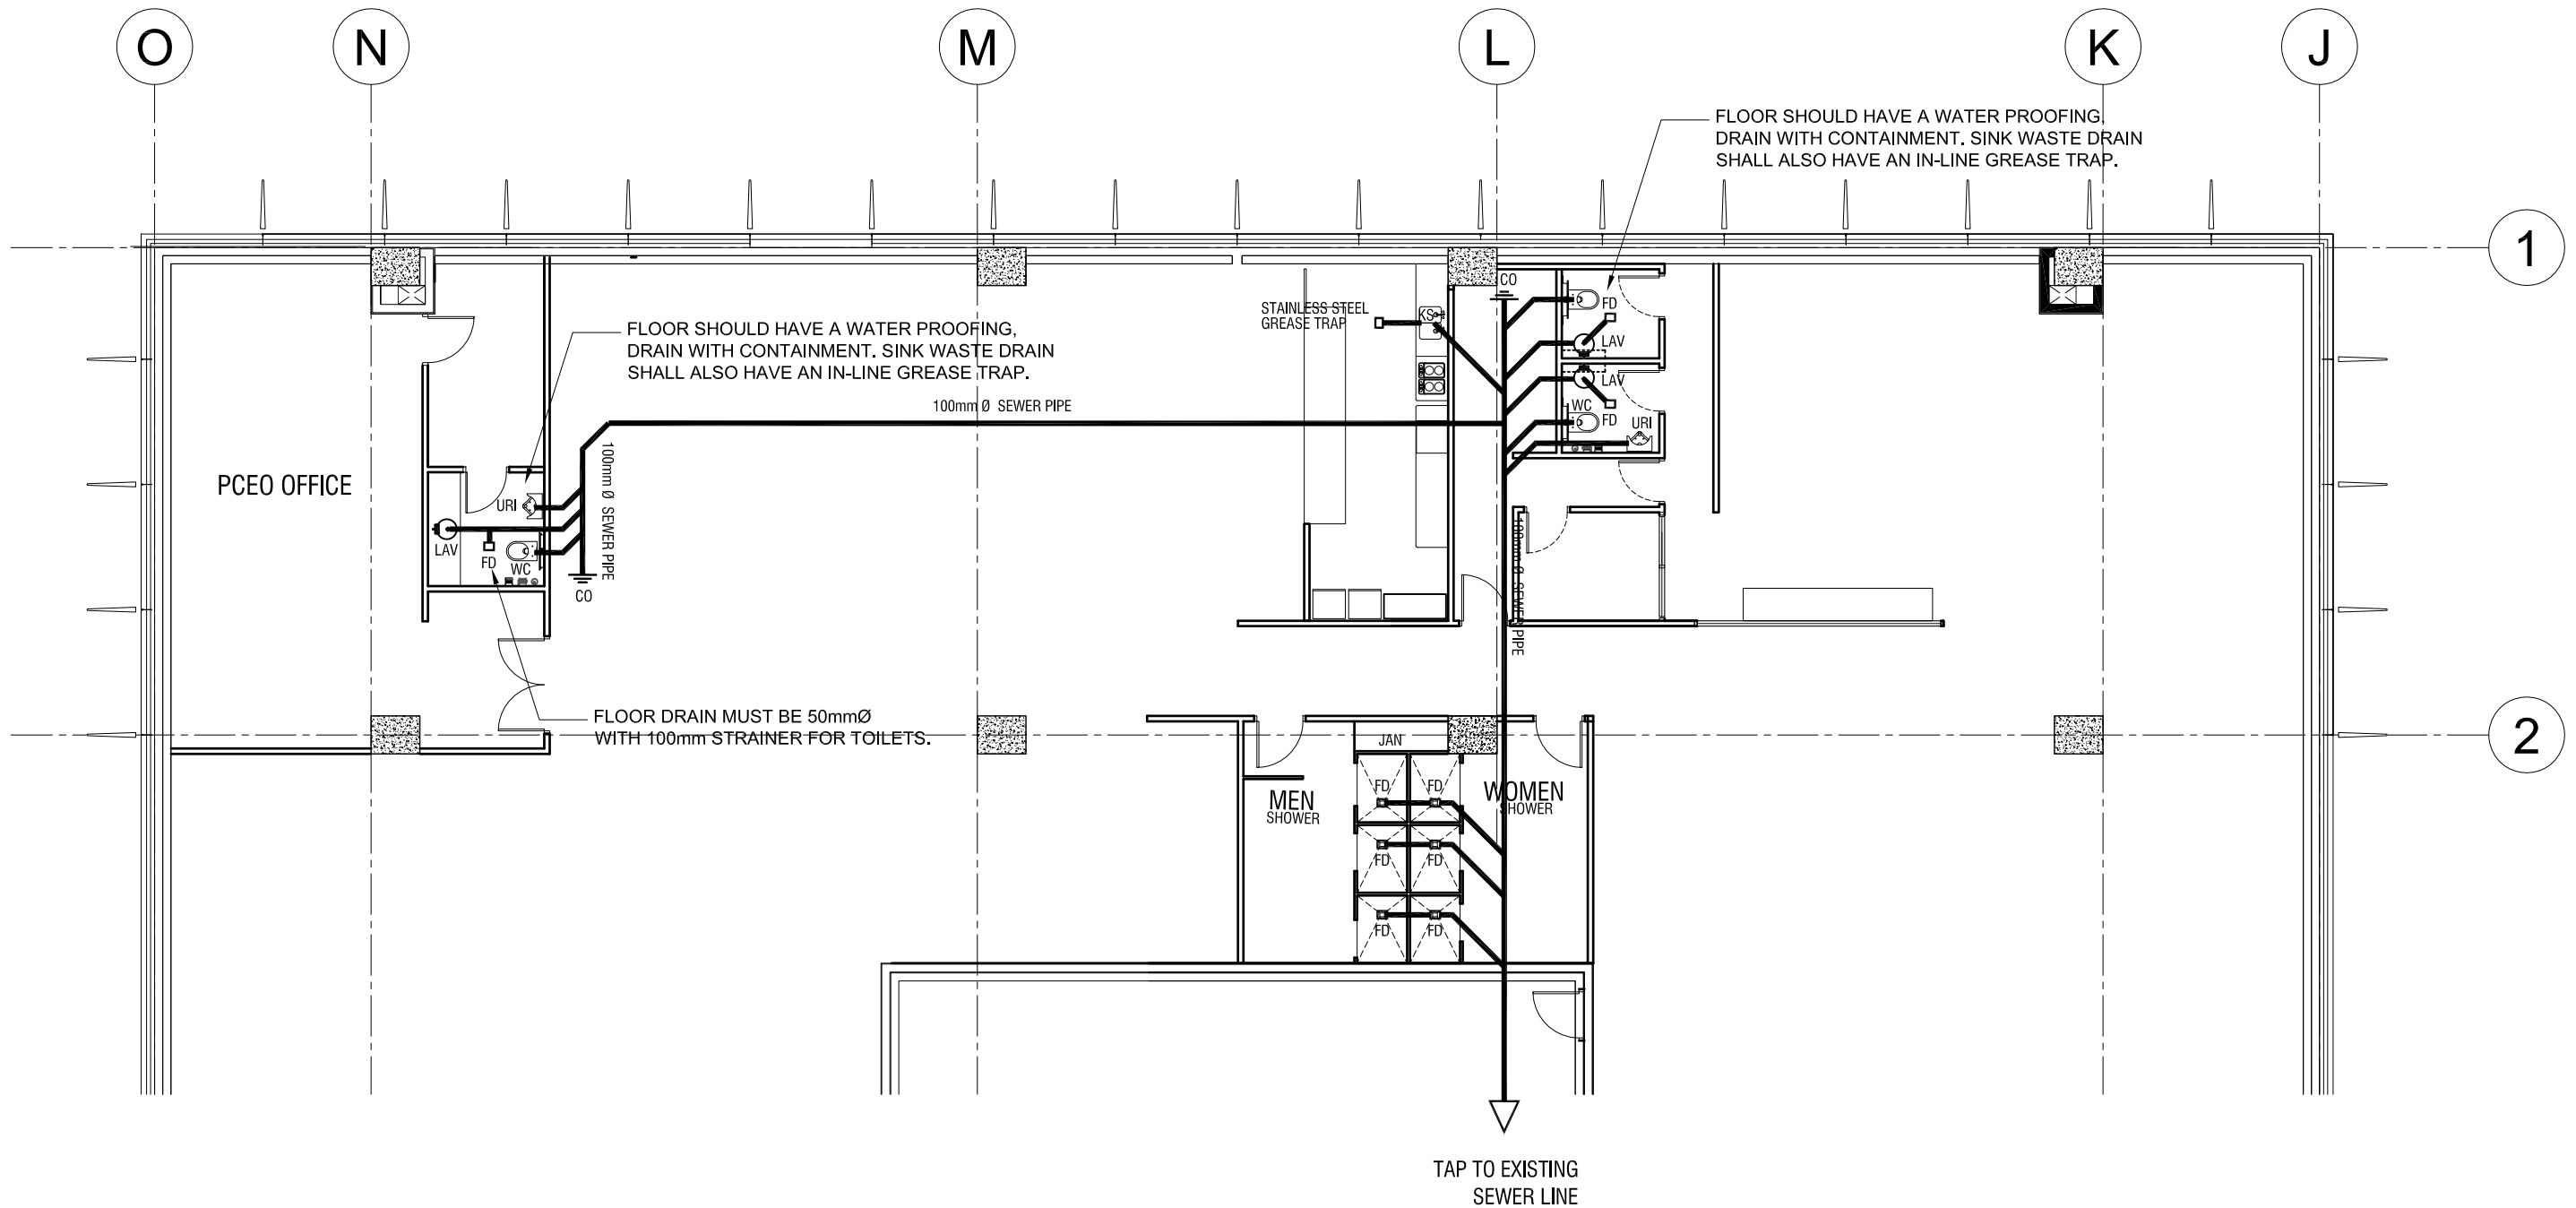

BIDDERS AUTHORIZED REPRESENTATIVES

Signature Over Printed Name